







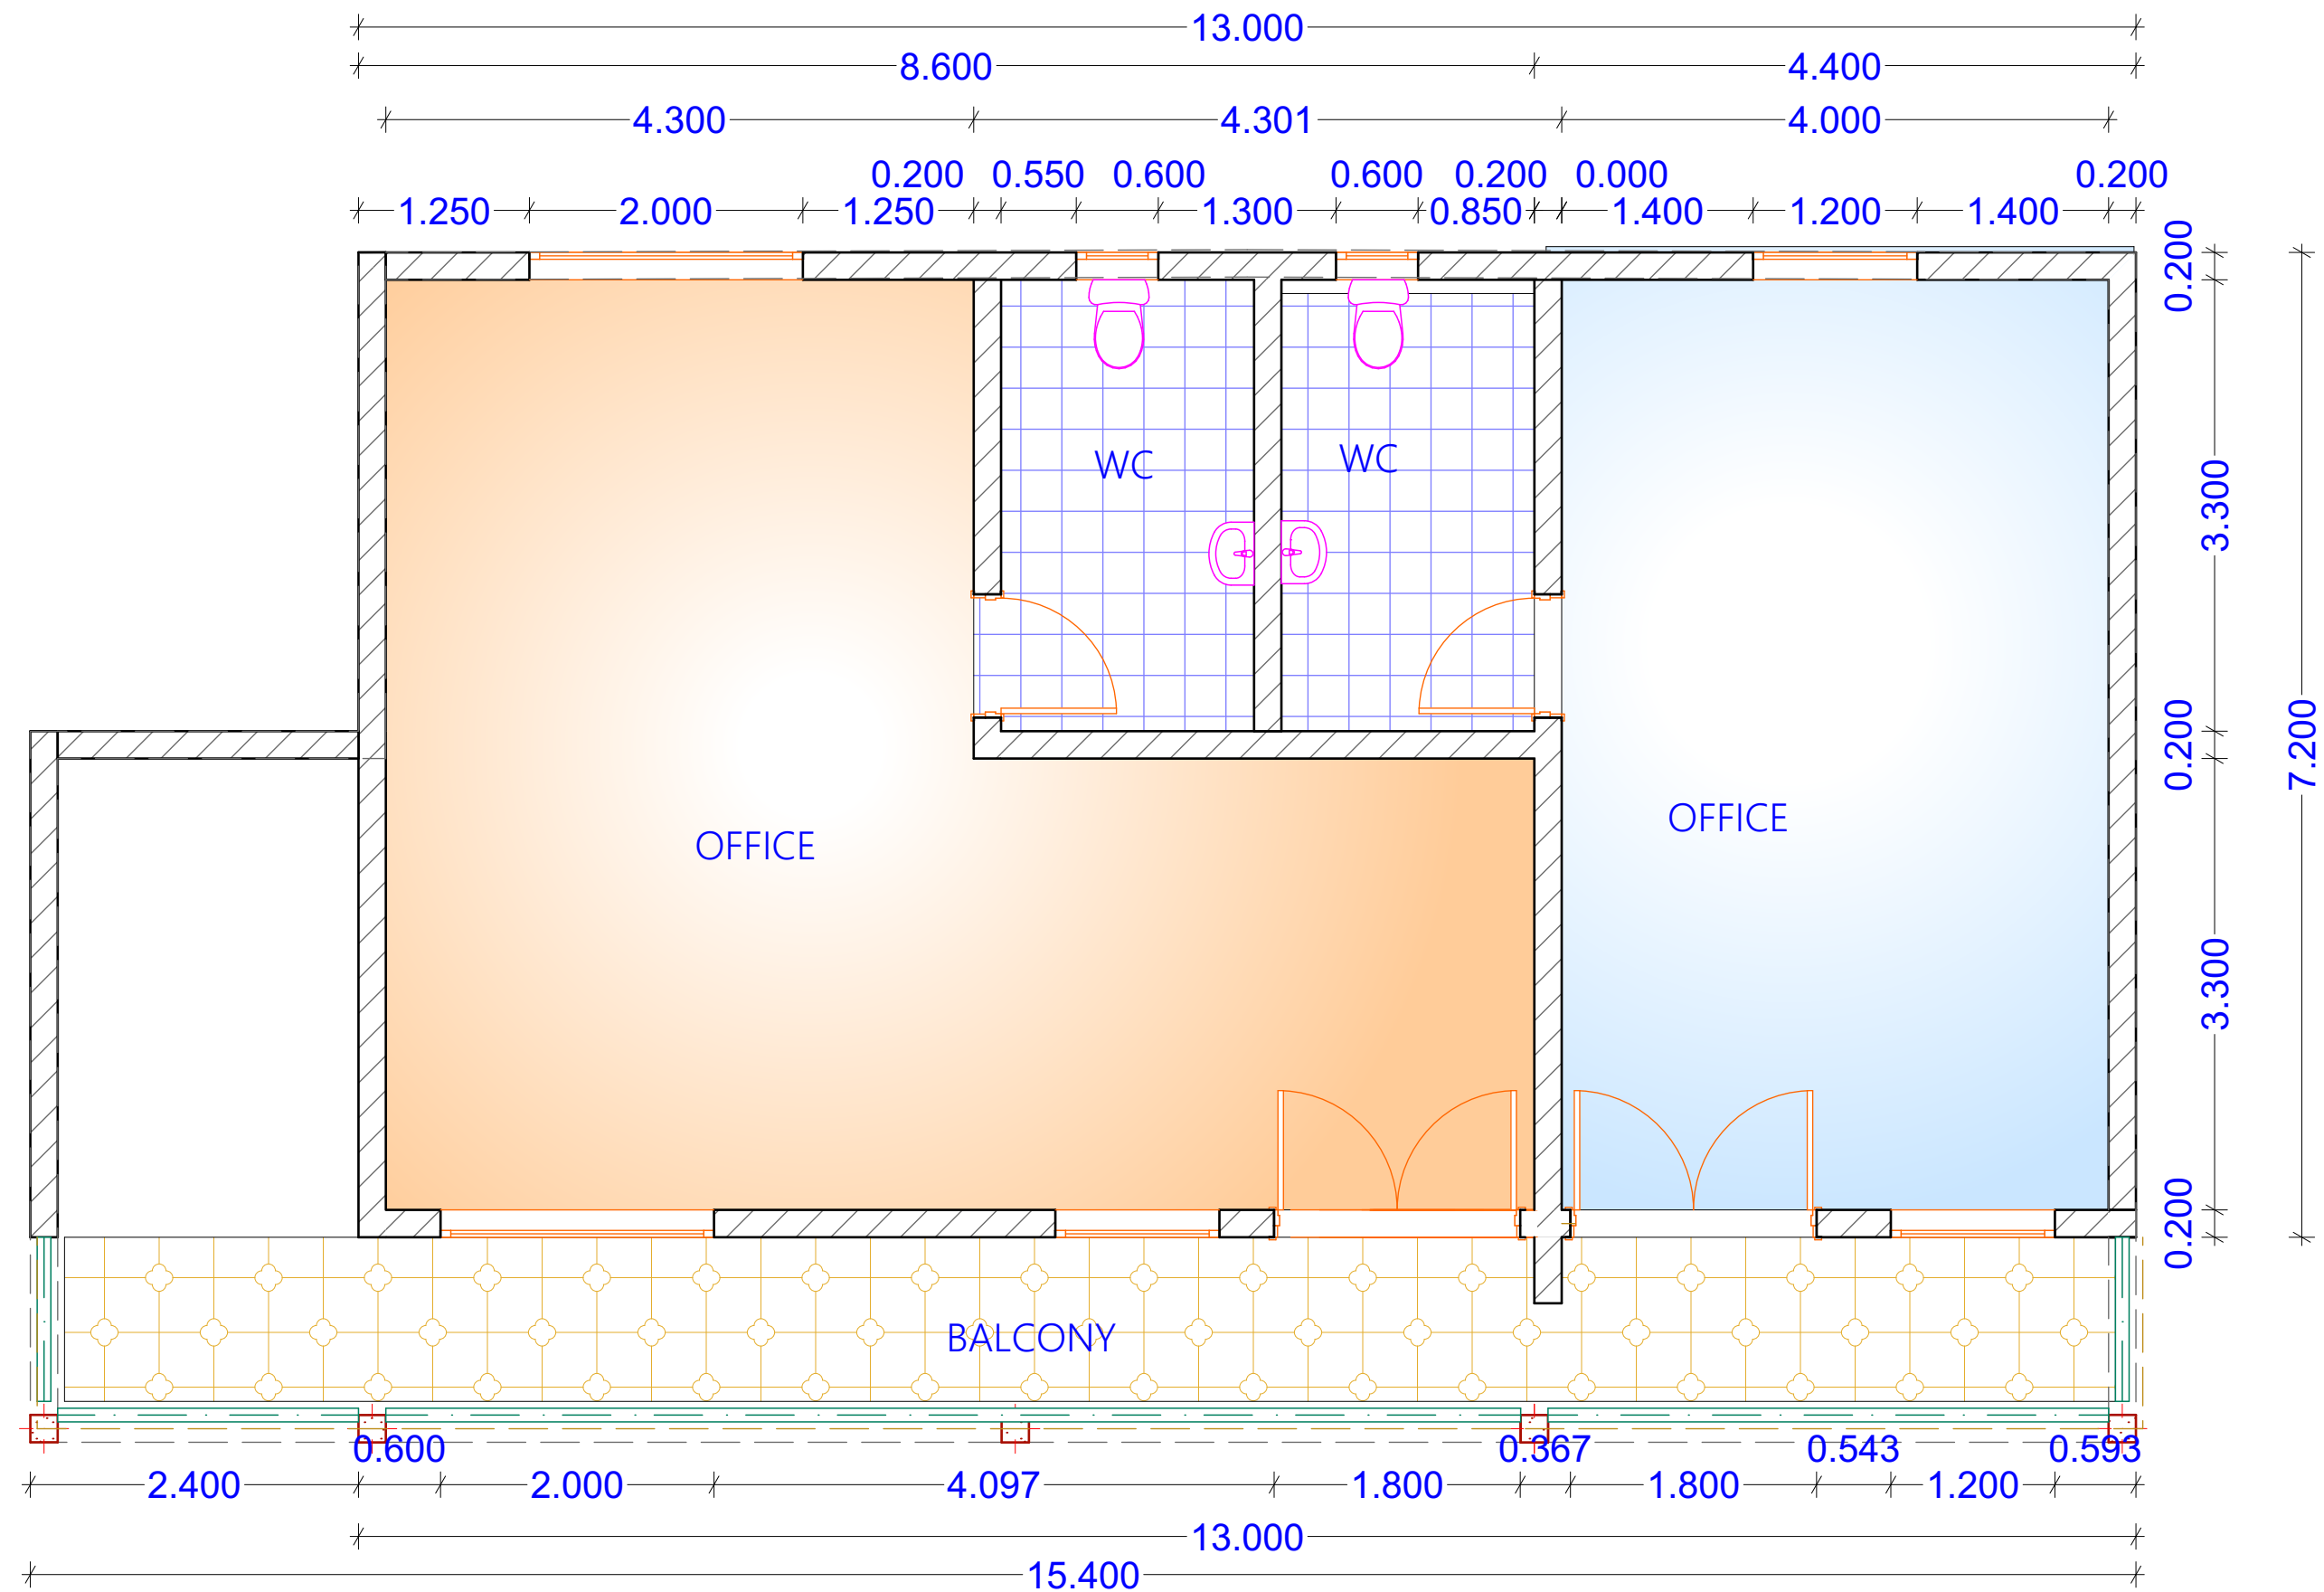
FOUNDATION PLAN- (FOOTING LAYOUT)

PROJECT TITLE:	DONOR:	DRAWING TITLE:	Project No.	Sheet No. 1/24	<div><div>CONCERN</div><div>worldwide</div><div>ENDING EXTREME POVERTY WHATEVER IT TAKES</div><div>Somalia</div></div>
Dinning, Office, Kitchen and Toilets At Gahery Teachers Training Institue Xamar Jajab District, Banadir Region,Somalia	 		Scale: 1:100	Date: Sep 2021	
			Design: H.E.	Checked:	



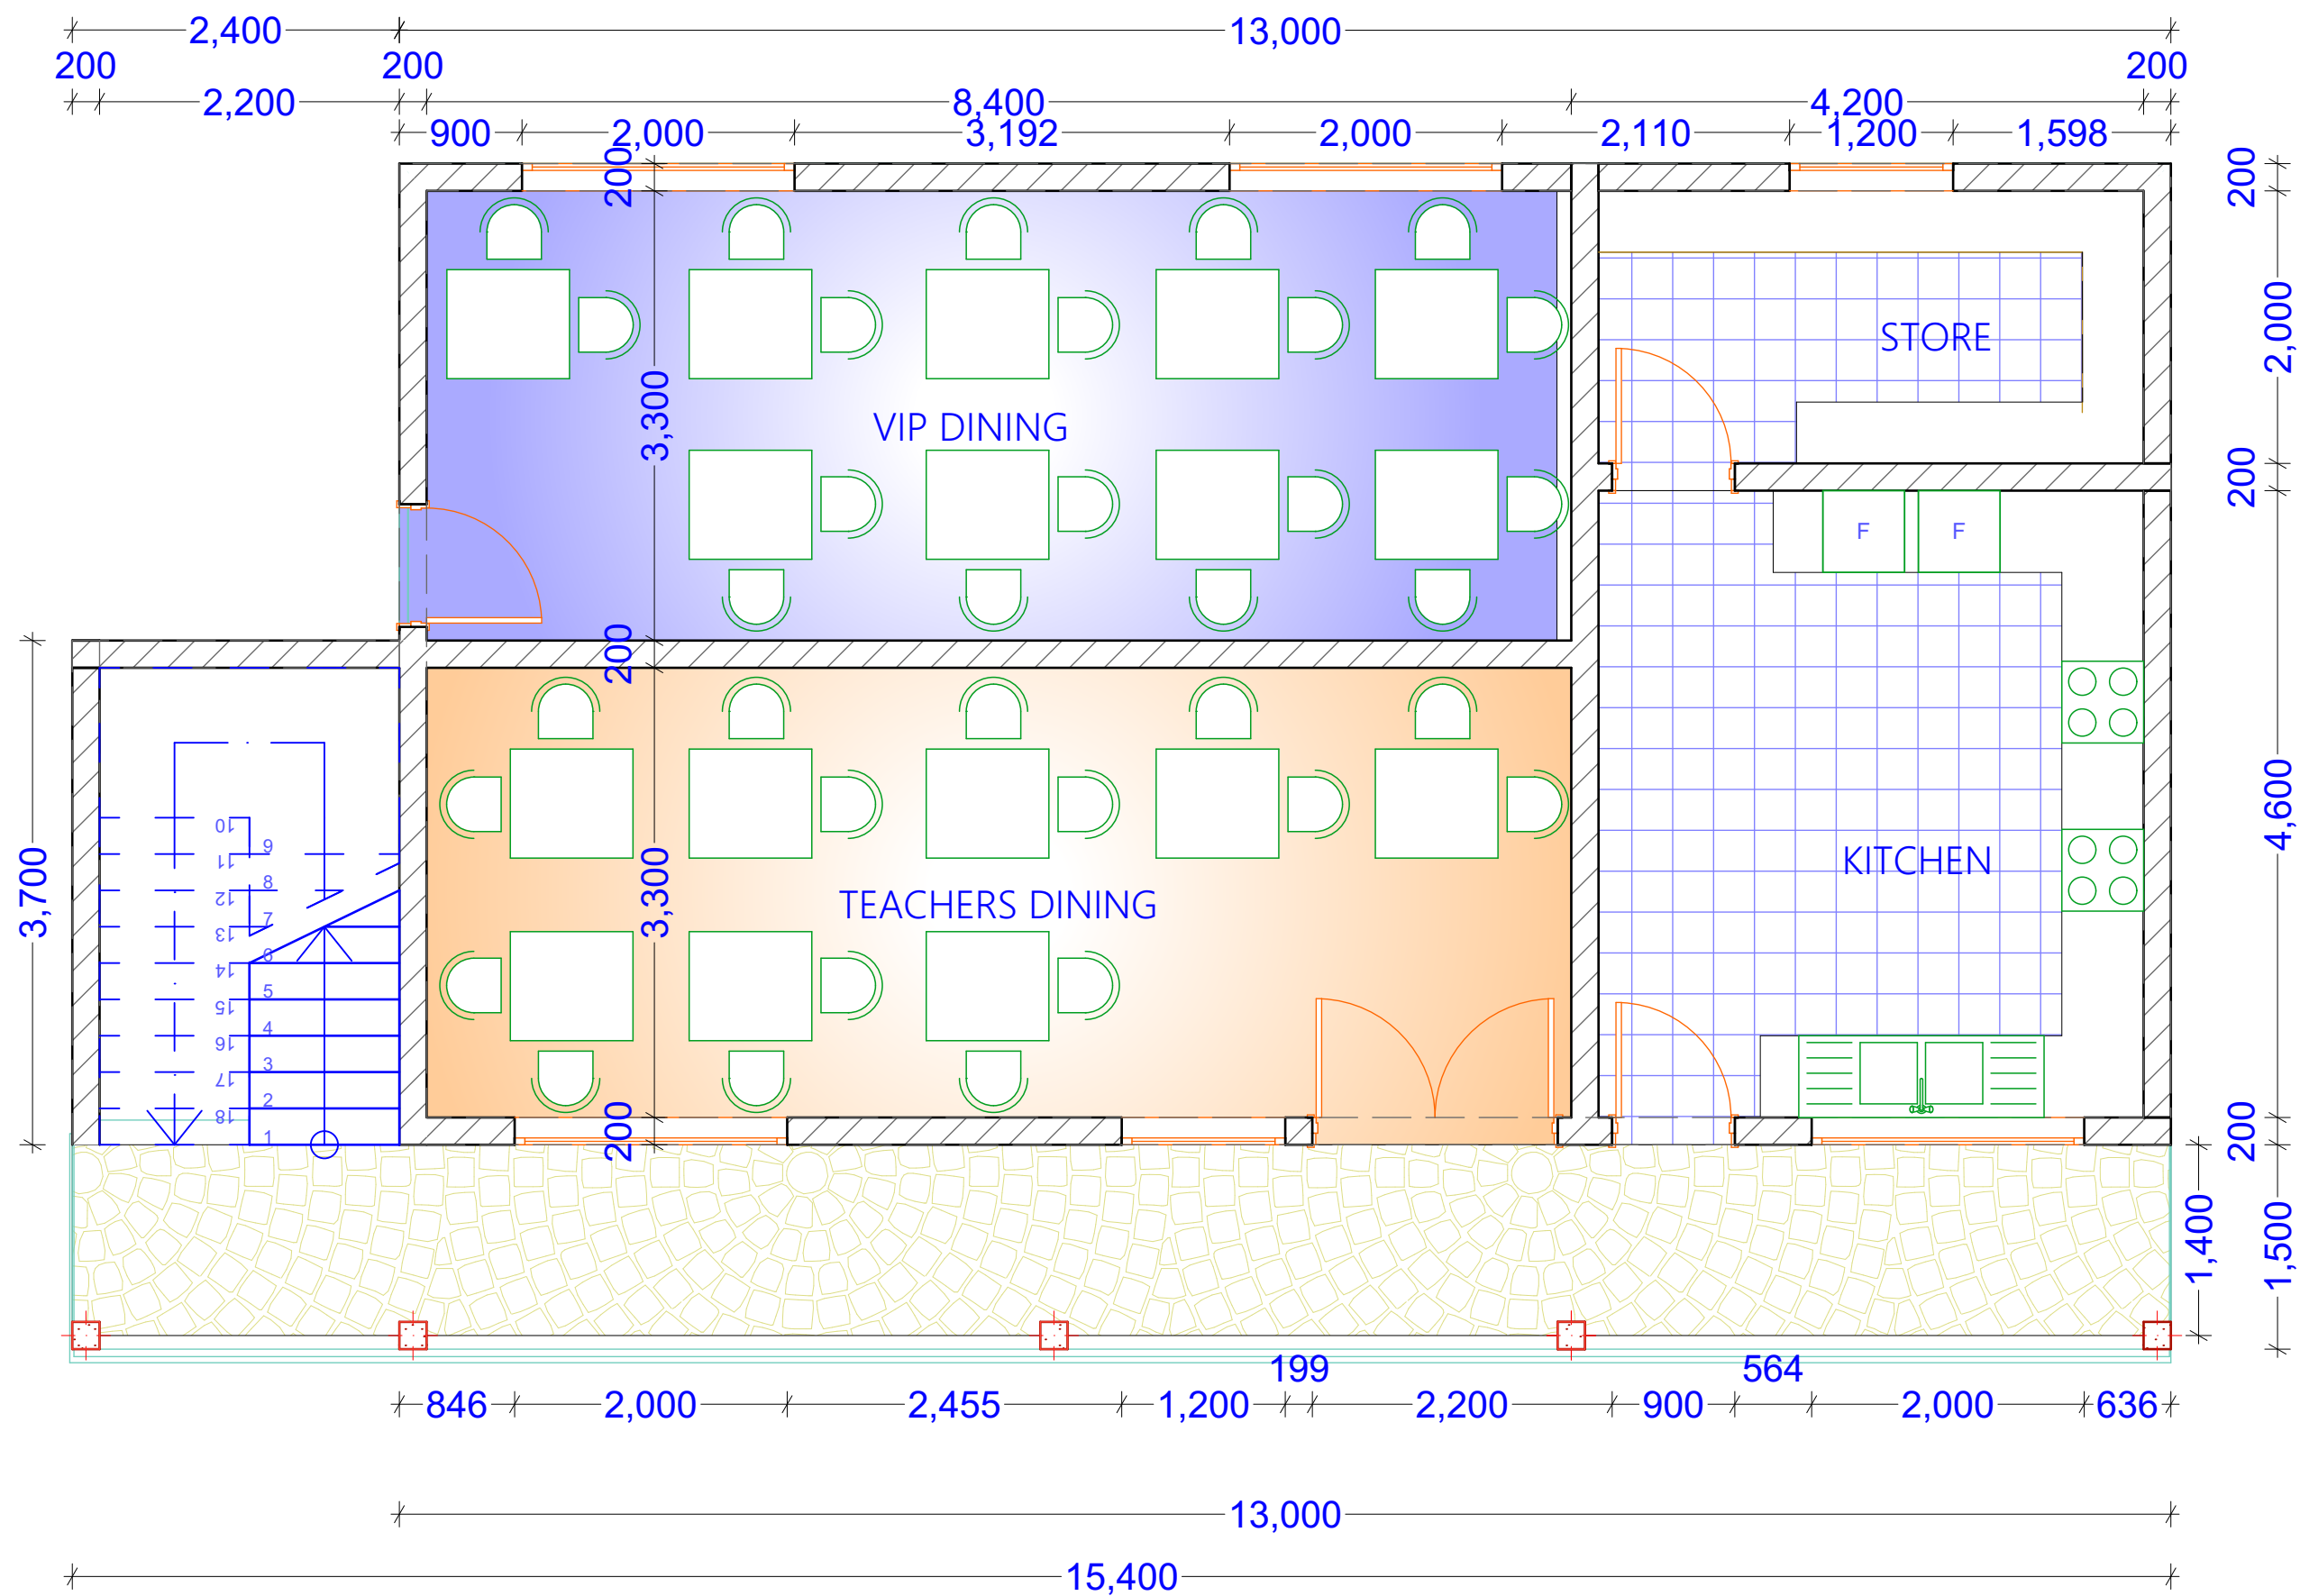


GROUND FLOOR PLAN




PROJECT TITLE:	DONOR:	DRAWING TITLE:	Project No.	Sheet No. 2/24	 ENDING EXTREME POVERTY WHATEVER IT TAKES Somalia
Dinning, Office, Kitchen and Toilets At Gahery Teachers Training Institue Xamar Jajab District, Banadir Region,Somalia	 		Scale: 1:100	Date: Sep 2021	
			Design: H.E.	Checked:	






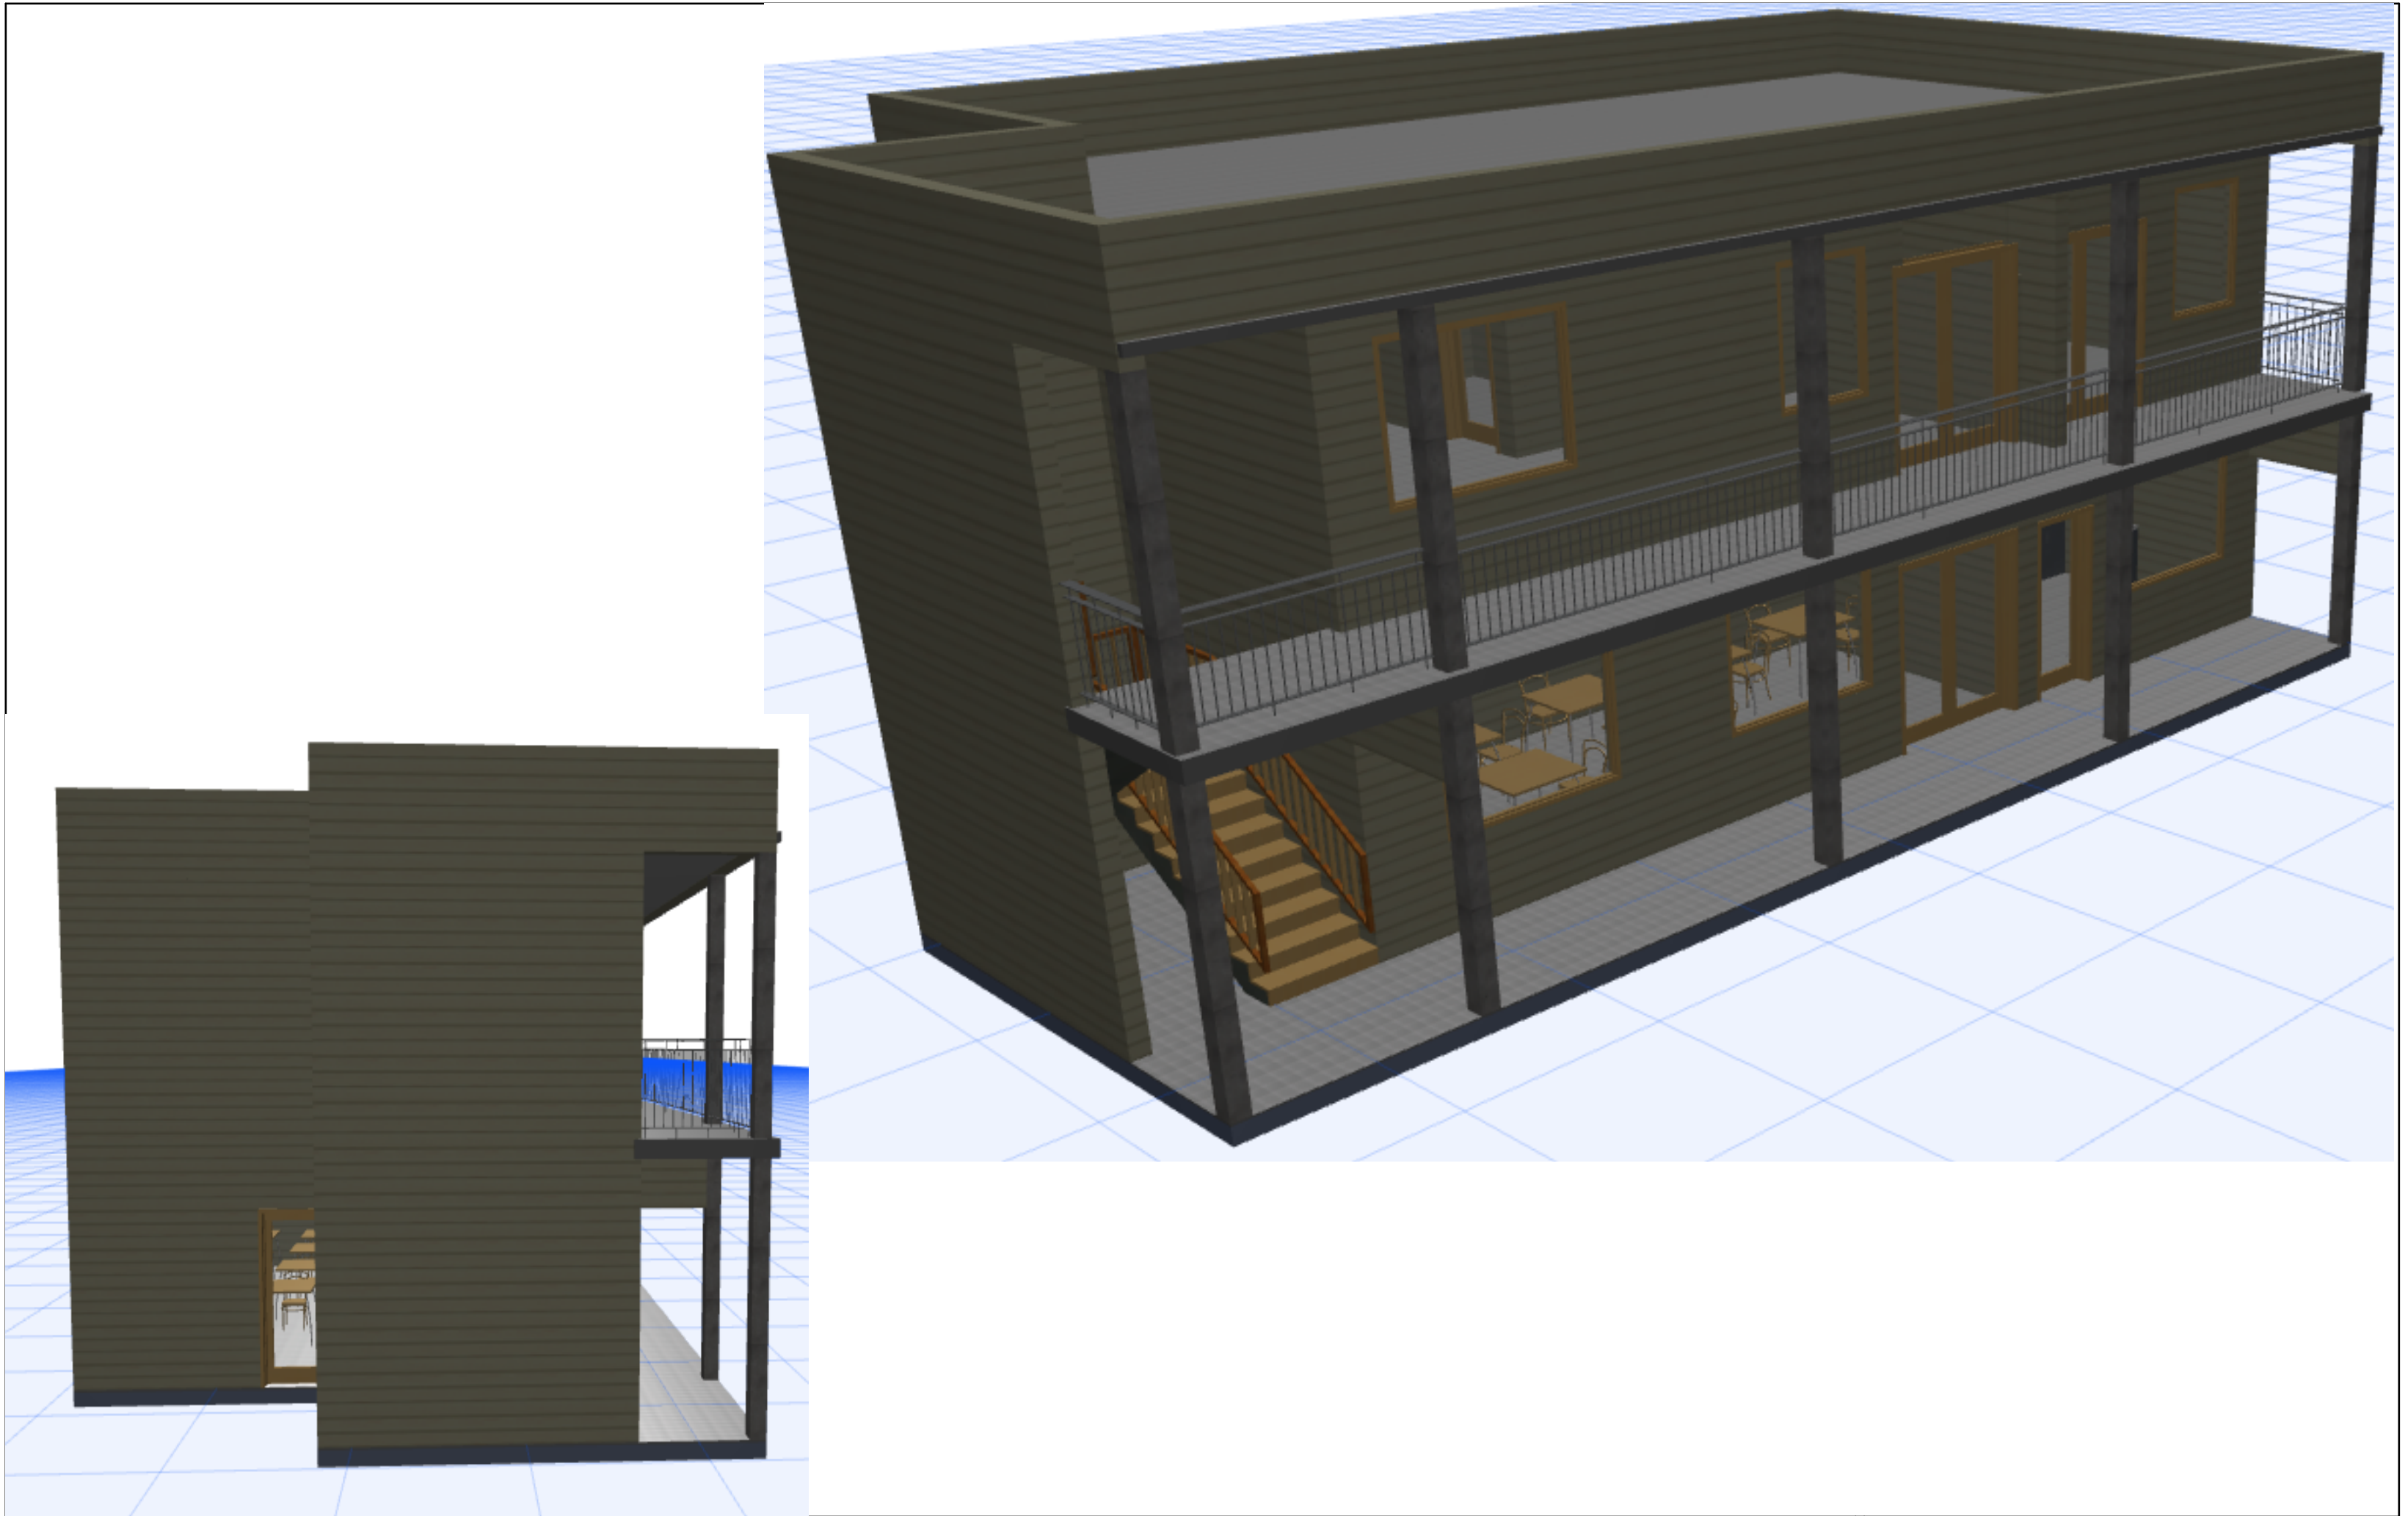

FIRST FLOOR PLAN



PROJECT TITLE:	DONOR:	DRAWING TITLE:	Project No.	Sheet No. 3/24	<div>CONCERN worldwide</div> <div>ENDING EXTREME POVERTY WHATEVER IT TAKES</div> <div>Somalia</div>
Dinning, Office, Kitchen and Toilets At Gahery Teachers Training Institue Xamar Jajab District, Banadir Region,Somalia	 		Scale: 1:100	Date: Sep 2021	
			Design: H.E.	Checked:	

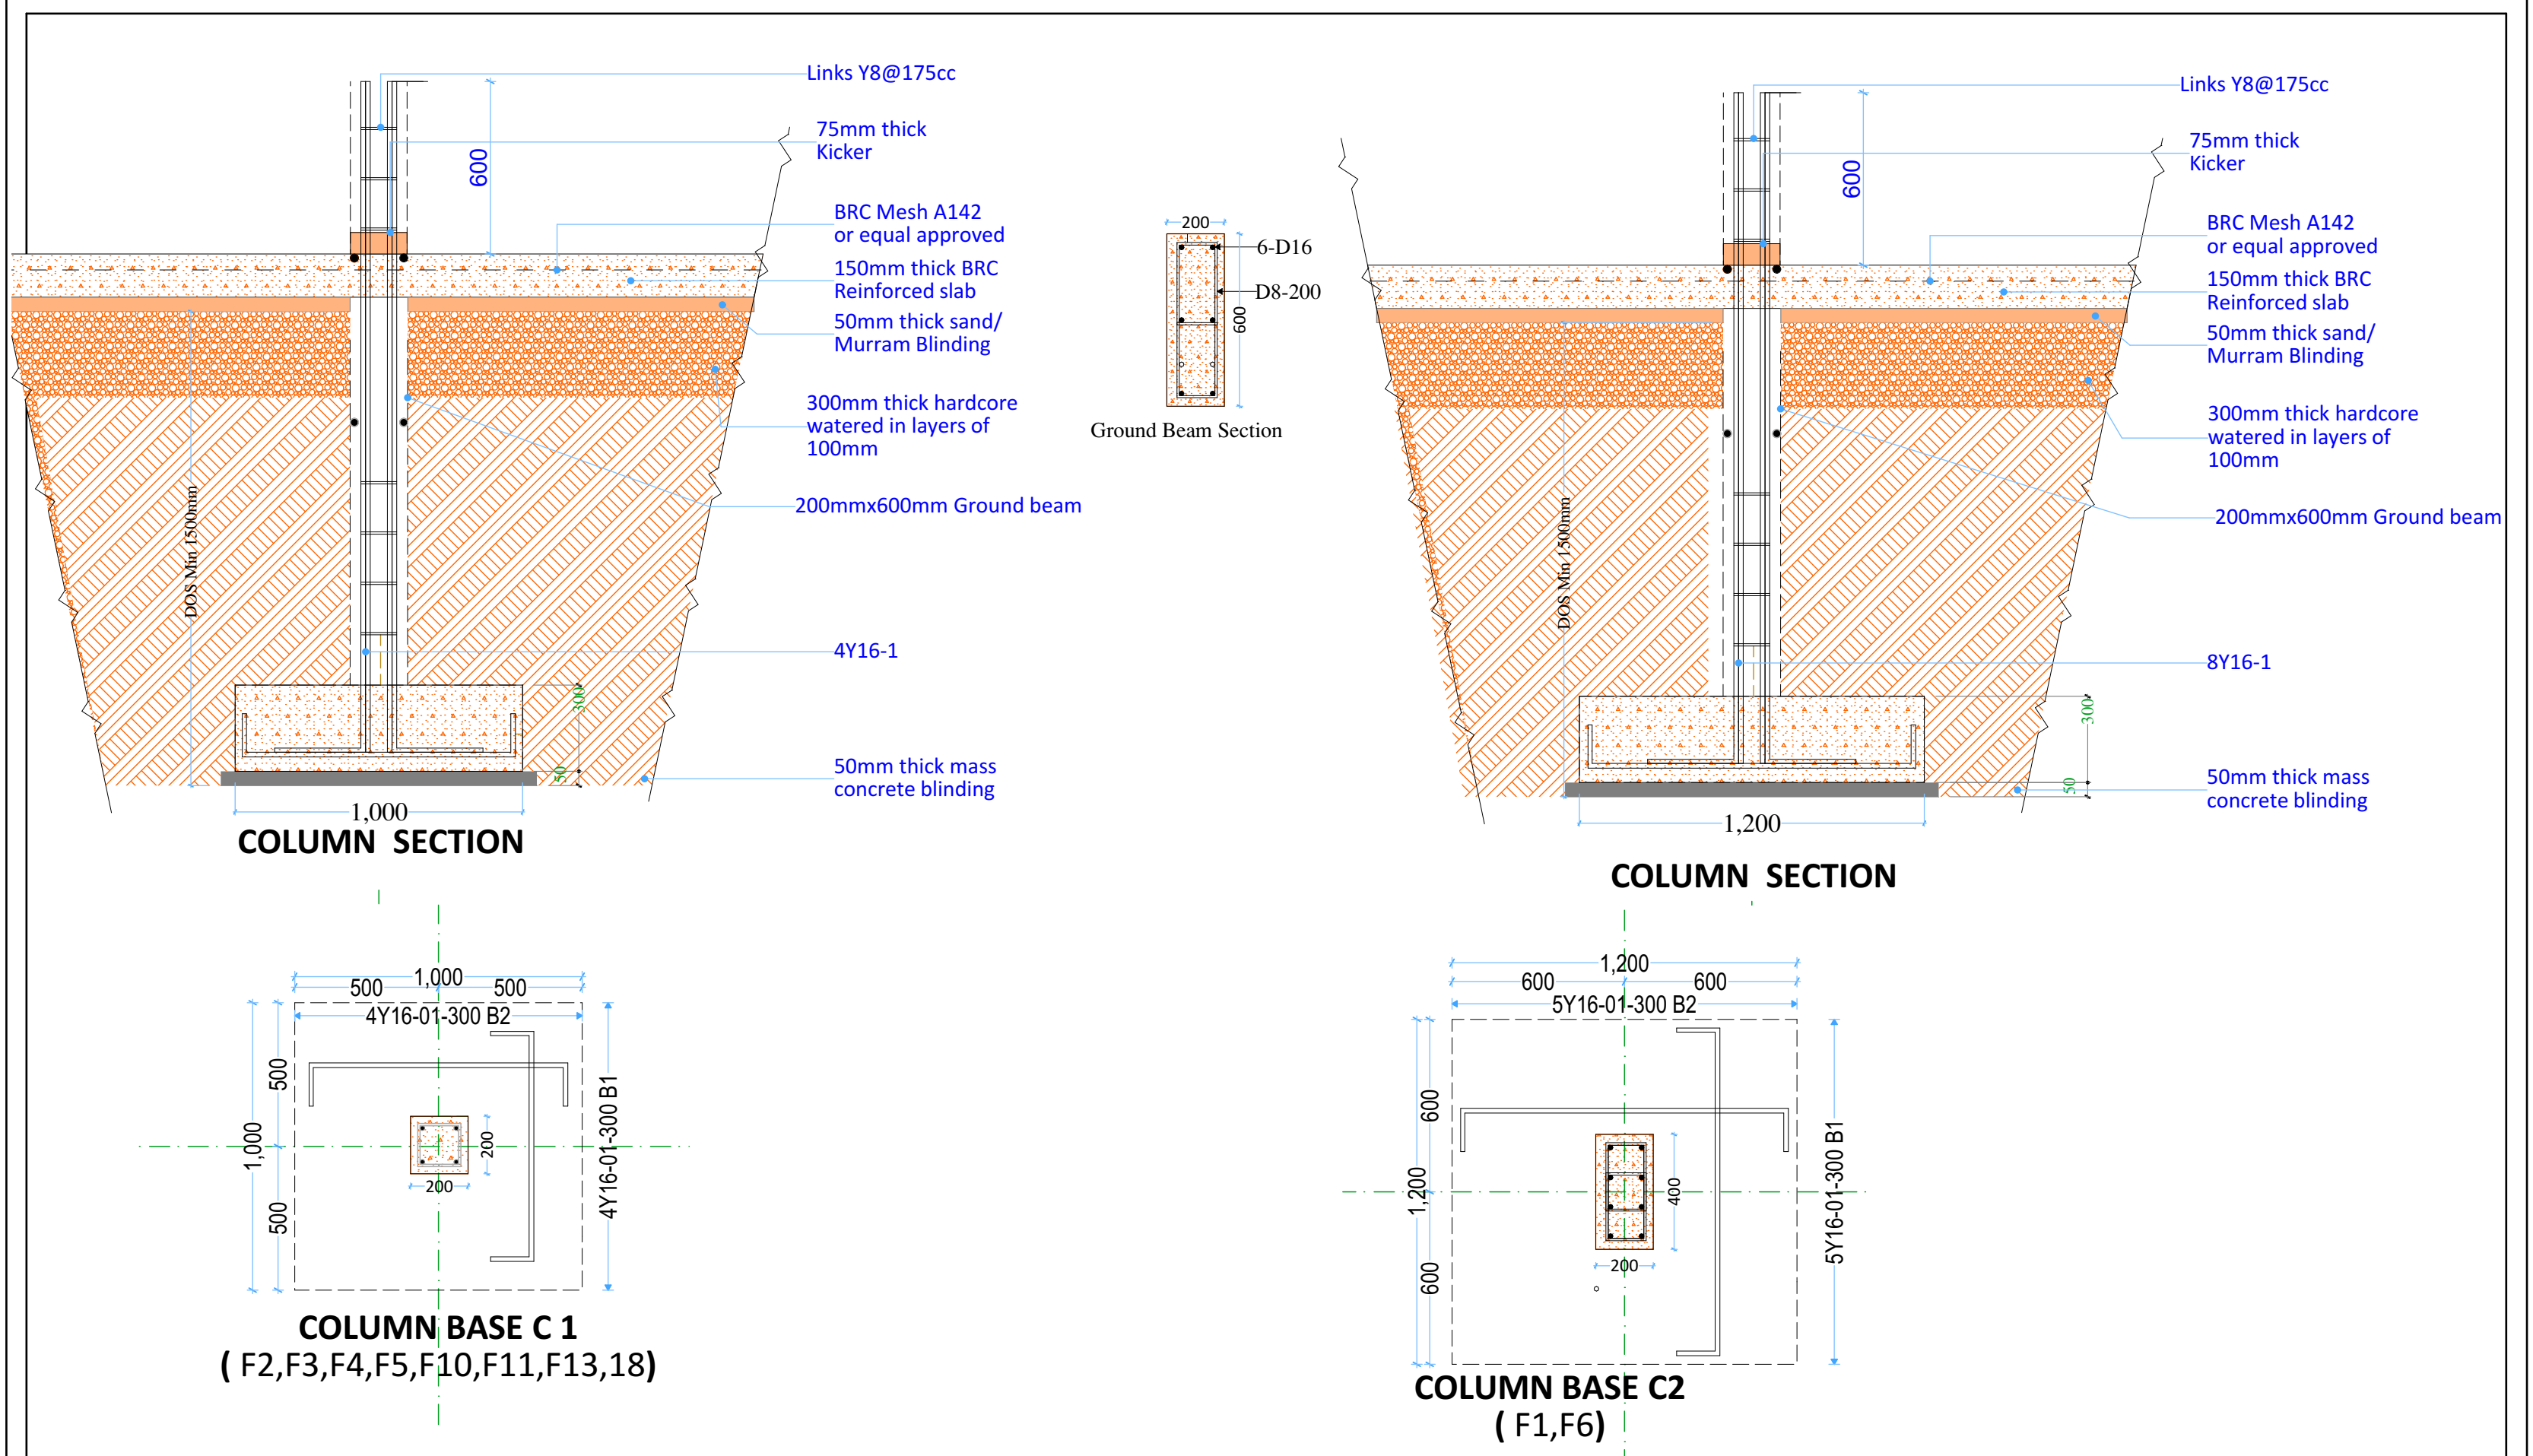



PROJECT TITLE:	DONOR:	DRAWING TITLE:	Project No.	Sheet No. 3/24	 ENDING EXTREME POVERTY WHATEVER IT TAKES Somalia
Dinning, Office, Kitchen and Toilets At Gahery Teachers Training Institue Xamar Jajab District, Banadir Region,Somalia	 		Scale: 1:100	Date: Sep 2021	
			Design: H.E.	Checked:	



PROJECT TITLE:	DONOR:	DRAWING TITLE:	Project No.	Sheet No. 5/24	  Somalia
Dinning, Office, Kitchen and Toilets At Gahery Teachers Training Institue Xamar Jajab District, Banadir Region,Somalia	 		Scale: 1:100	Date: Sep 2021	
			Design: H.E.	Checked:	

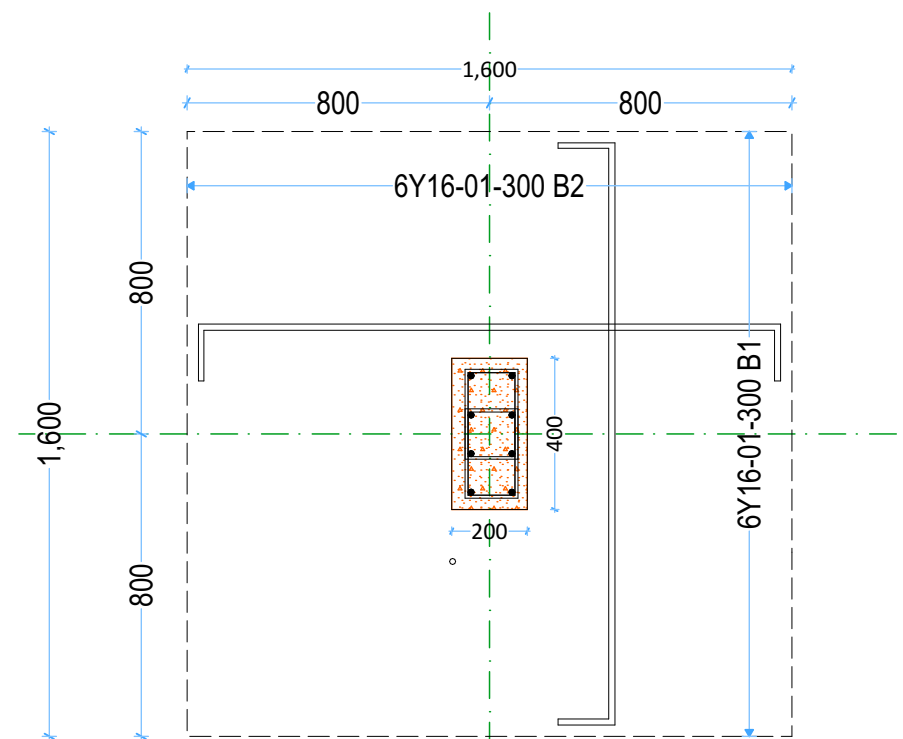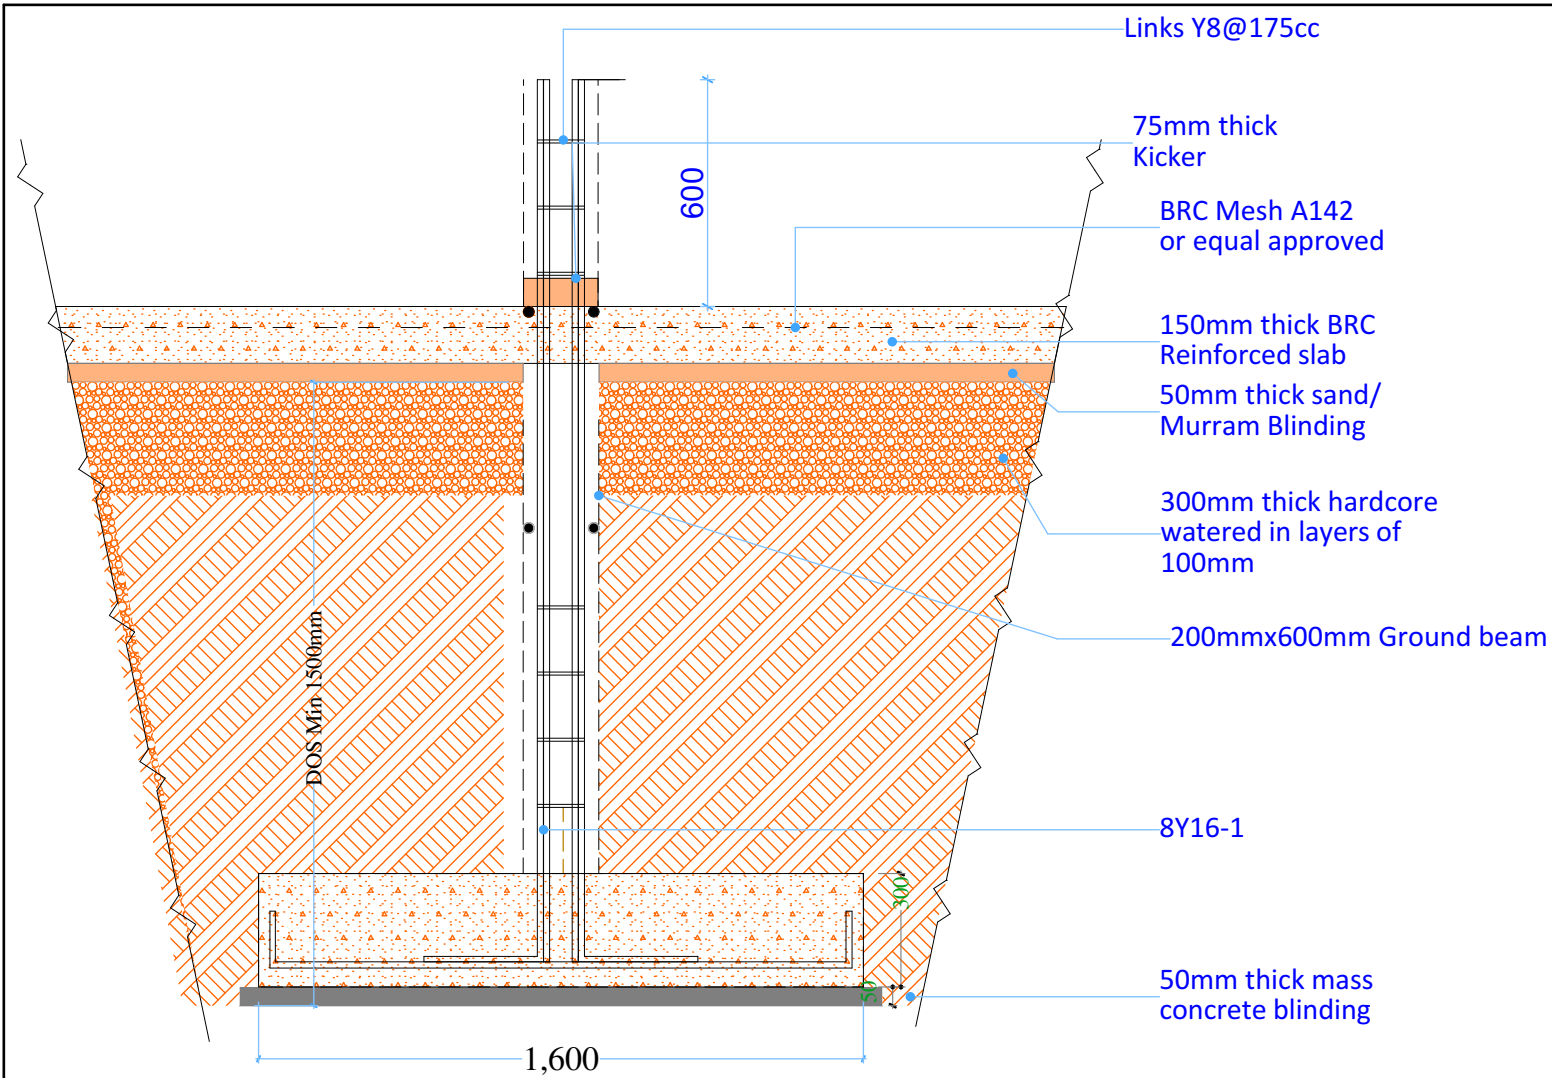

COLUMN BASE C3
(F7,F8,F9,F12,F14,F17,F19)

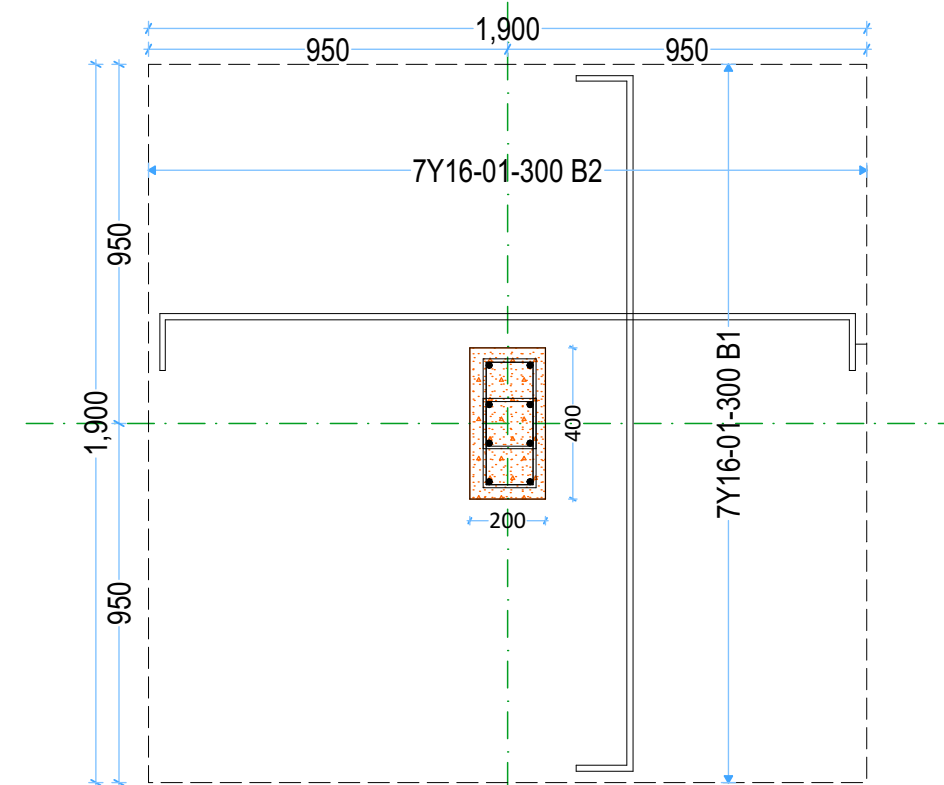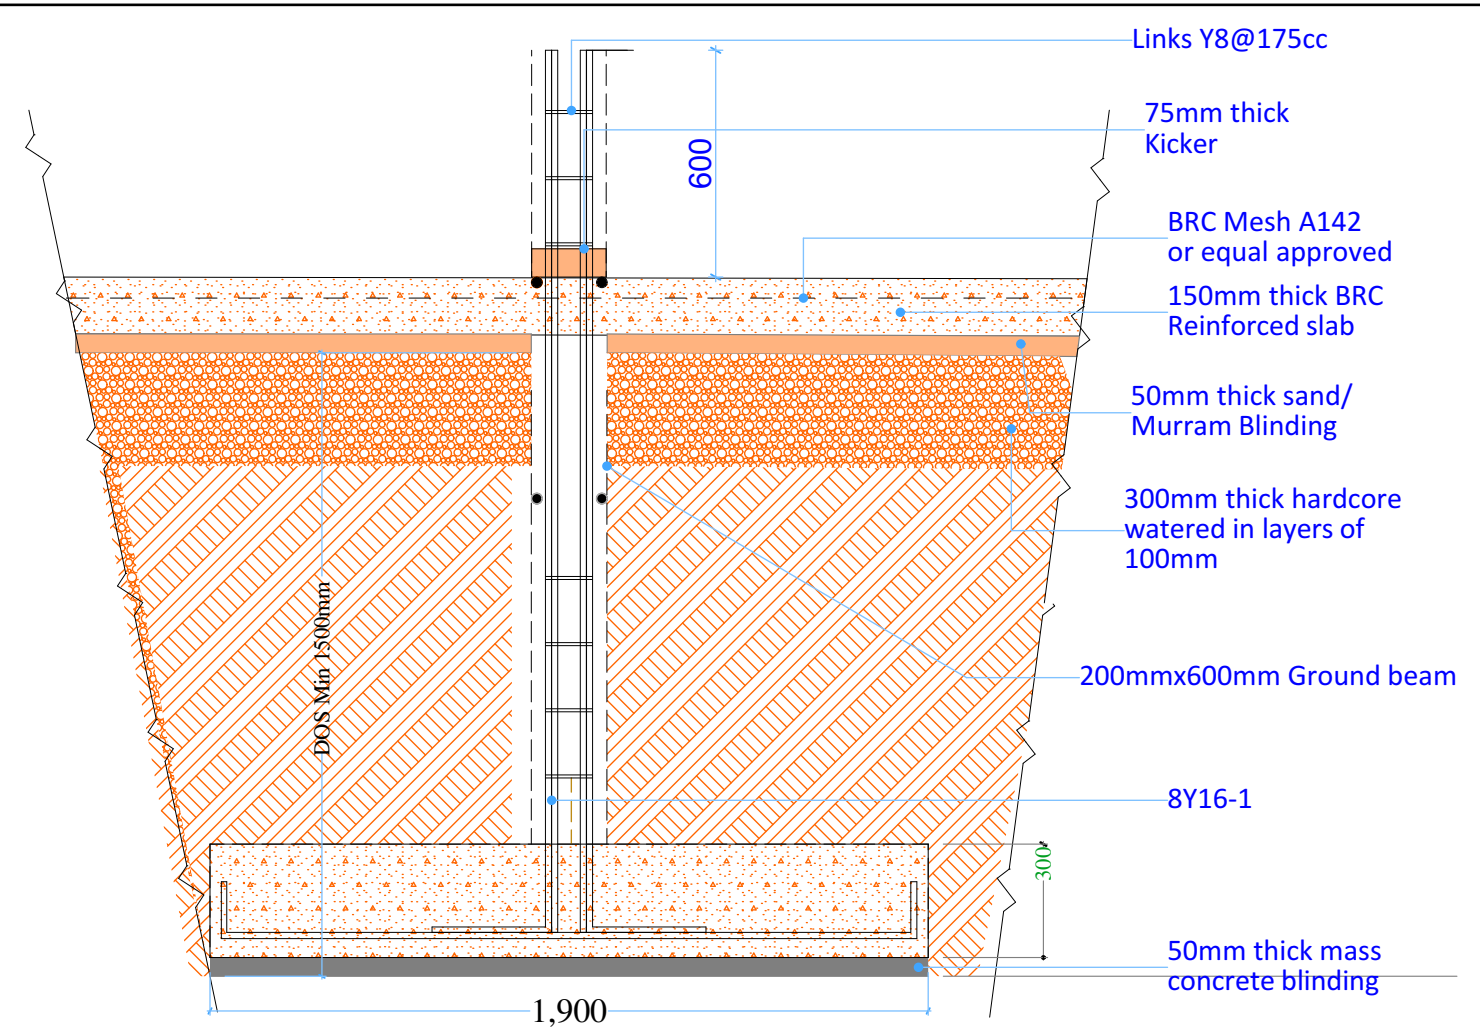

COLUMN BASE C4
(F15,F16)

COLUMN SECTION

PROJECT TITLE:

Dinning, Office, Kitchen and Toilets
At Gahery Teachers Training Institue
Xamar Jajab District,
Banadir Region,Somalia

DONOR:



DRAWING TITLE:

Project No.

Scale:
1:100

Design:
H.E.


Sheet No. 6/24

Date:
Sep 2021




Checked:




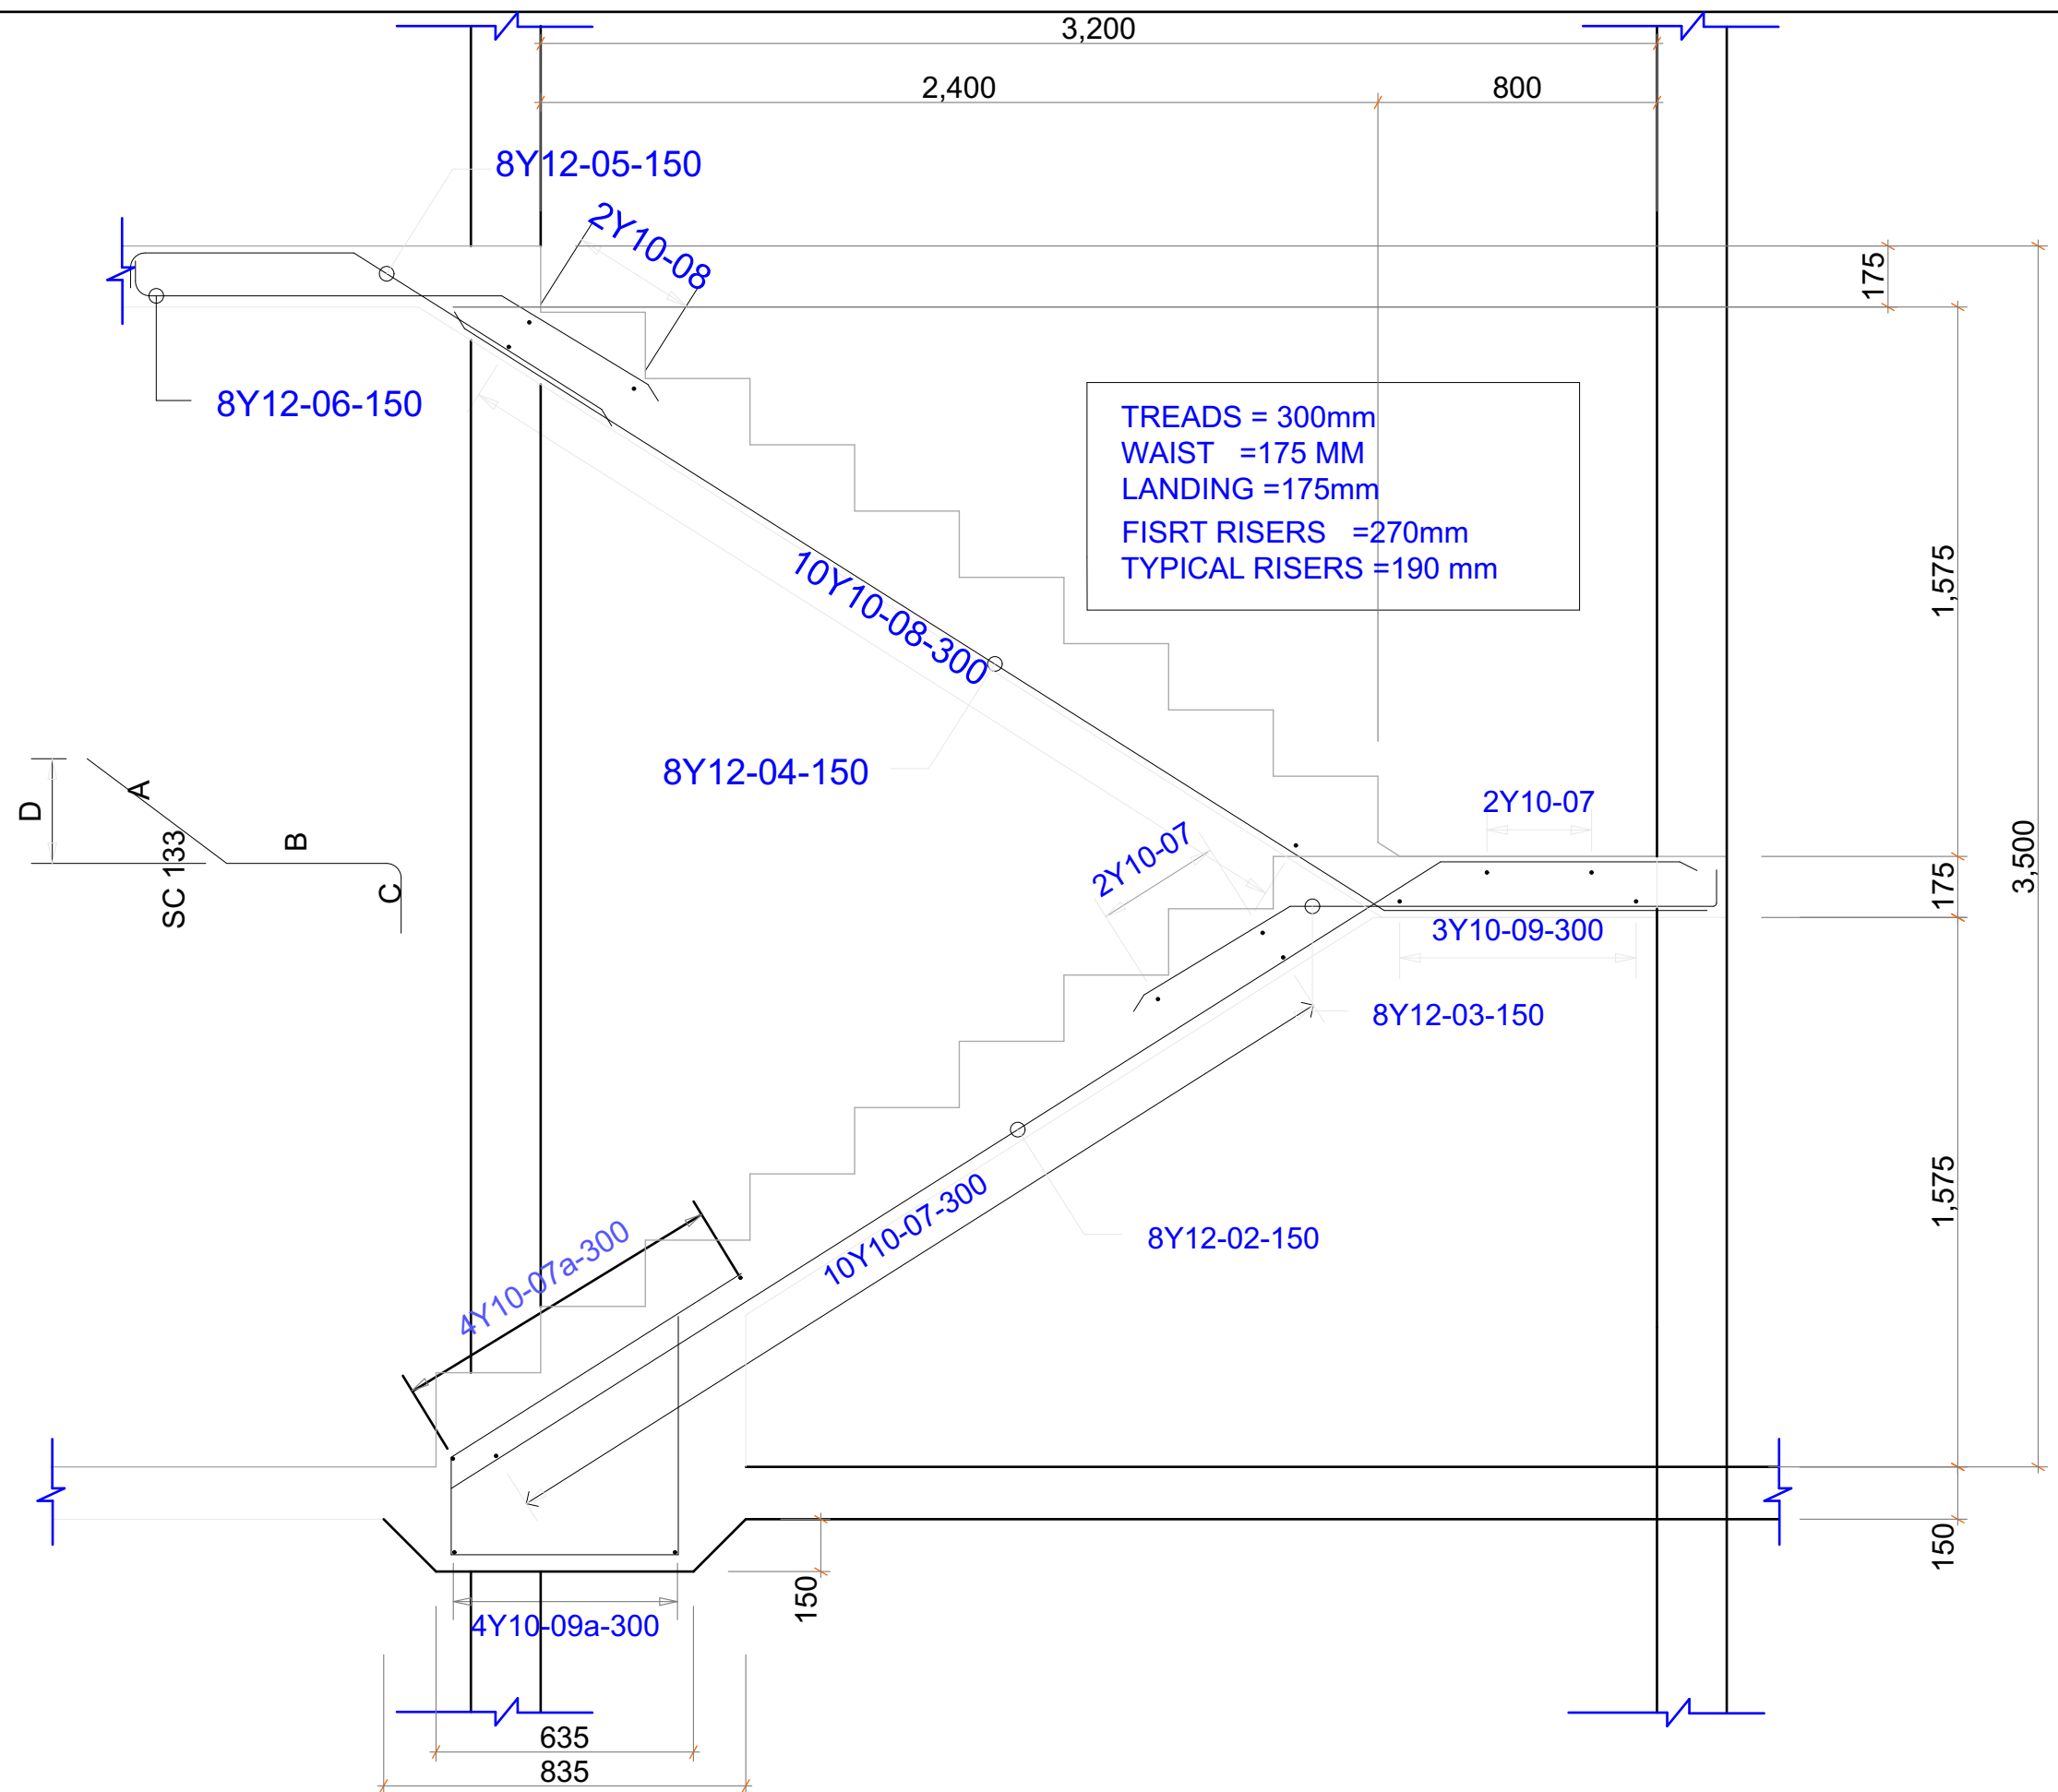

Somalia







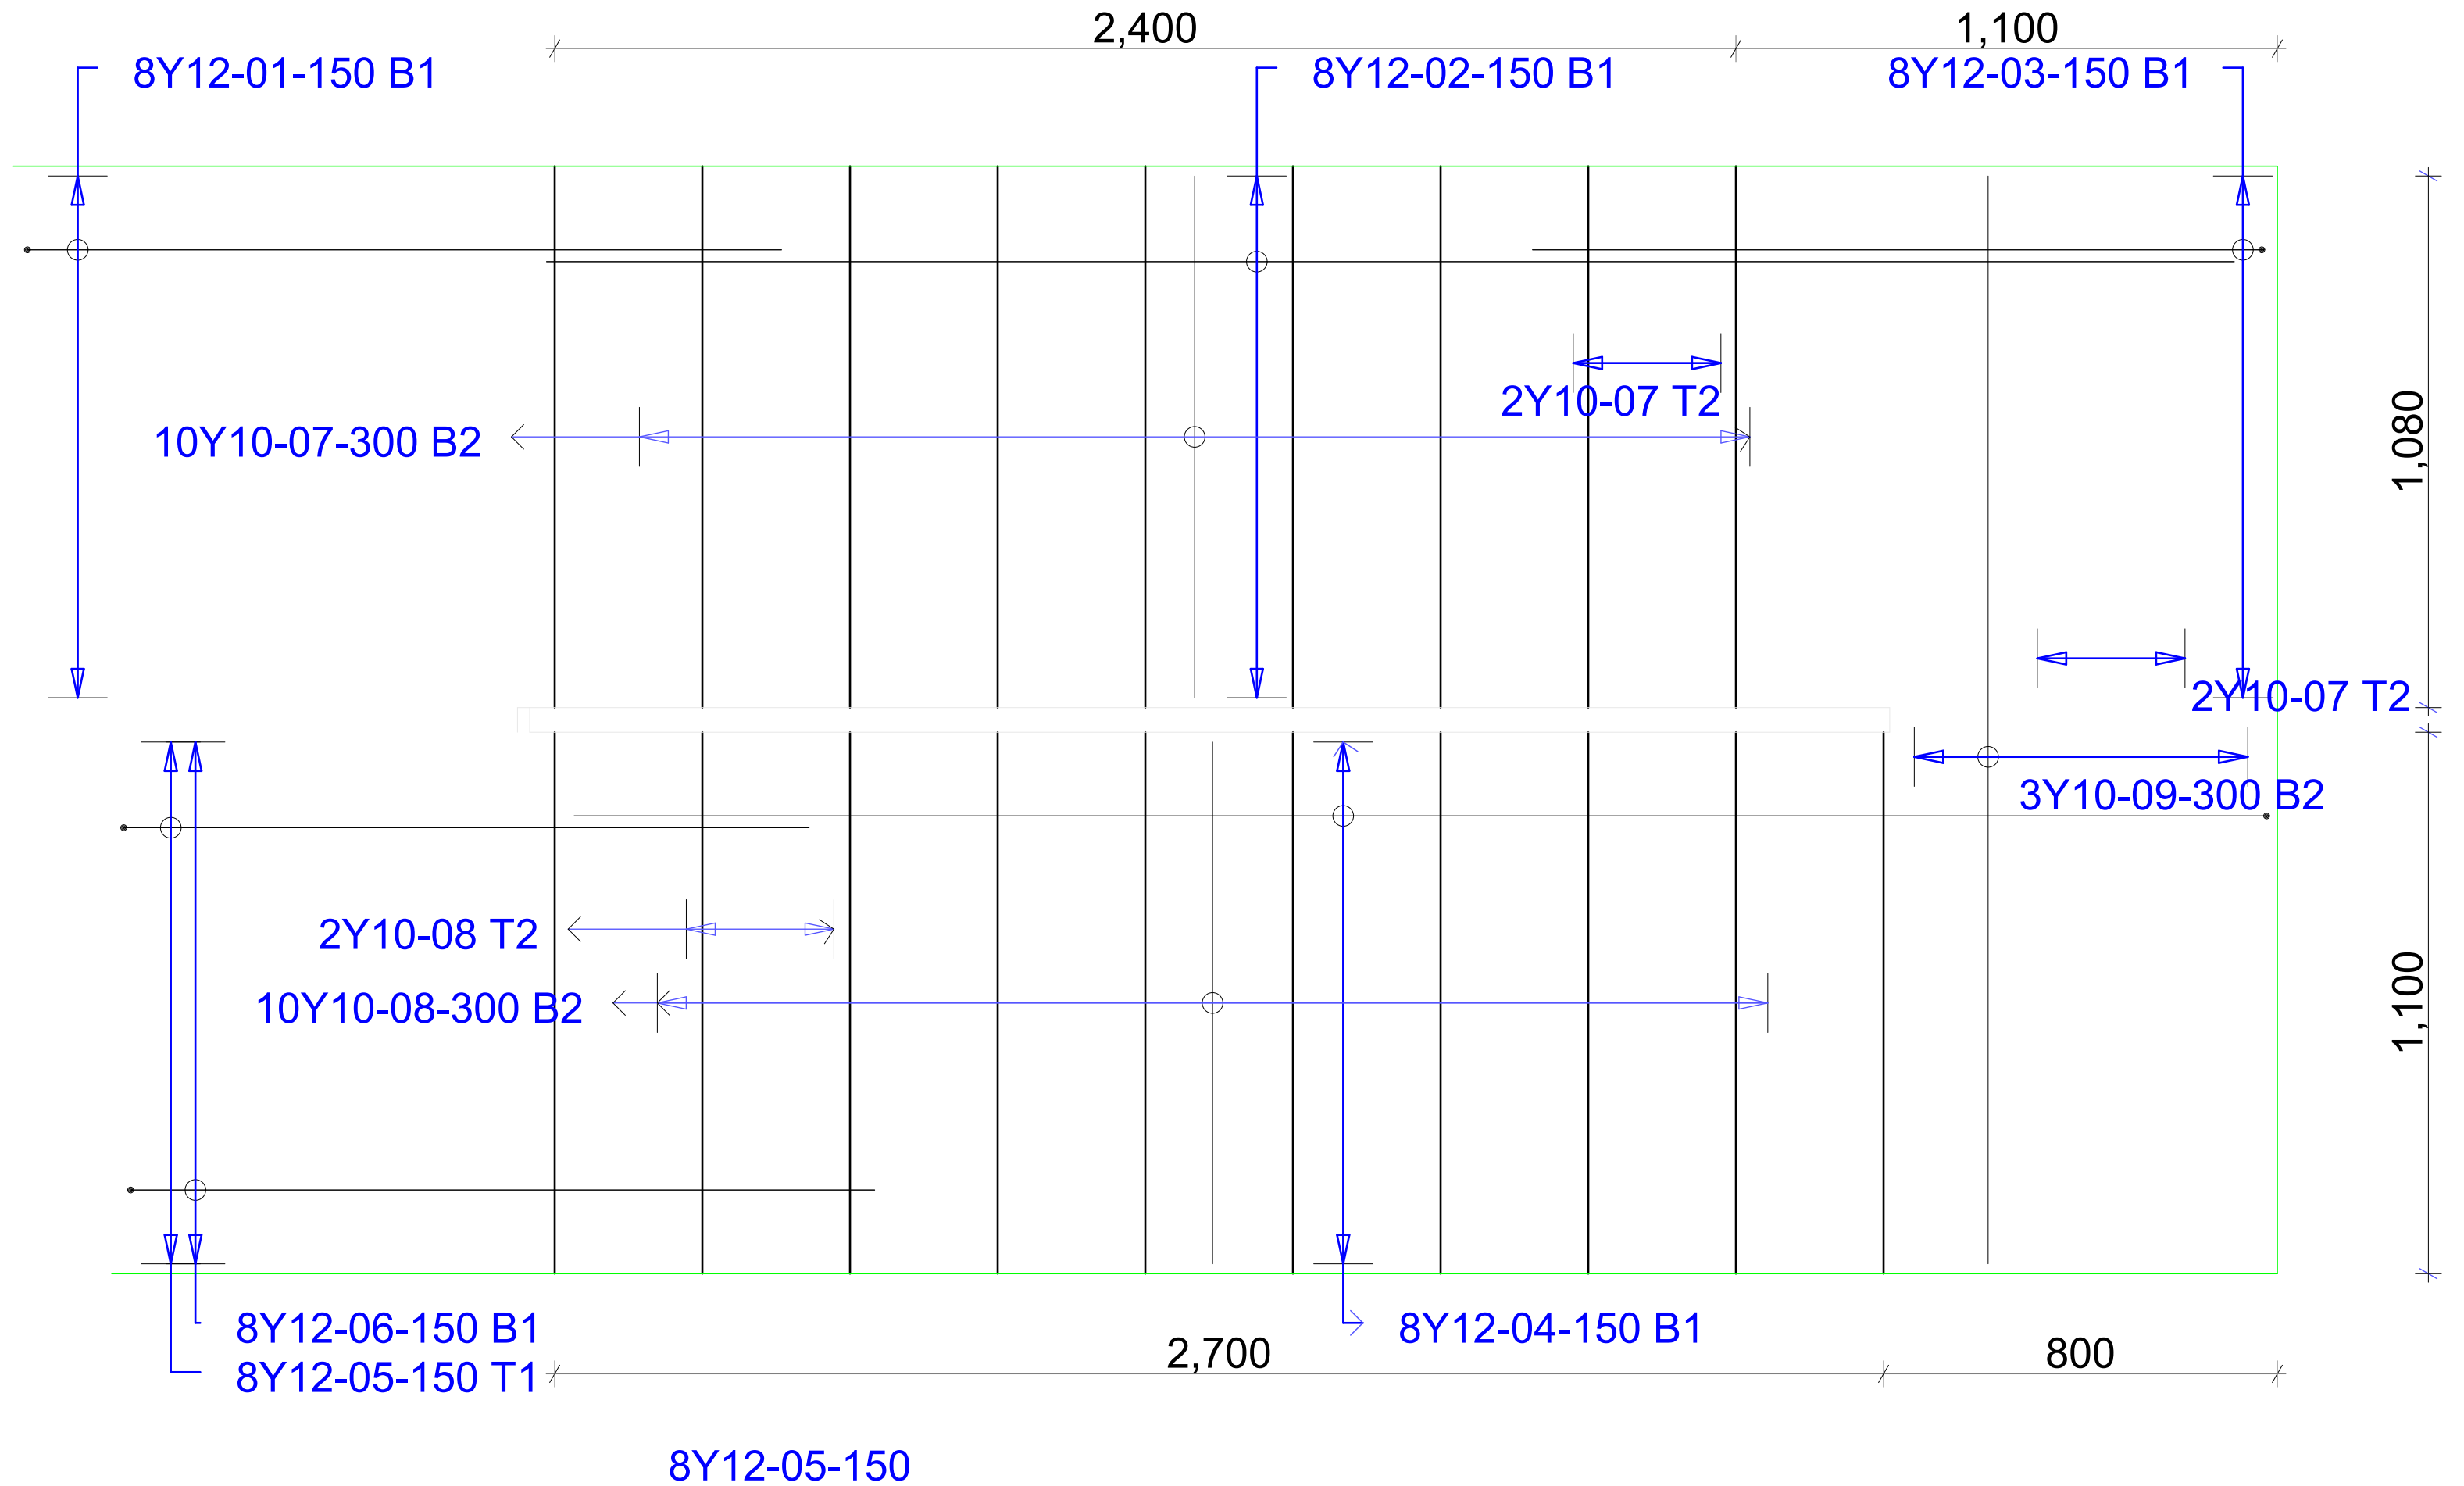


STAIRCASE REINFORCEMENT PLAN AND SECTION DETAILS
SCALE 1:25


PROJECT TITLE:	DONOR:	DRAWING TITLE:	Project No.	Sheet No. 7/24	 ENDING EXTREME POVERTY WHATEVER IT TAKES Somalia
Dinning, Office, Kitchen and Toilets At Gahery Teachers Training Institue Xamar Jajab District, Banadir Region, Somalia	 		Scale: 1:100	Date: Sep 2021	
			Design: H.E.	Checked:	



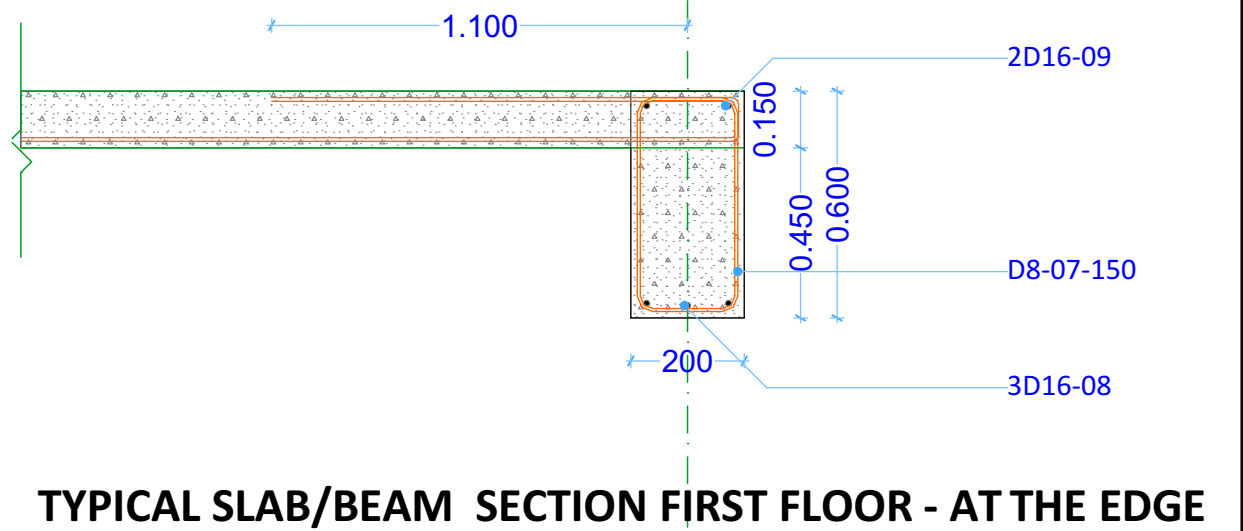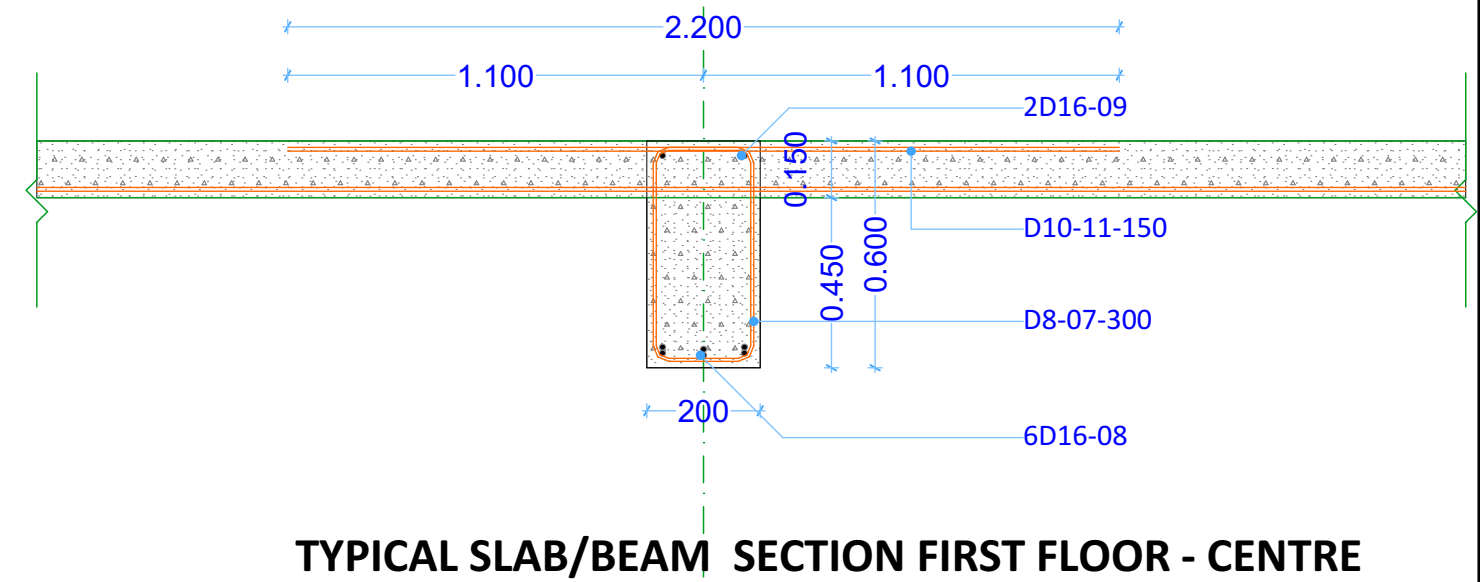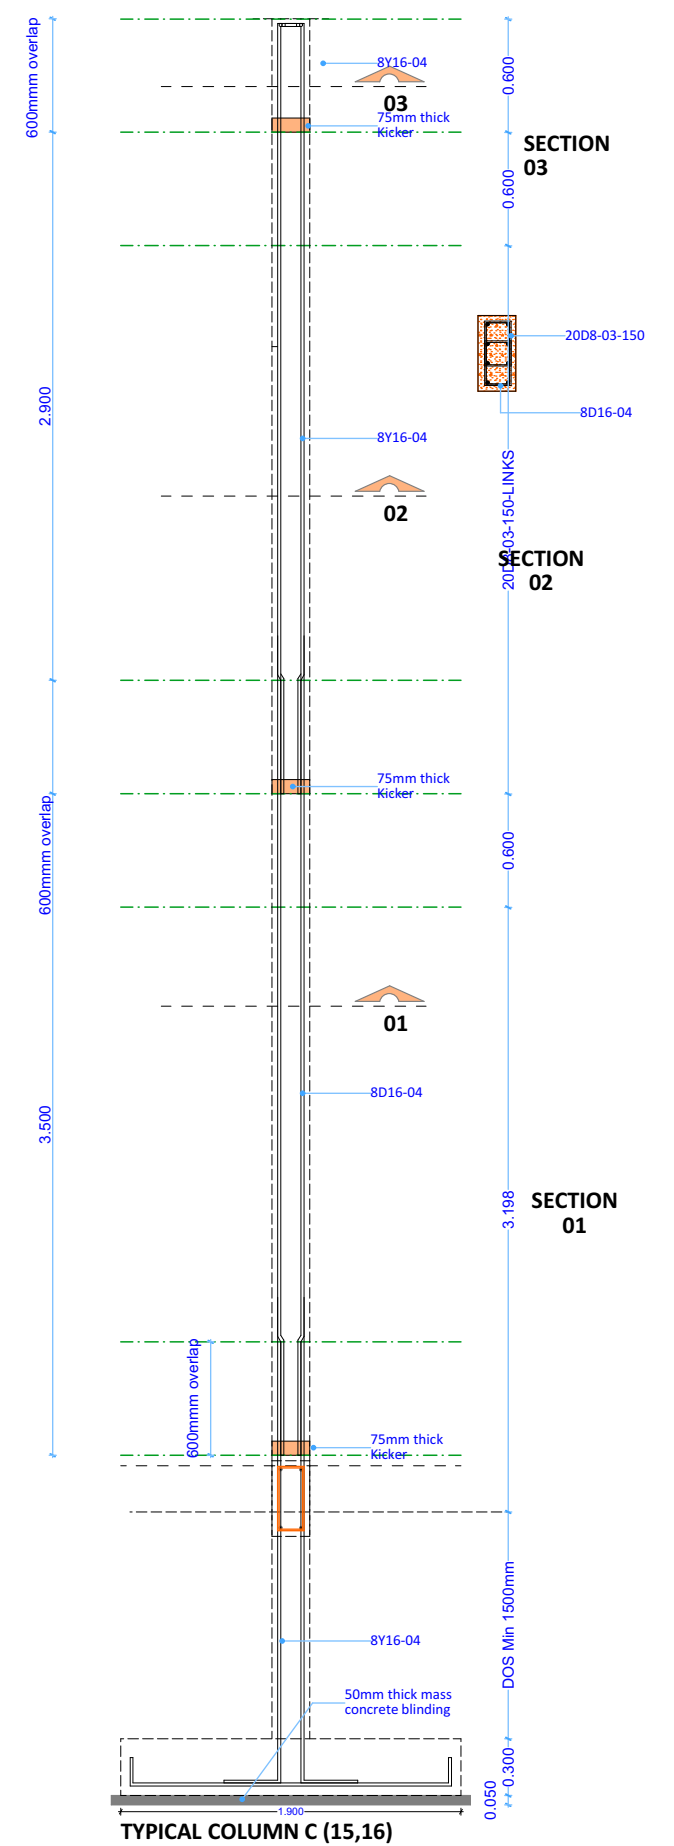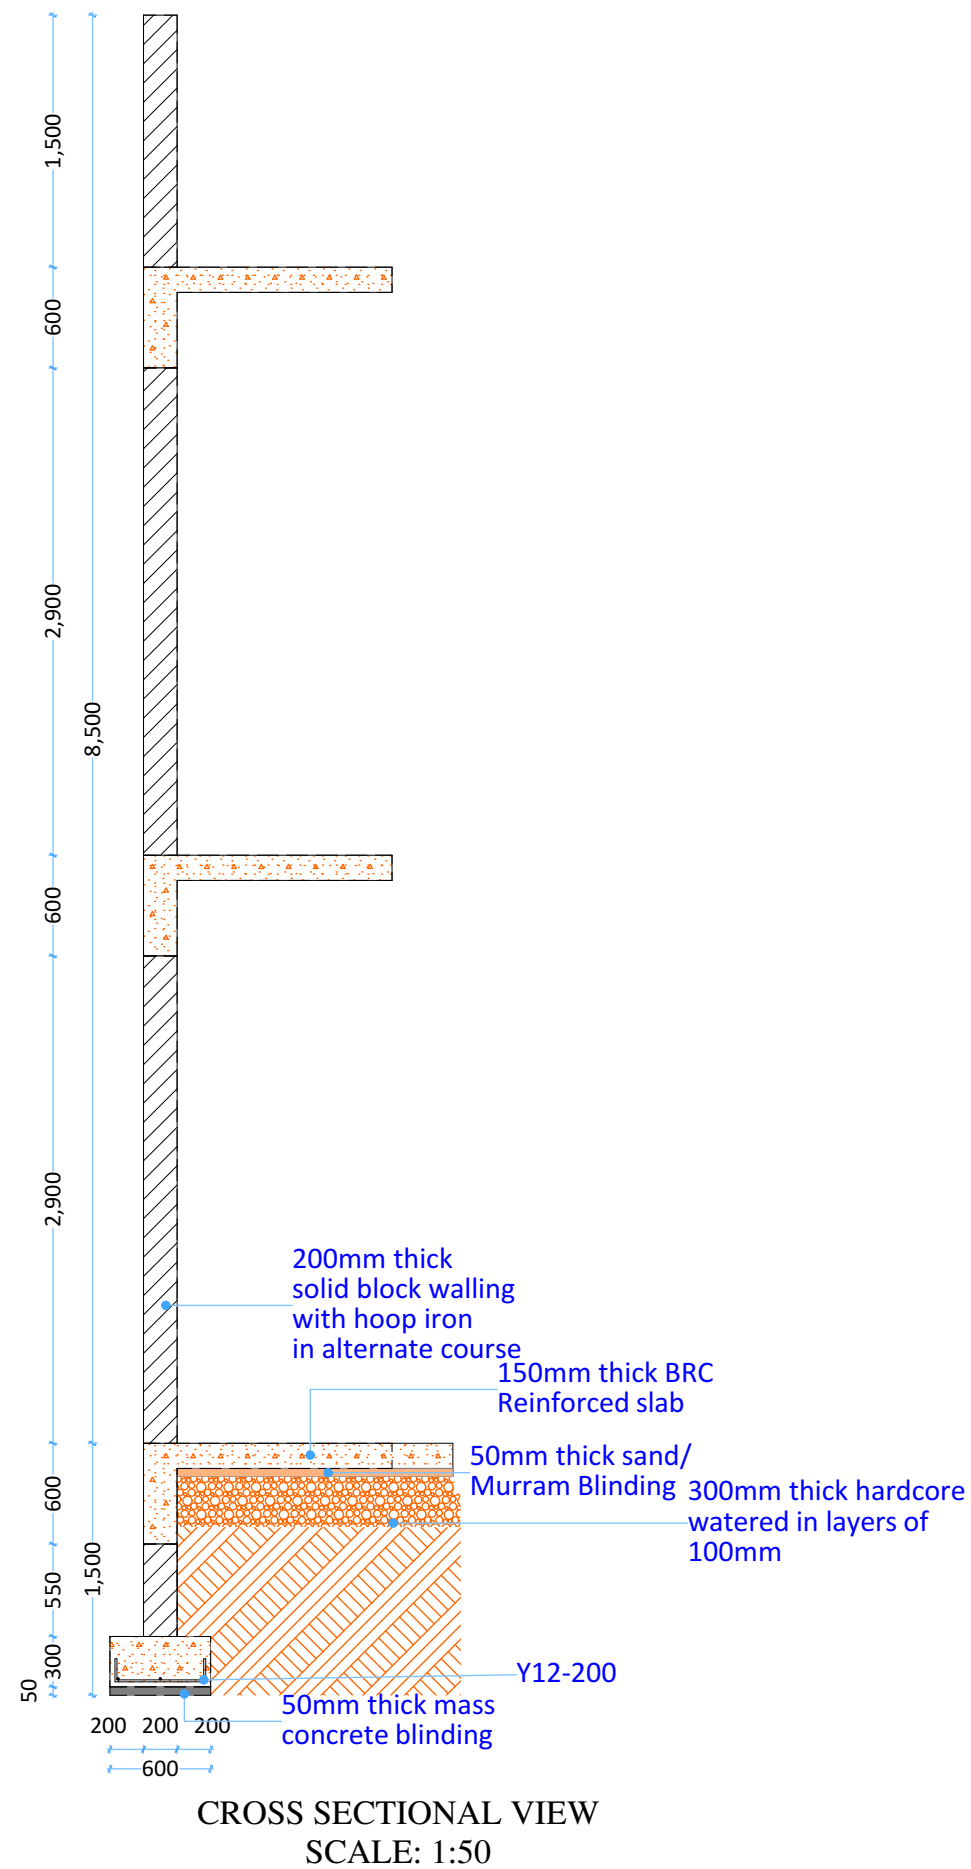

PROJECT TITLE:	DONOR:	DRAWING TITLE:	Project No.	Sheet No. 8/24	<div>CONCERN worldwide</div> <div>ENDING EXTREME POVERTY WHATEVER IT TAKES</div> <div>Somalia</div>
Dinning, Office, Kitchen and Toilets At Gahery Teachers Training Institue Xamar Jajab District, Banadir Region,Somalia	 	Stair case Bar arrangement	Scale: 1:100	Date: Sep 2021	
			Design: H.E.	Checked:	

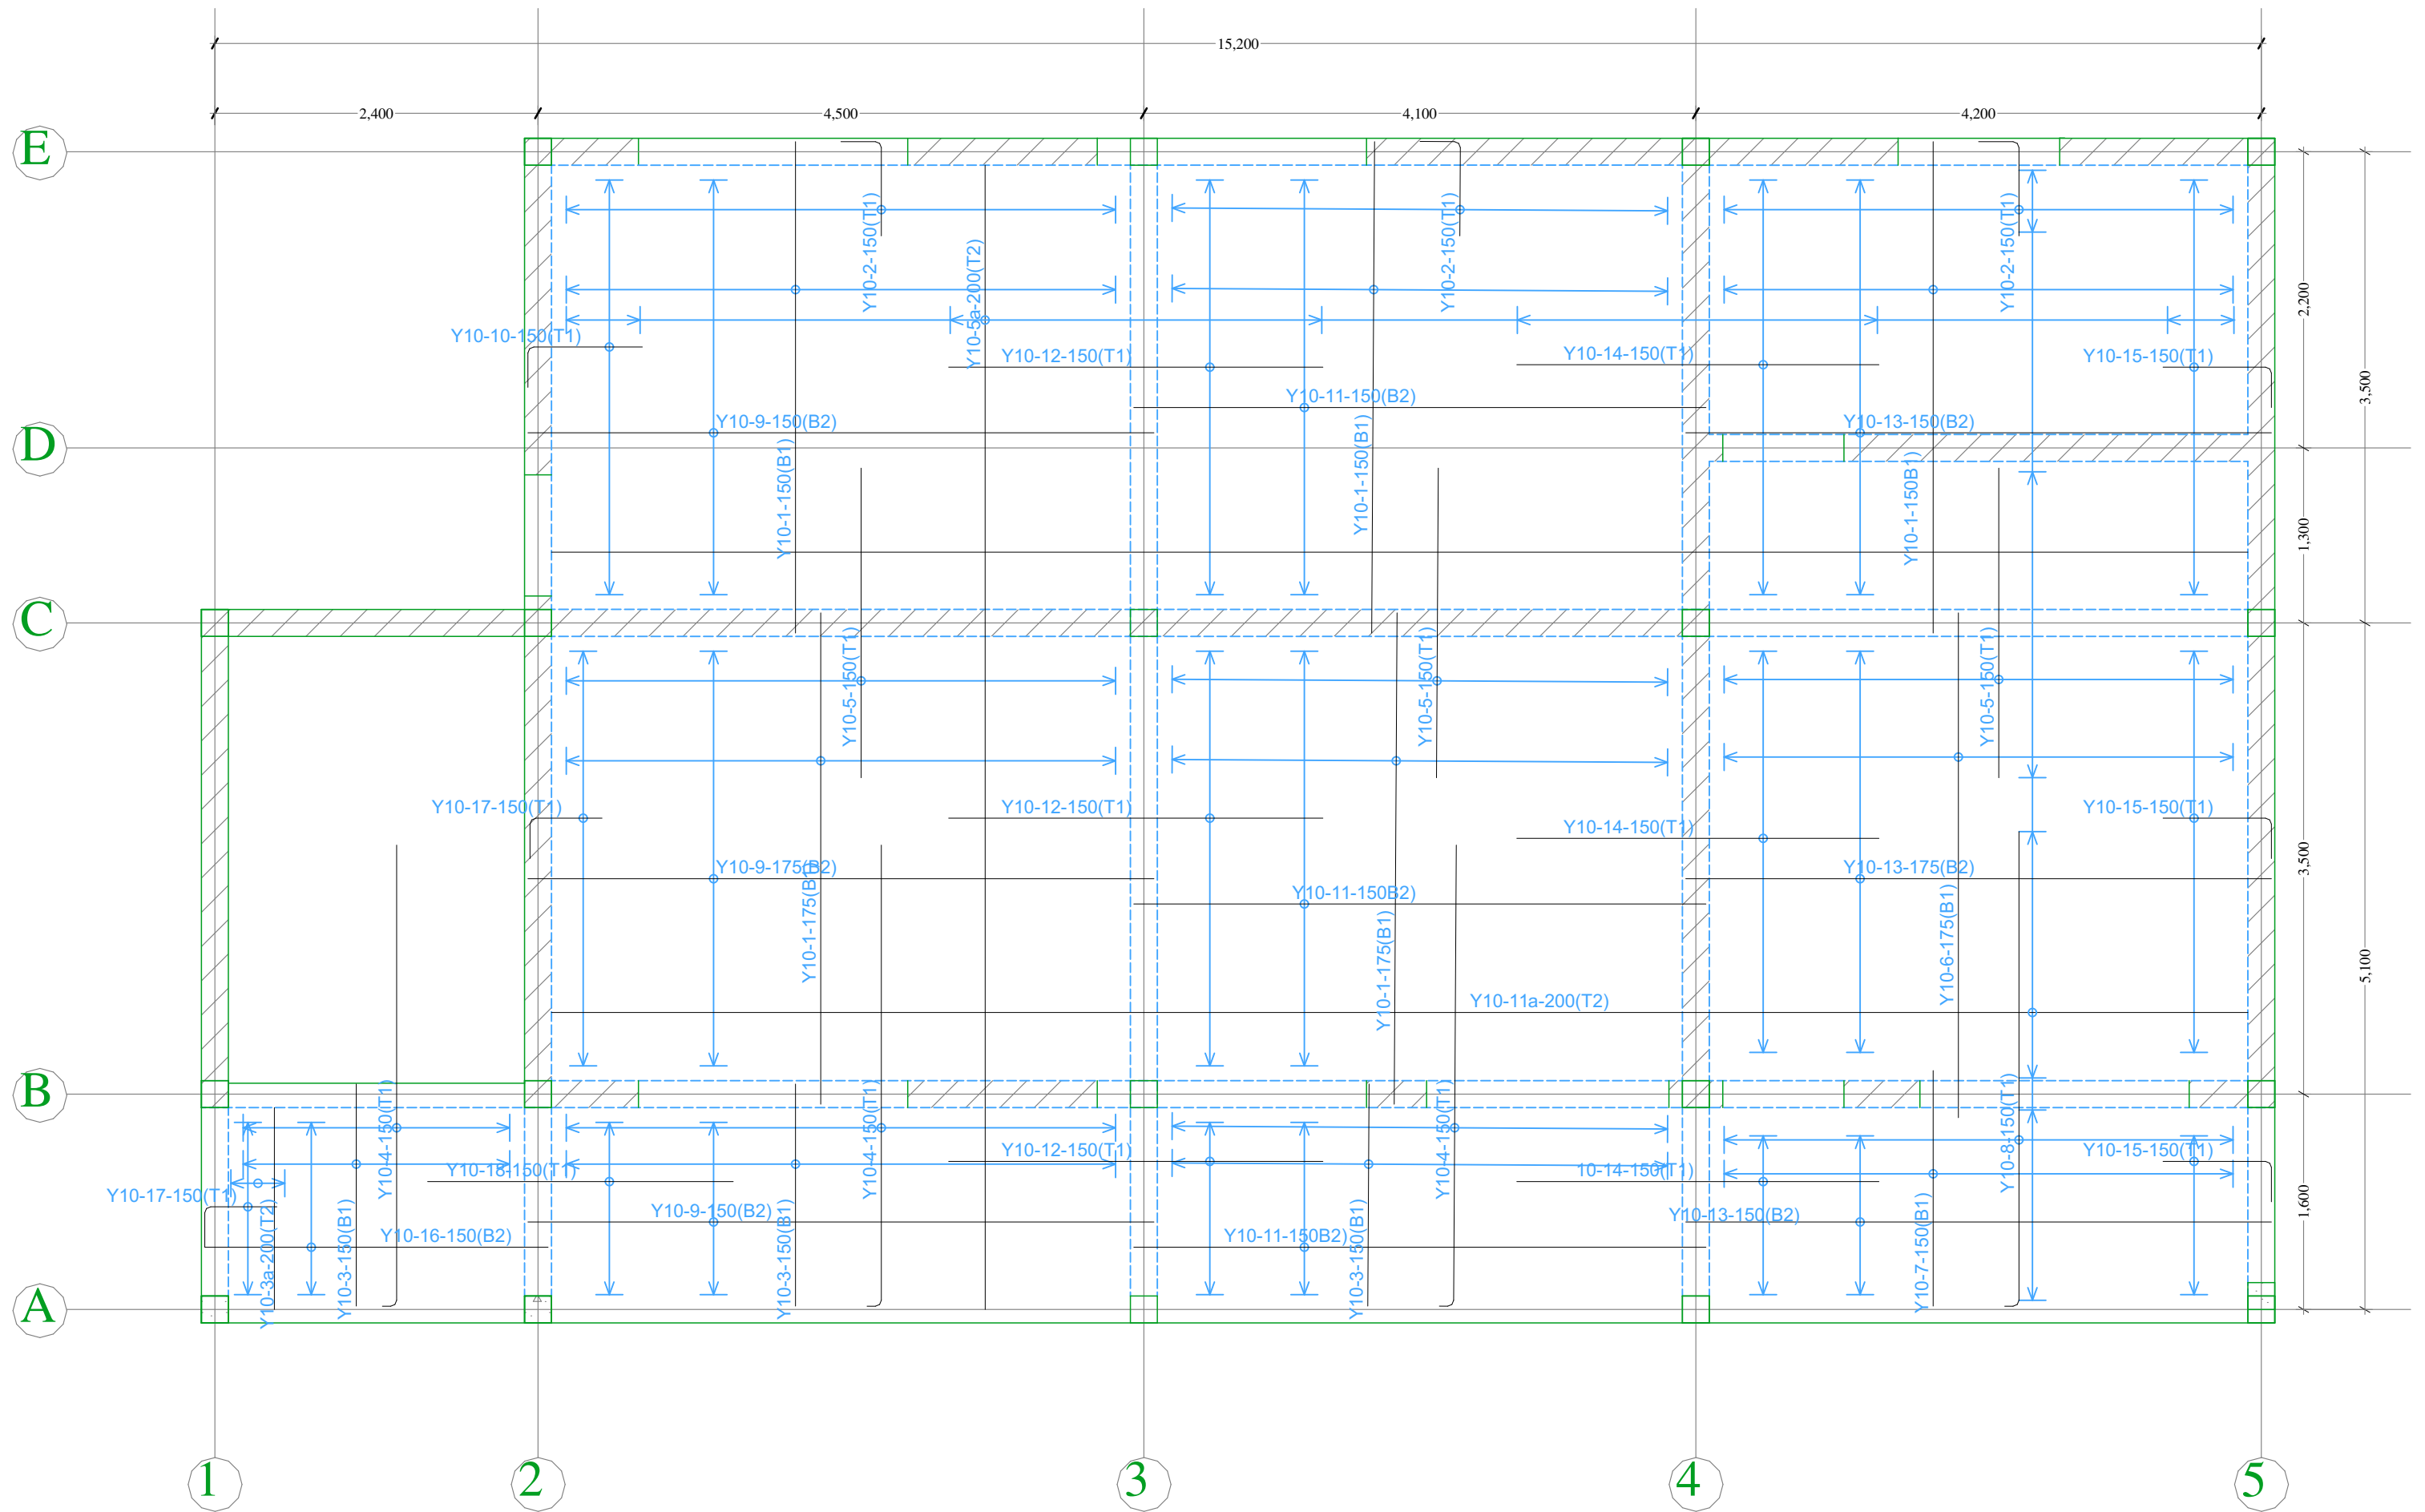


PROJECT TITLE:	DONOR:	DRAWING TITLE:	Project No.	Sheet No. 9/24	 ENDING EXTREME POVERTY WHATEVER IT TAKES Somalia
Dinning, Office, Kitchen and Toilets At Gahery Teachers Training Institue Xamar Jajab District, Banadir Region,Somalia	 		Scale: 1:100	Date: Sep 2021	
			Design: H.E.	Checked:	





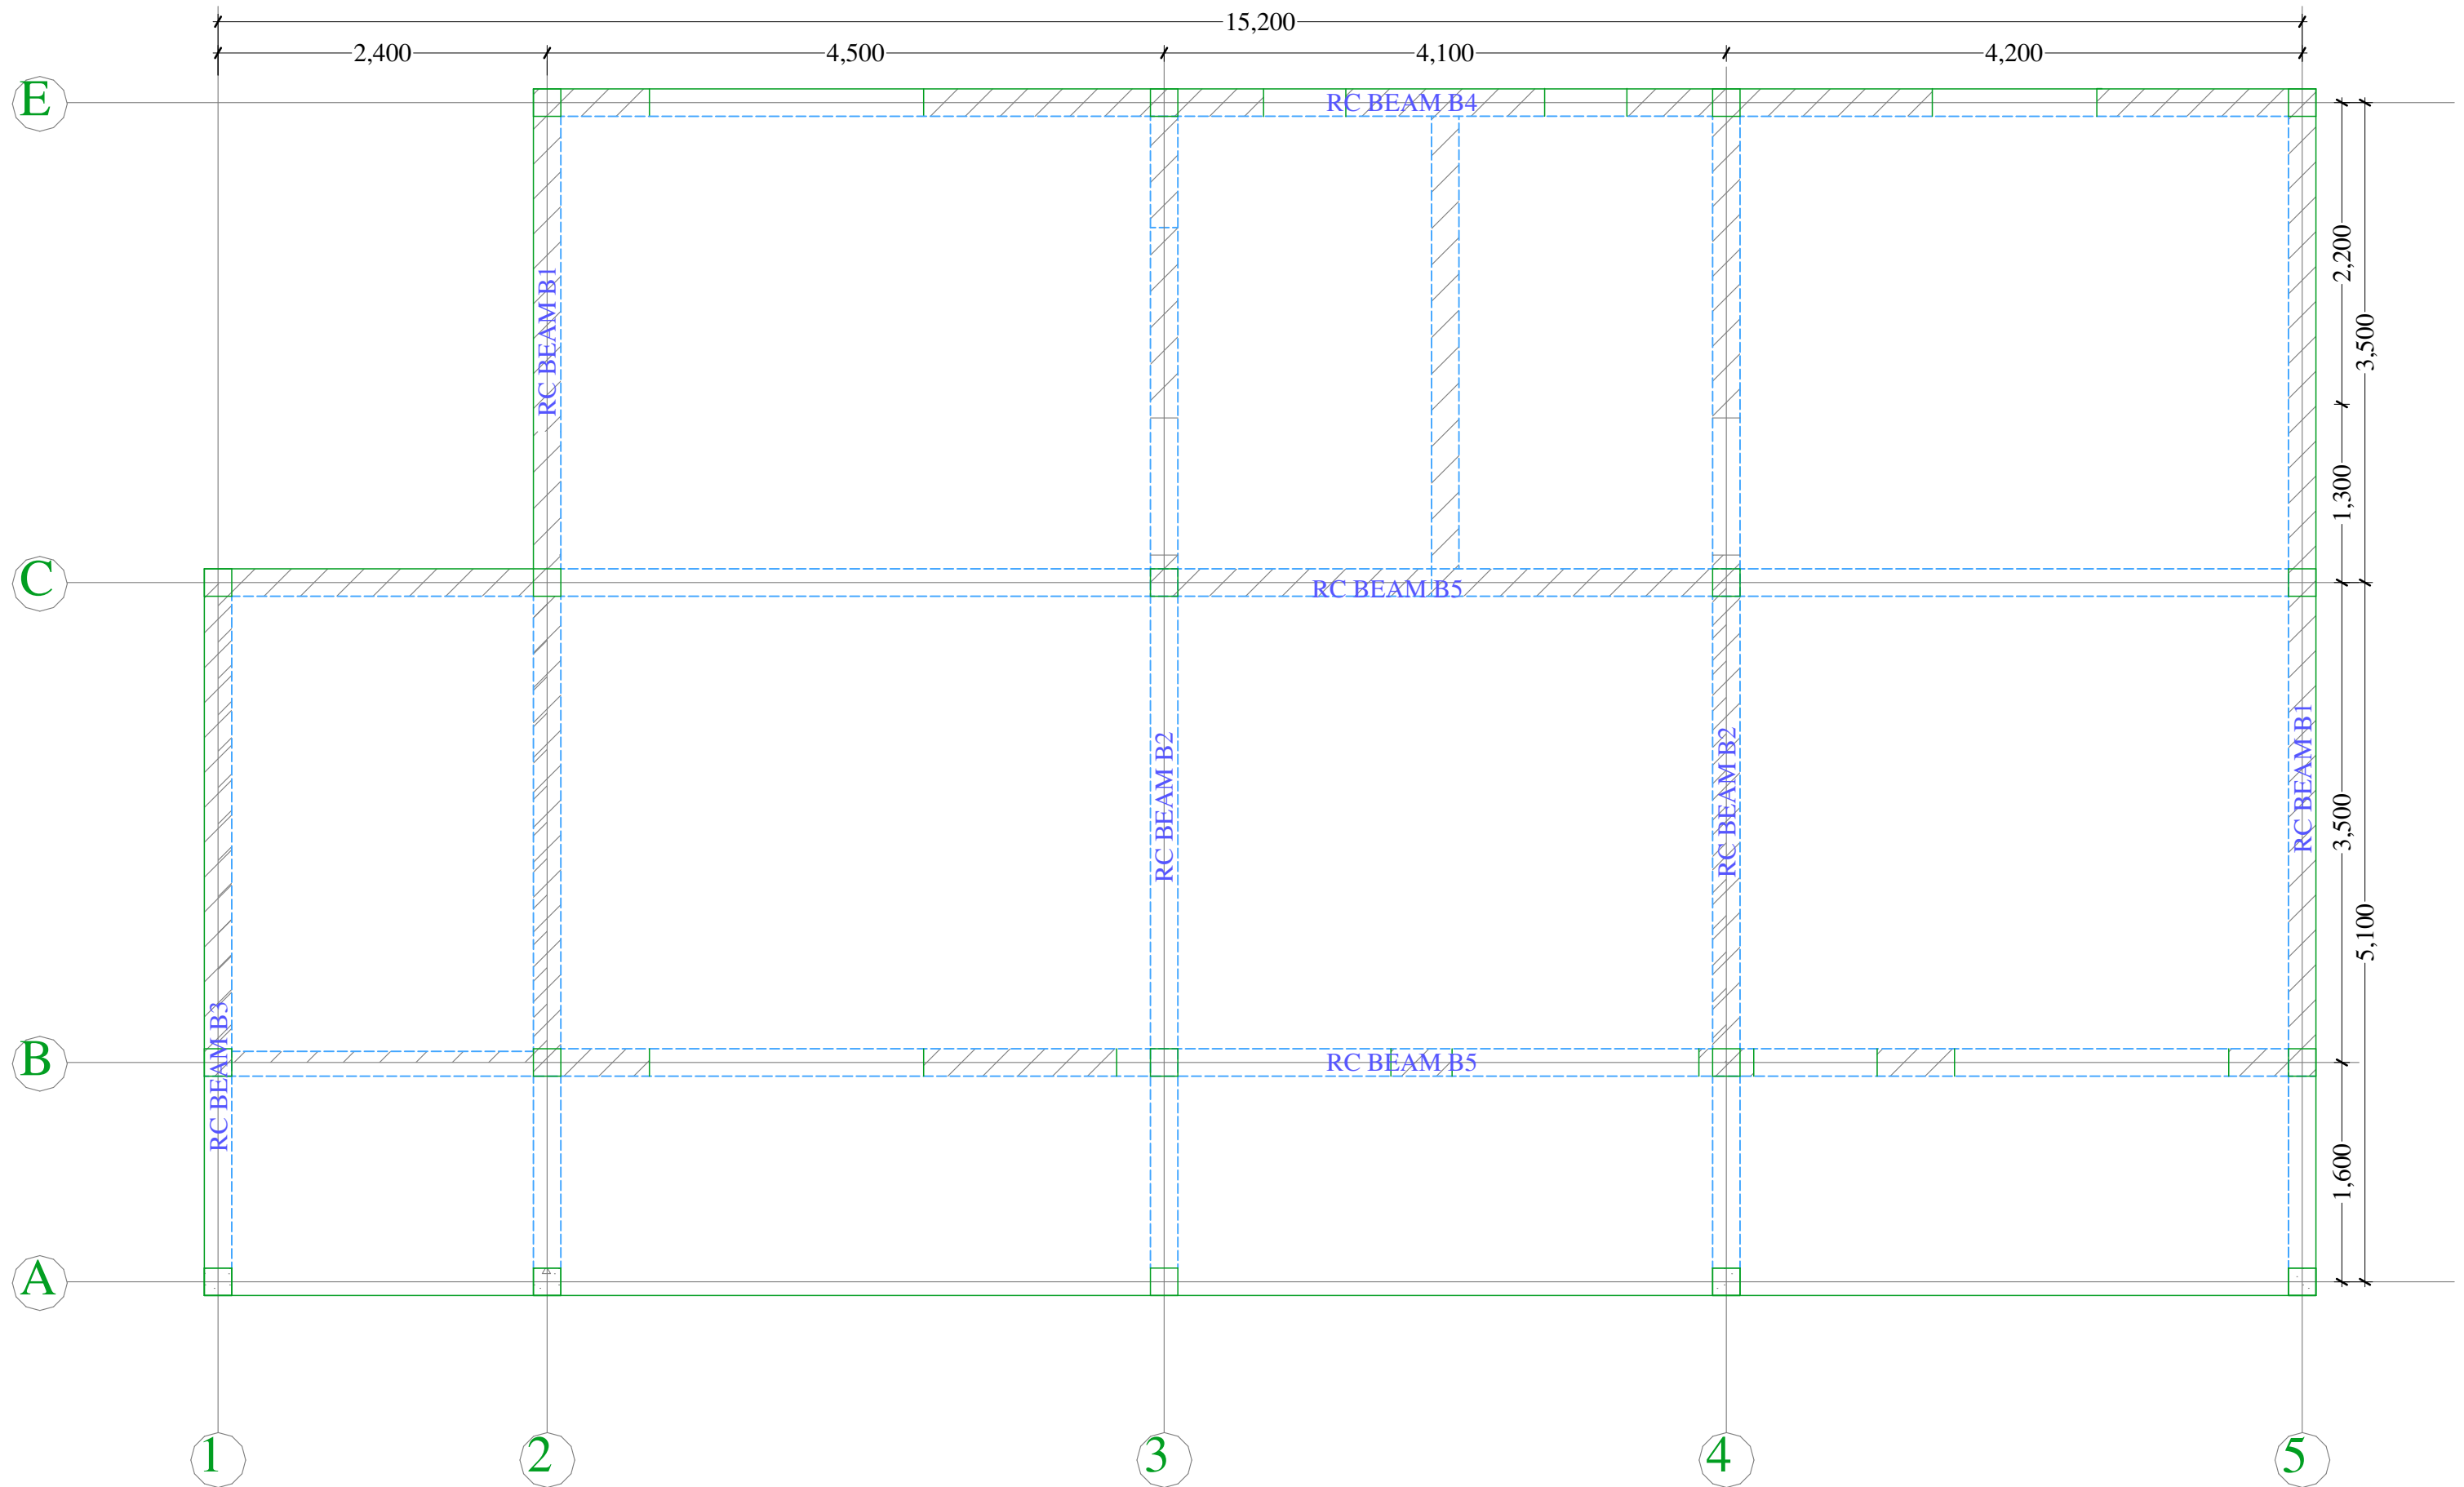



FIRST REINFORCEMENT DETAIL
SCALE 1:50



PROJECT TITLE:	DONOR:	DRAWING TITLE:	Project No.	Sheet No. 10/24	<div><div>CONCERN worldwide</div><div>ENDING EXTREME POVERTY WHATEVER IT TAKES</div><div>Somalia</div></div>
Dinning, Office, Kitchen and Toilets At Gahery Teachers Training Institue Xamar Jajab District, Banadir Region,Somalia	 		Scale: 1:100	Date: Sep 2021	
			Design: H.E.	Checked:	





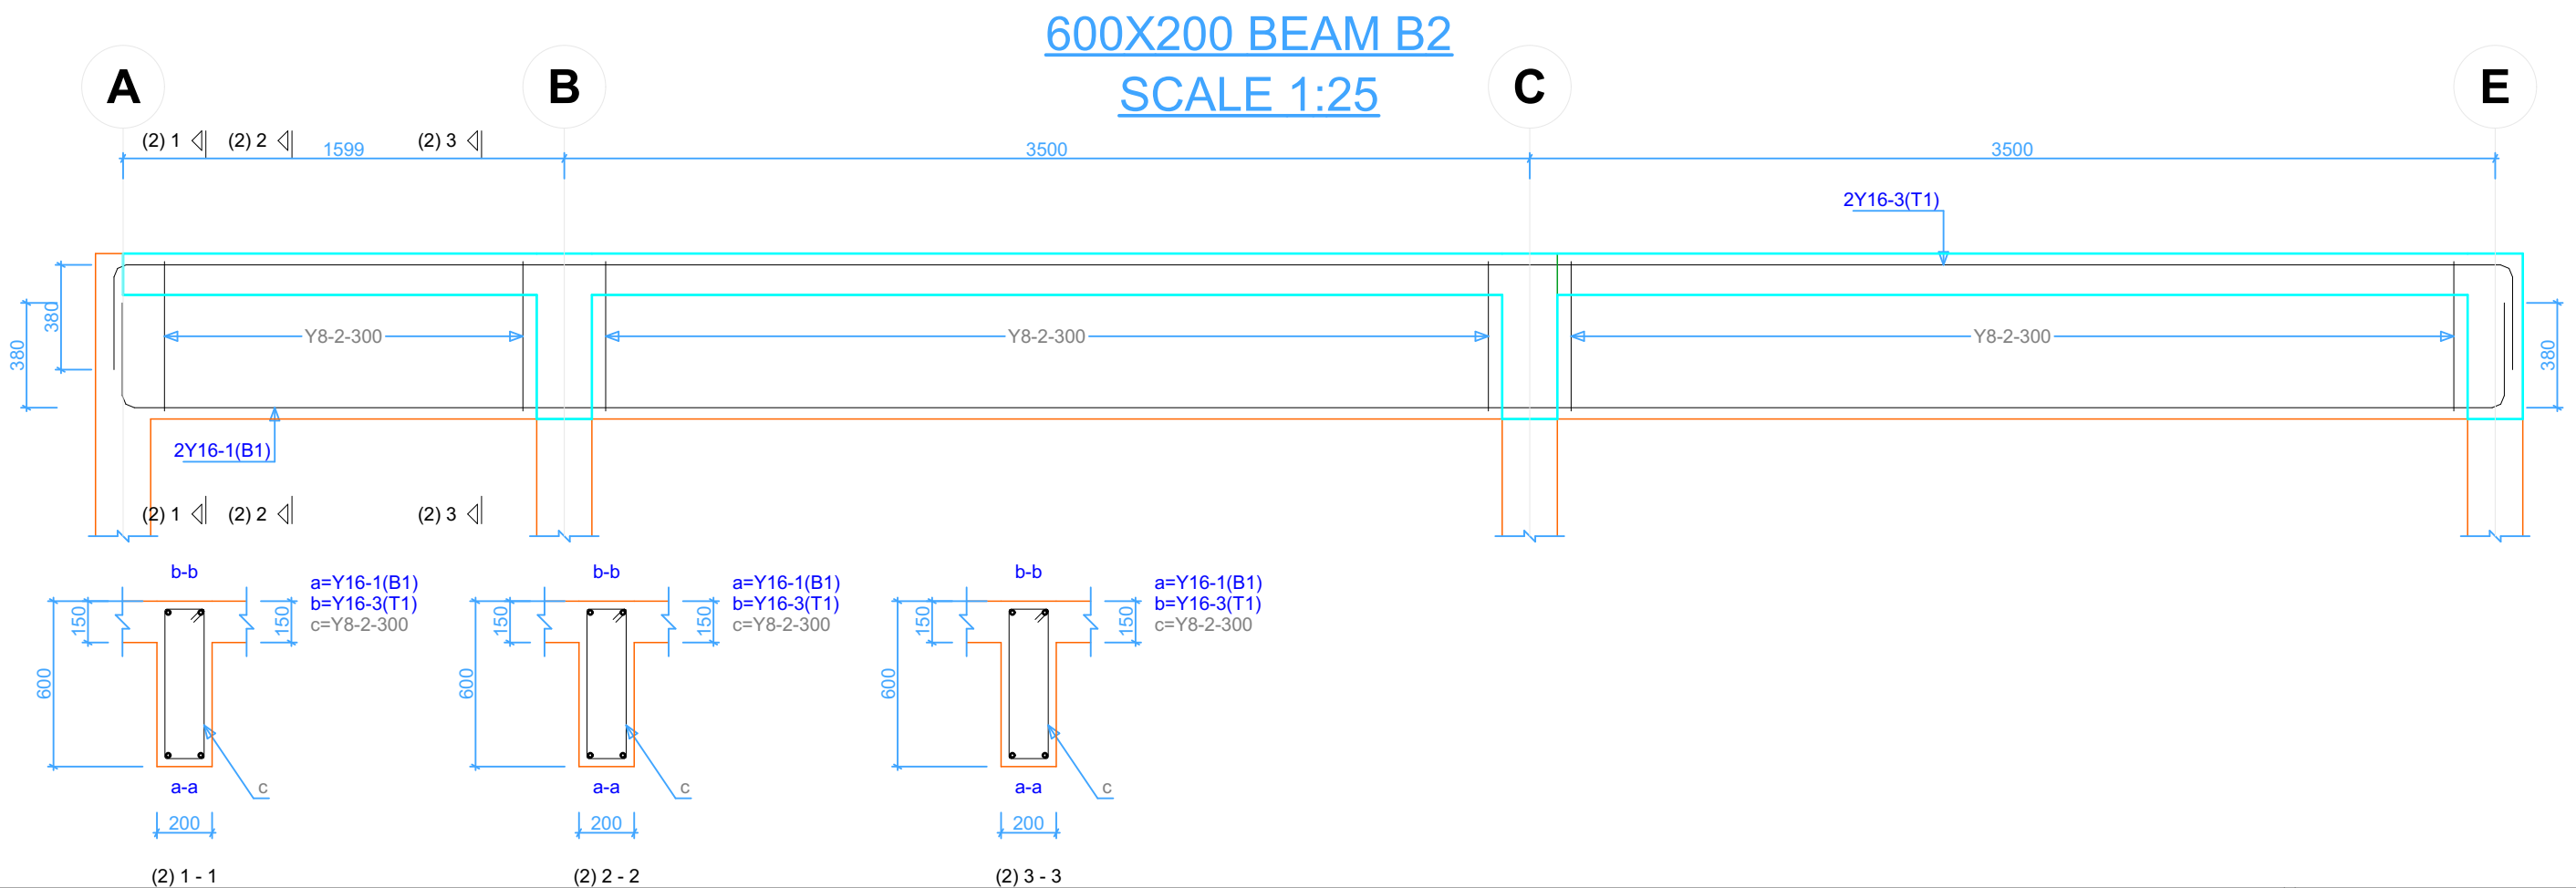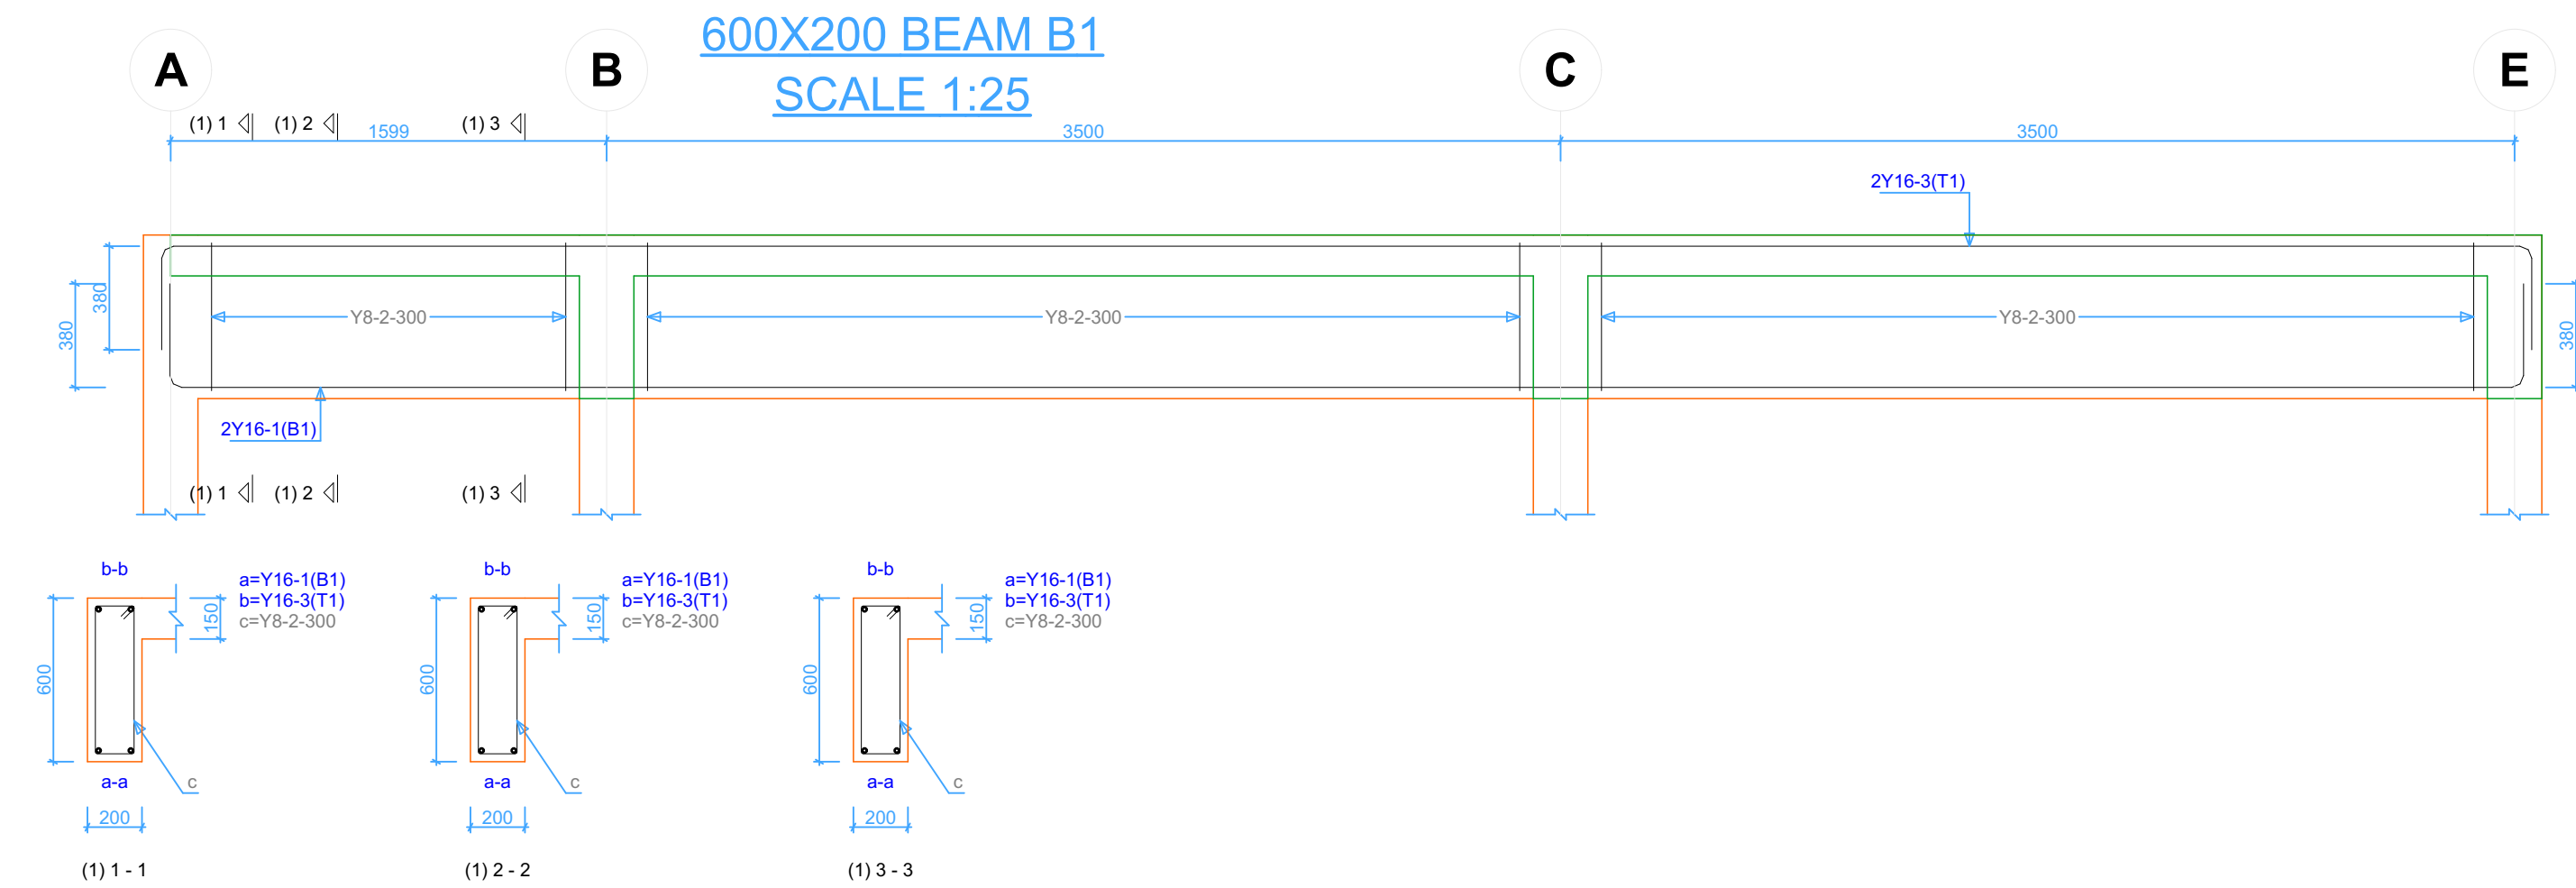

ROOF SLAB PLAN-BAM ARRANGEMENT

PROJECT TITLE:	DONOR:	DRAWING TITLE:	Project No.	Sheet No. 13/24	  Somalia
Dinning, Office, Kitchen and Toilets At Gahery Teachers Training Institue Xamar Jajab District, Banadir Region,Somalia	 		Scale: 1:100	Date: Sep 2021	
			Design: H.E.	Checked:	

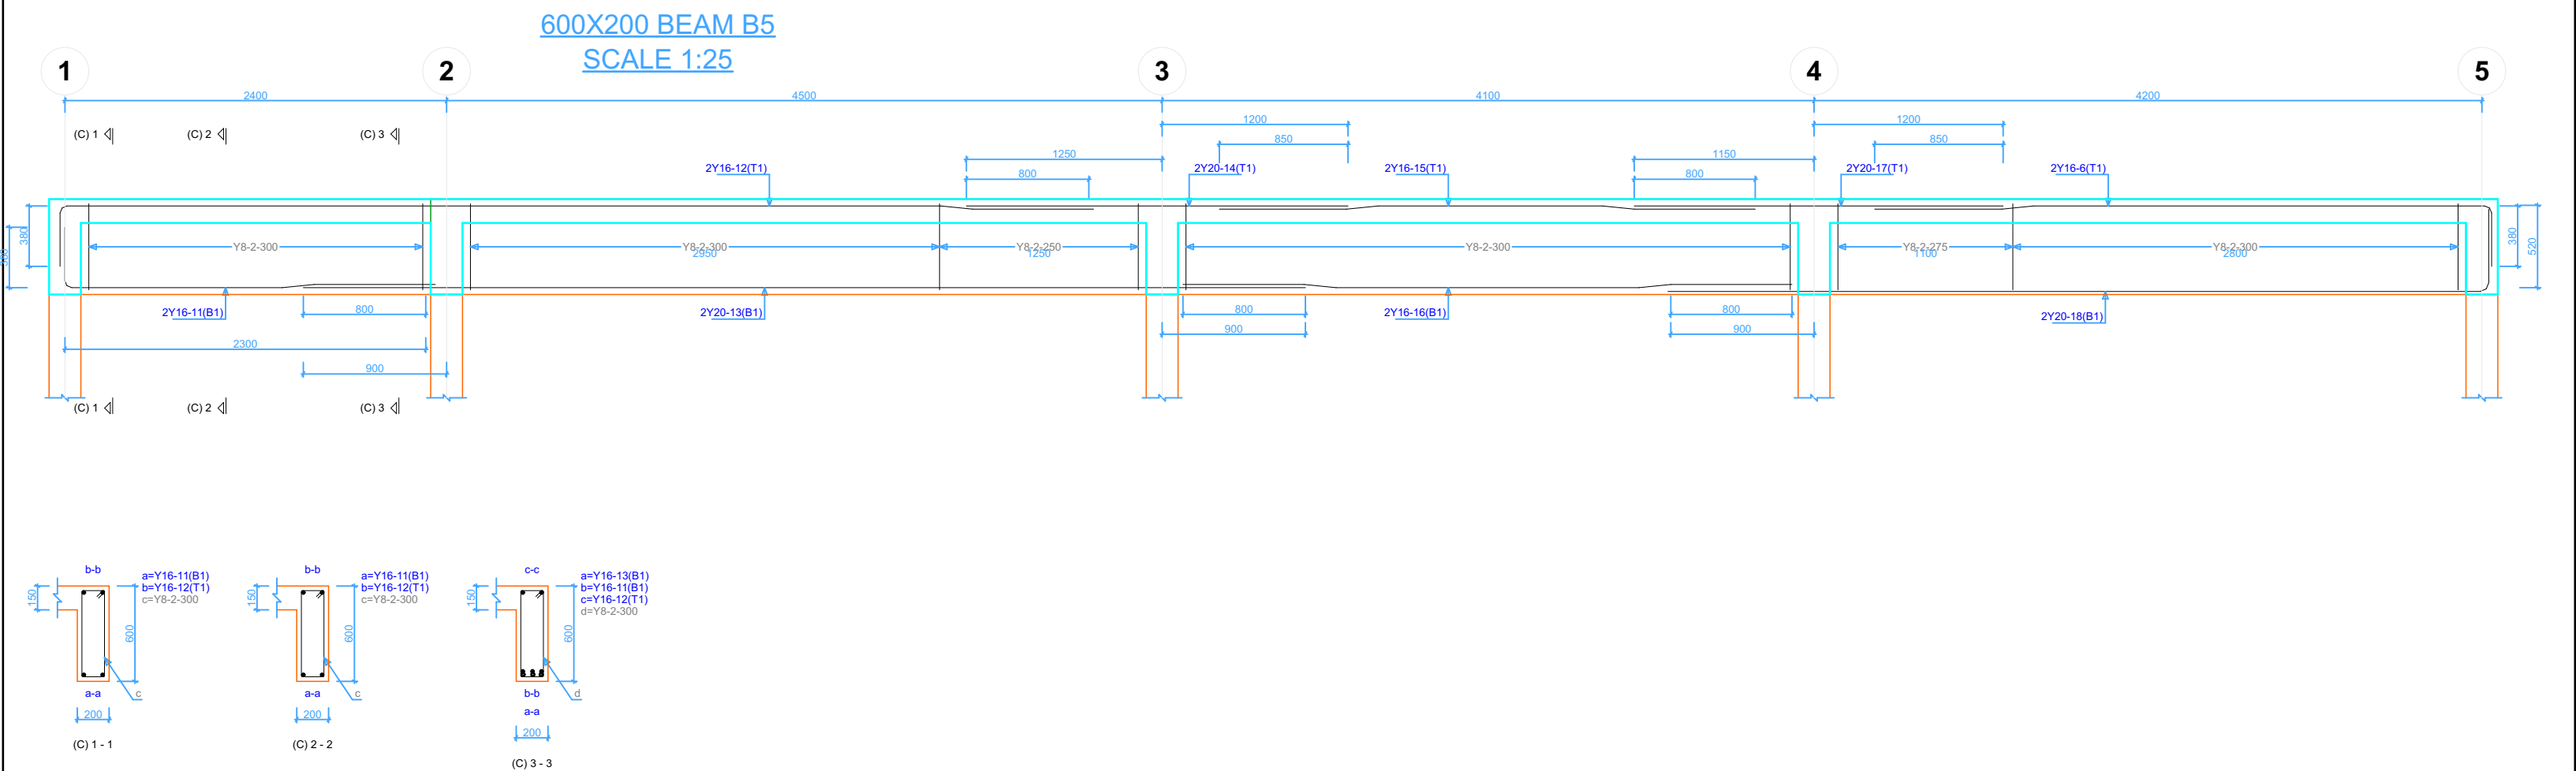
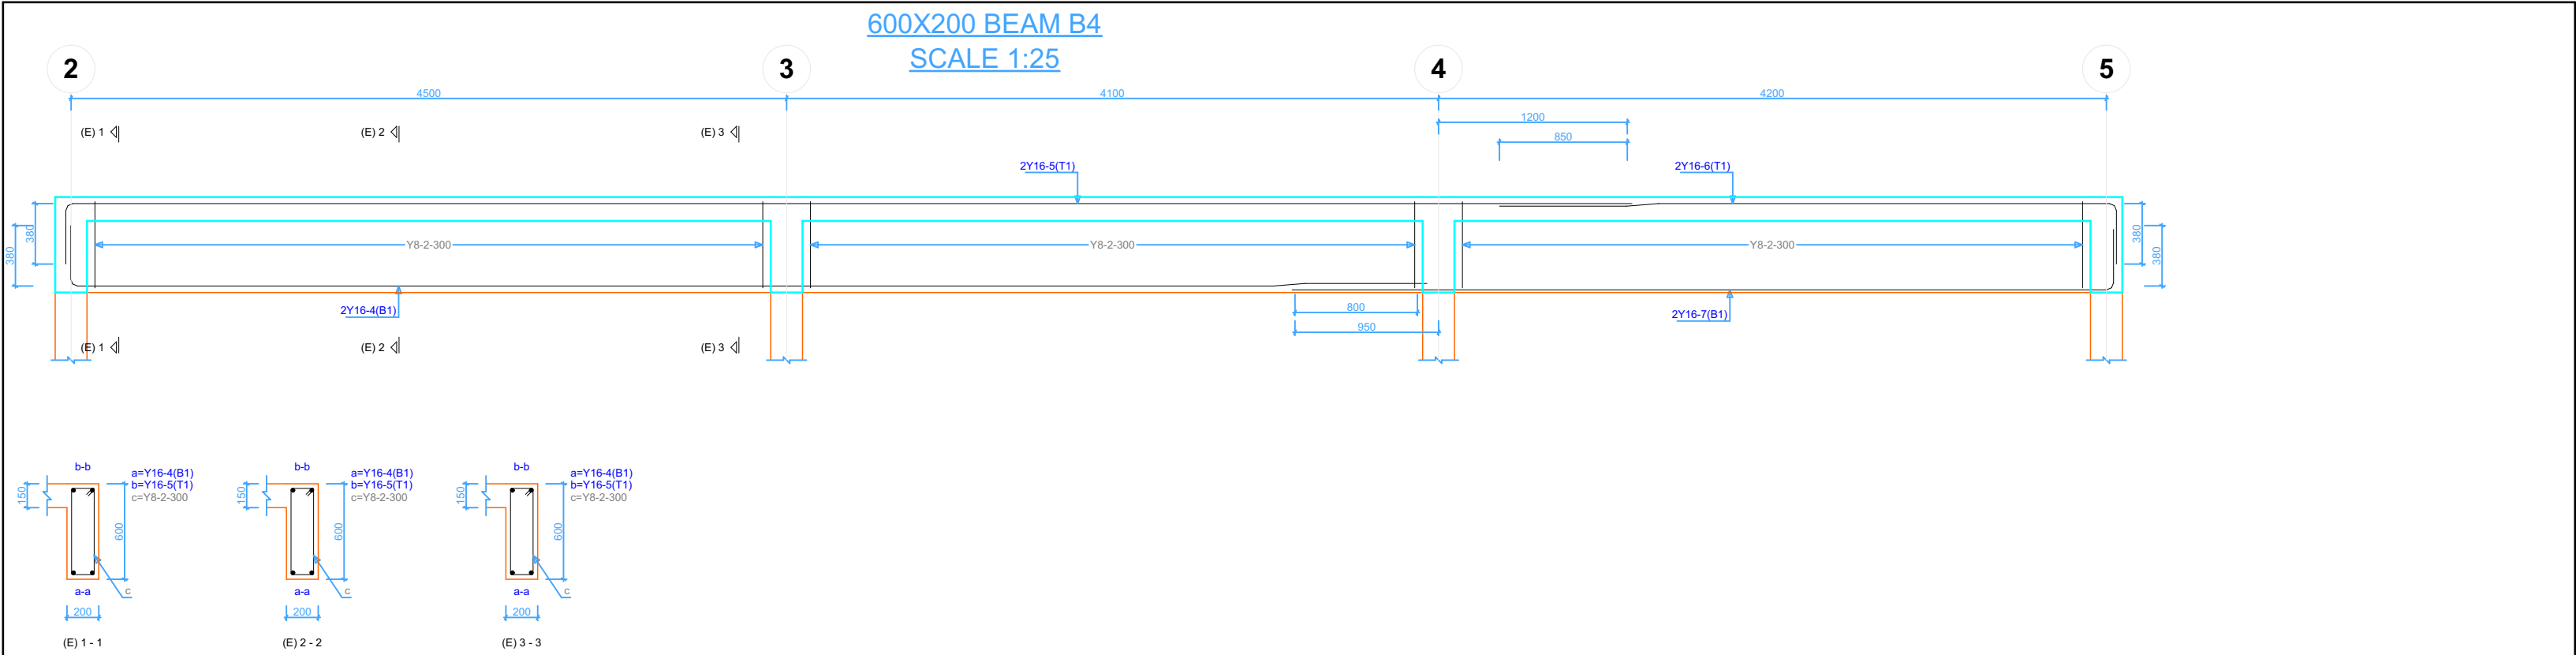


PROJECT TITLE:	DONOR:	DRAWING TITLE:	Project No.	Sheet No. 14/24	<div>CONCERN worldwide</div> <div>ENDING EXTREME POVERTY WHATEVER IT TAKES</div> <div>Somalia</div>
Dinning, Office, Kitchen and Toilets At Gahery Teachers Training Institue Xamar Jajab District, Banadir Region,Somalia	 		Scale: 1:100	Date: Sep 2021	
			Design: H.E.	Checked:	




PROJECT TITLE:	DONOR:	DRAWING TITLE:	Project No.	Sheet No. 15/24	<div>CONCERN worldwide</div> <div>ENDING EXTREME POVERTY WHATEVER IT TAKES</div> <div>Somalia</div>
Dinning, Office, Kitchen and Toilets At Gahery Teachers Training Institue Xamar Jajab District, Banadir Region,Somalia	 		Scale: 1:100	Date: Sep 2021	
			Design: H.E.	Checked:	

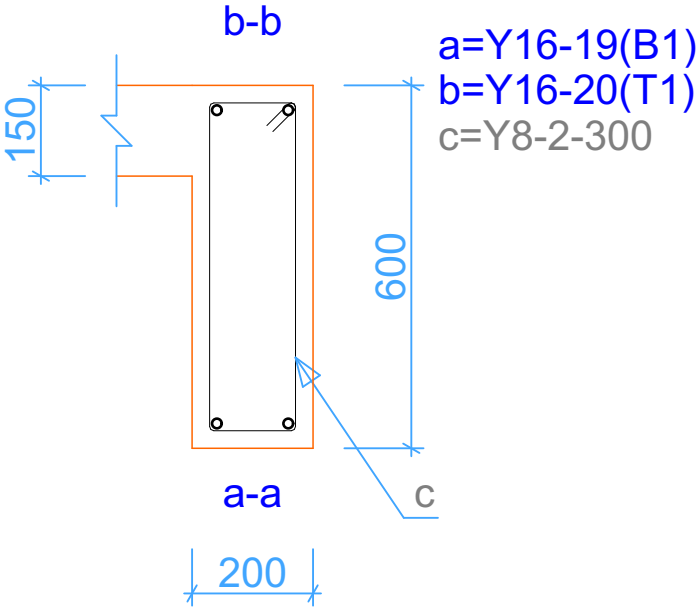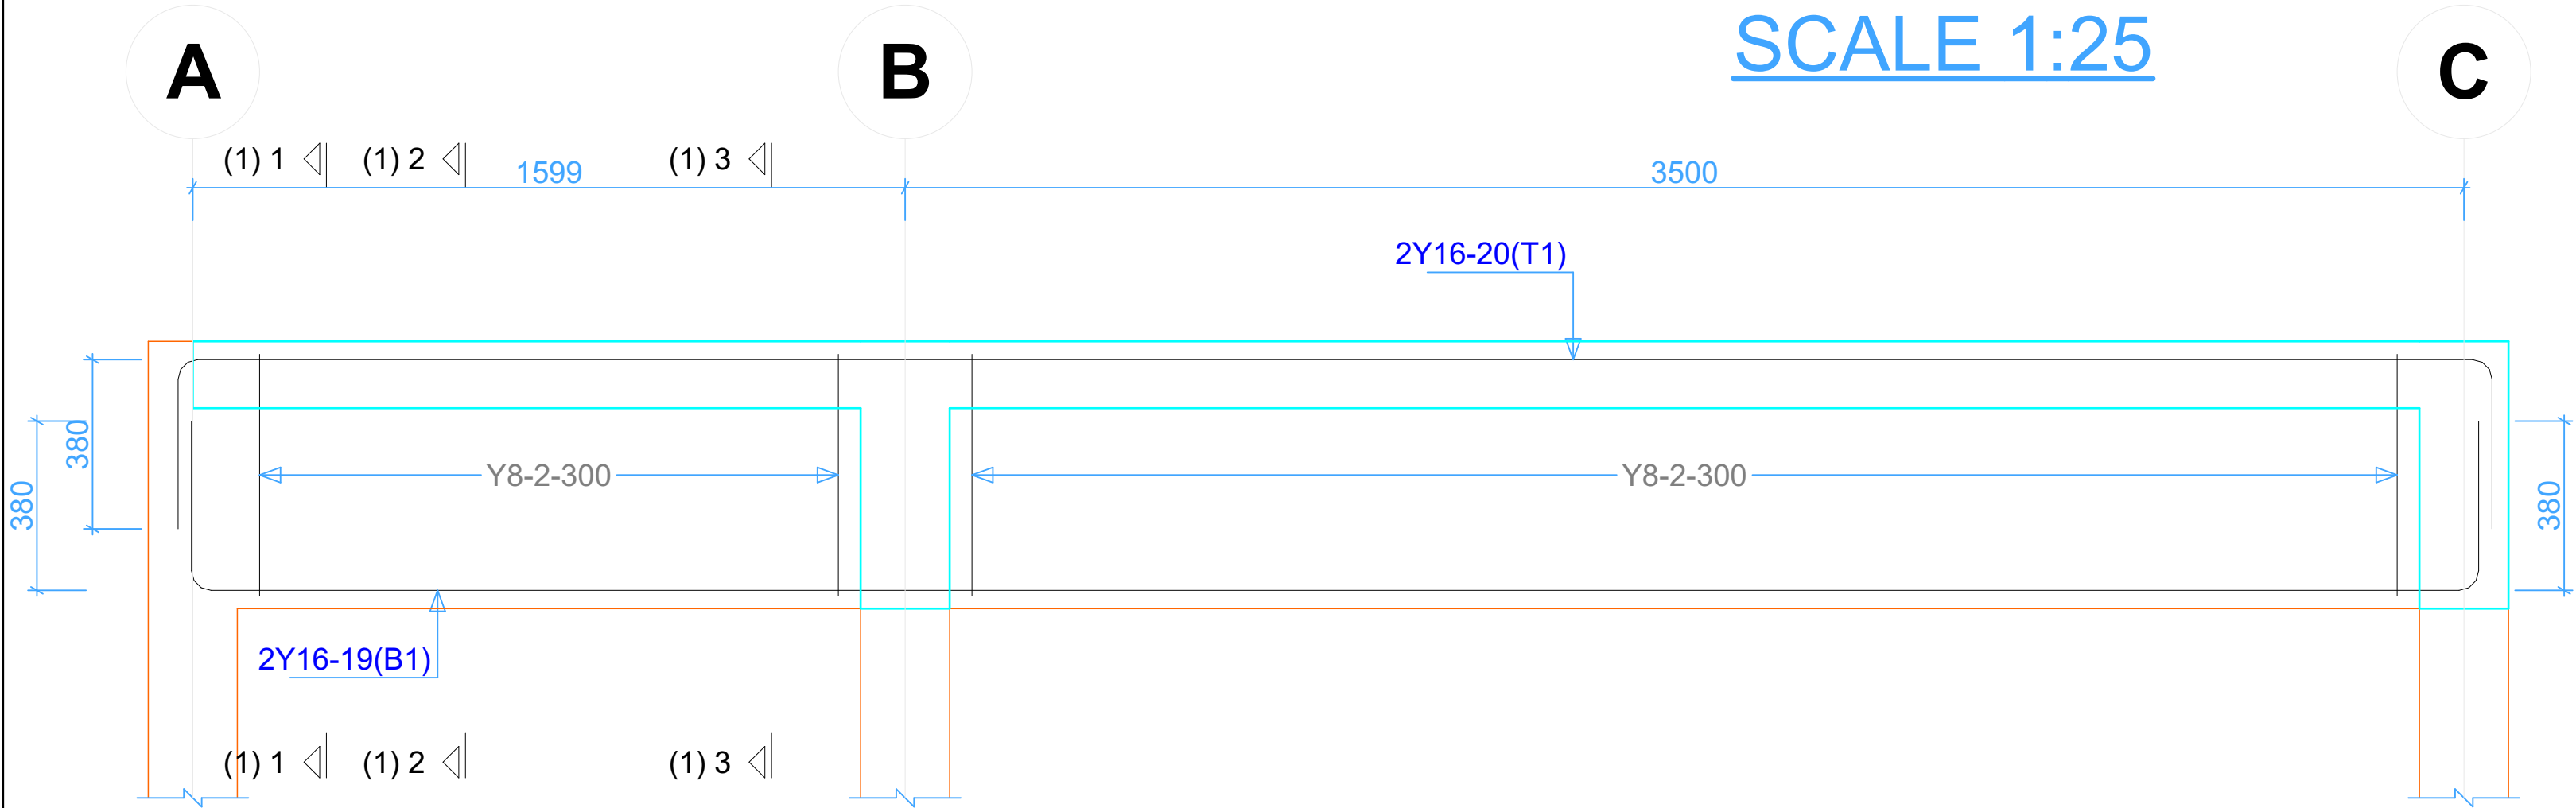


600X200 BEAM B3
SCALE 1:25

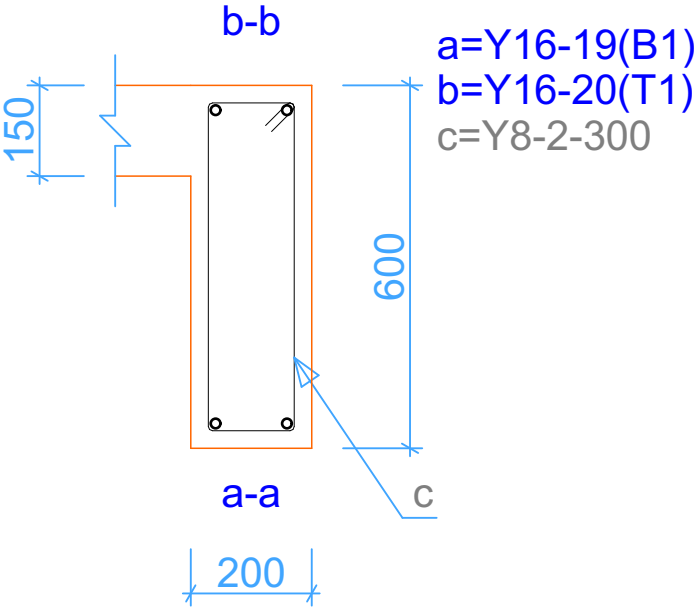


(1) 1 - 1





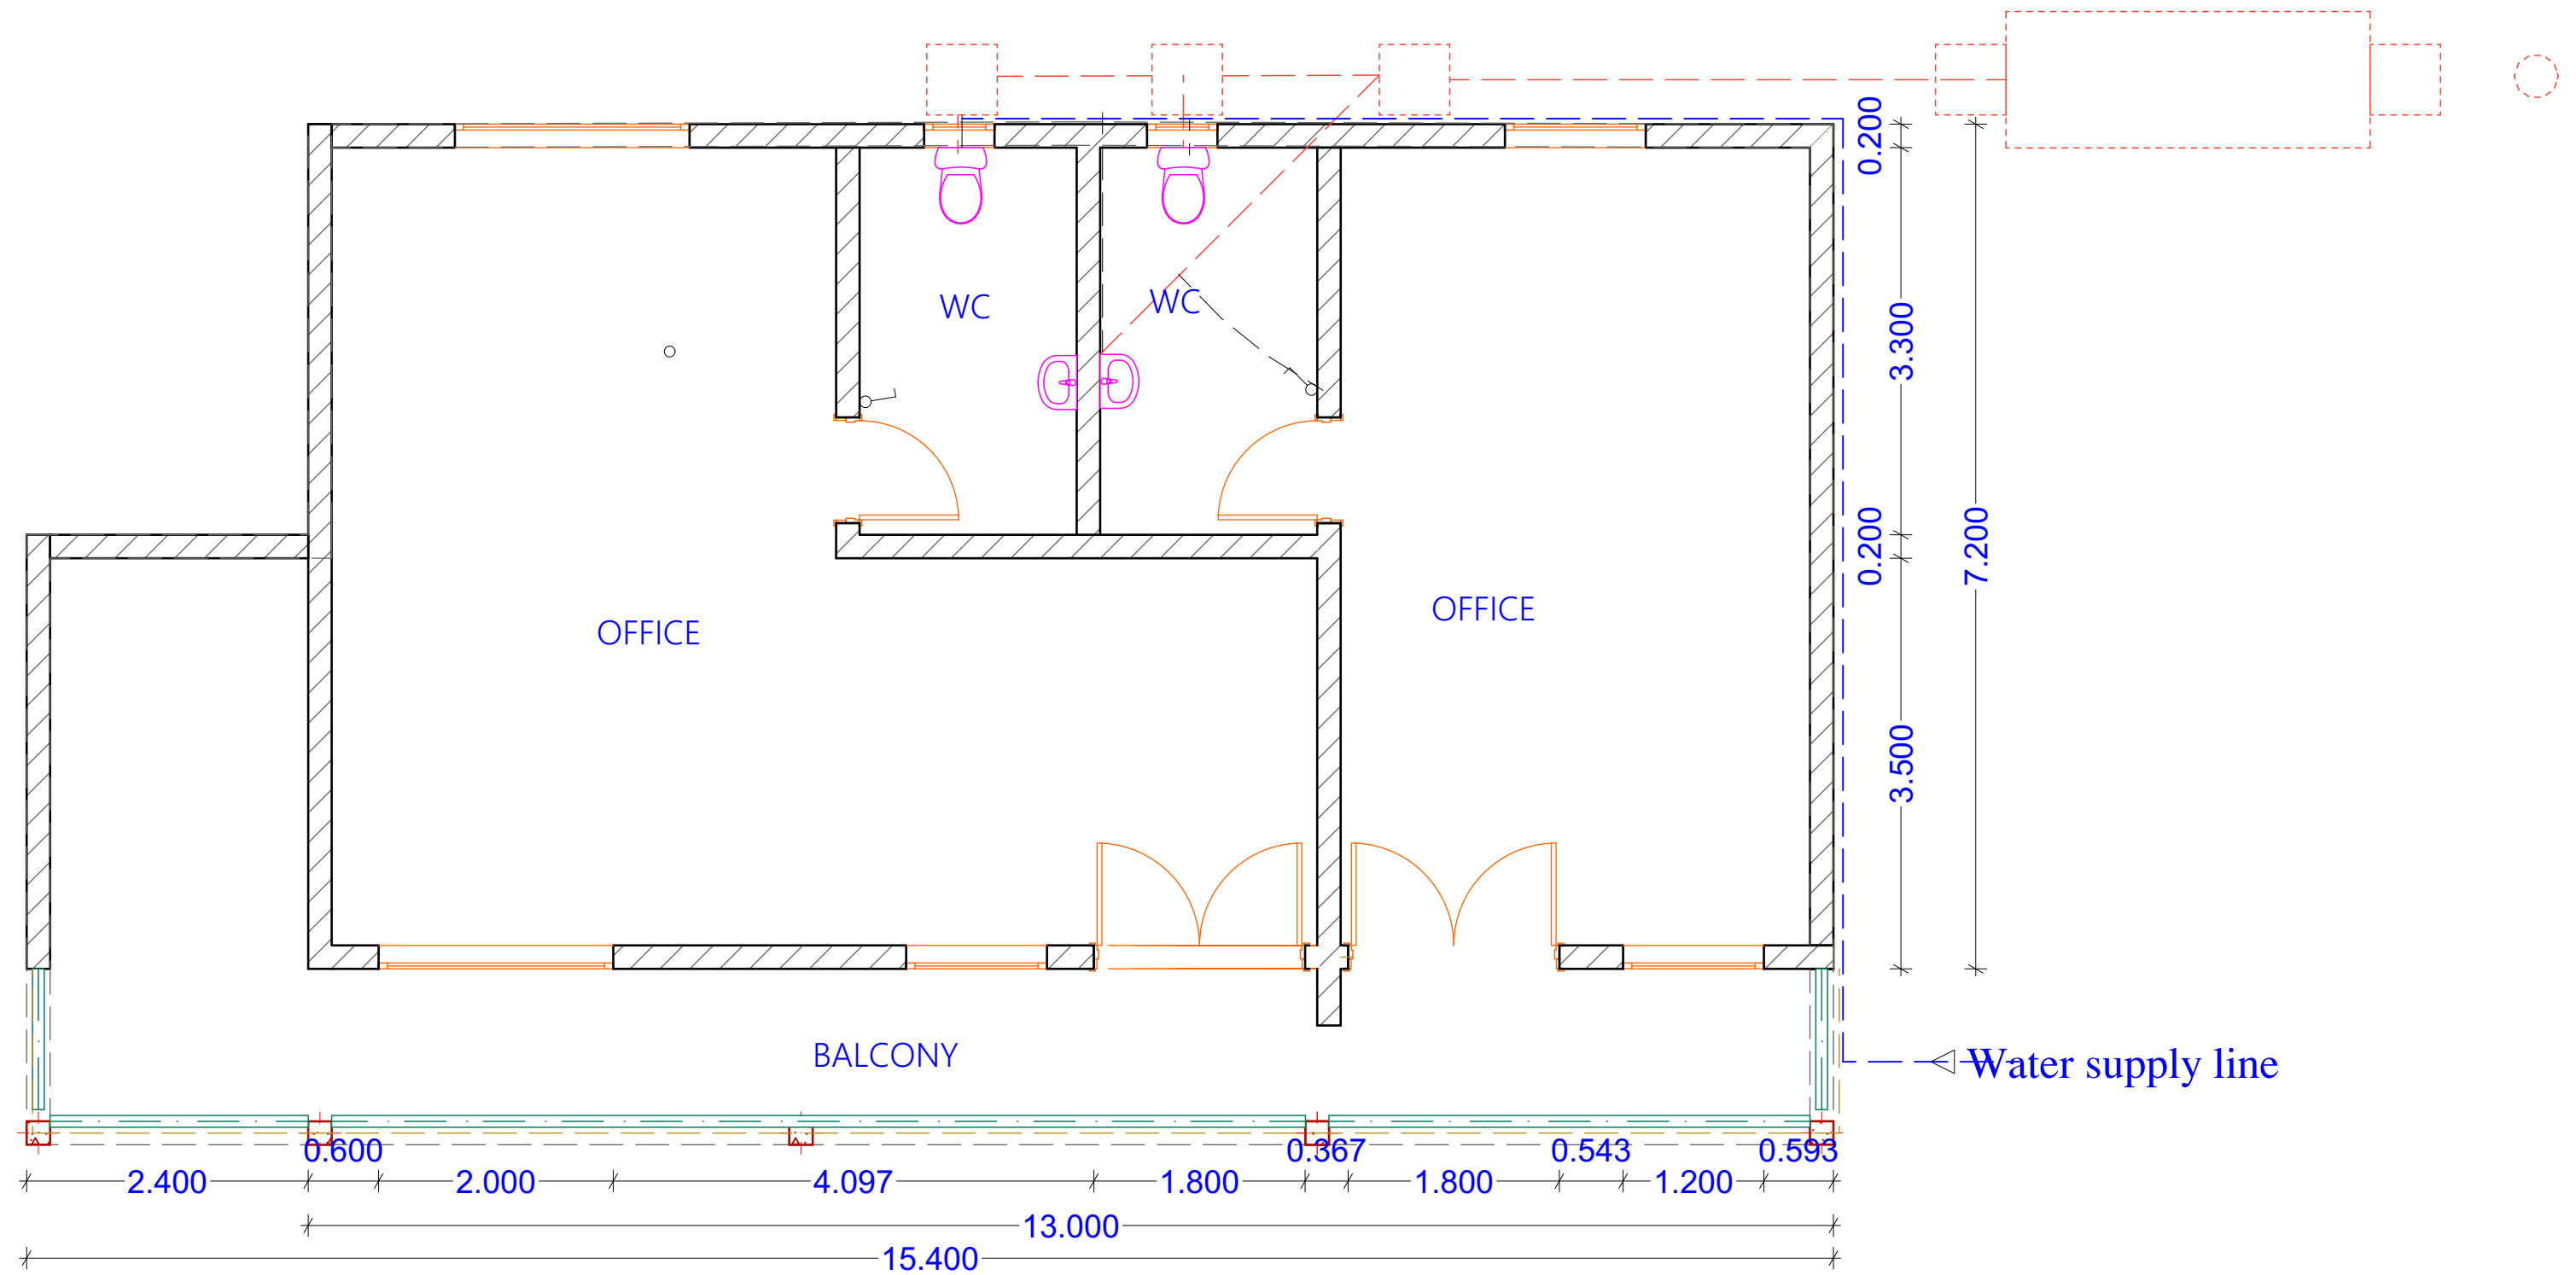


(1) 2 - 2

PROJECT TITLE:	DONOR:	DRAWING TITLE:	Project No.	Sheet No. 16/24	 ENDING EXTREME POVERTY WHATEVER IT TAKES Somalia
Dinning, Office, Kitchen and Toilets At Gahery Teachers Training Institue Xamar Jajab District, Banadir Region,Somalia	 		Scale: 1:100	Date: Sep 2021	
			Design: H.E.	Checked:	






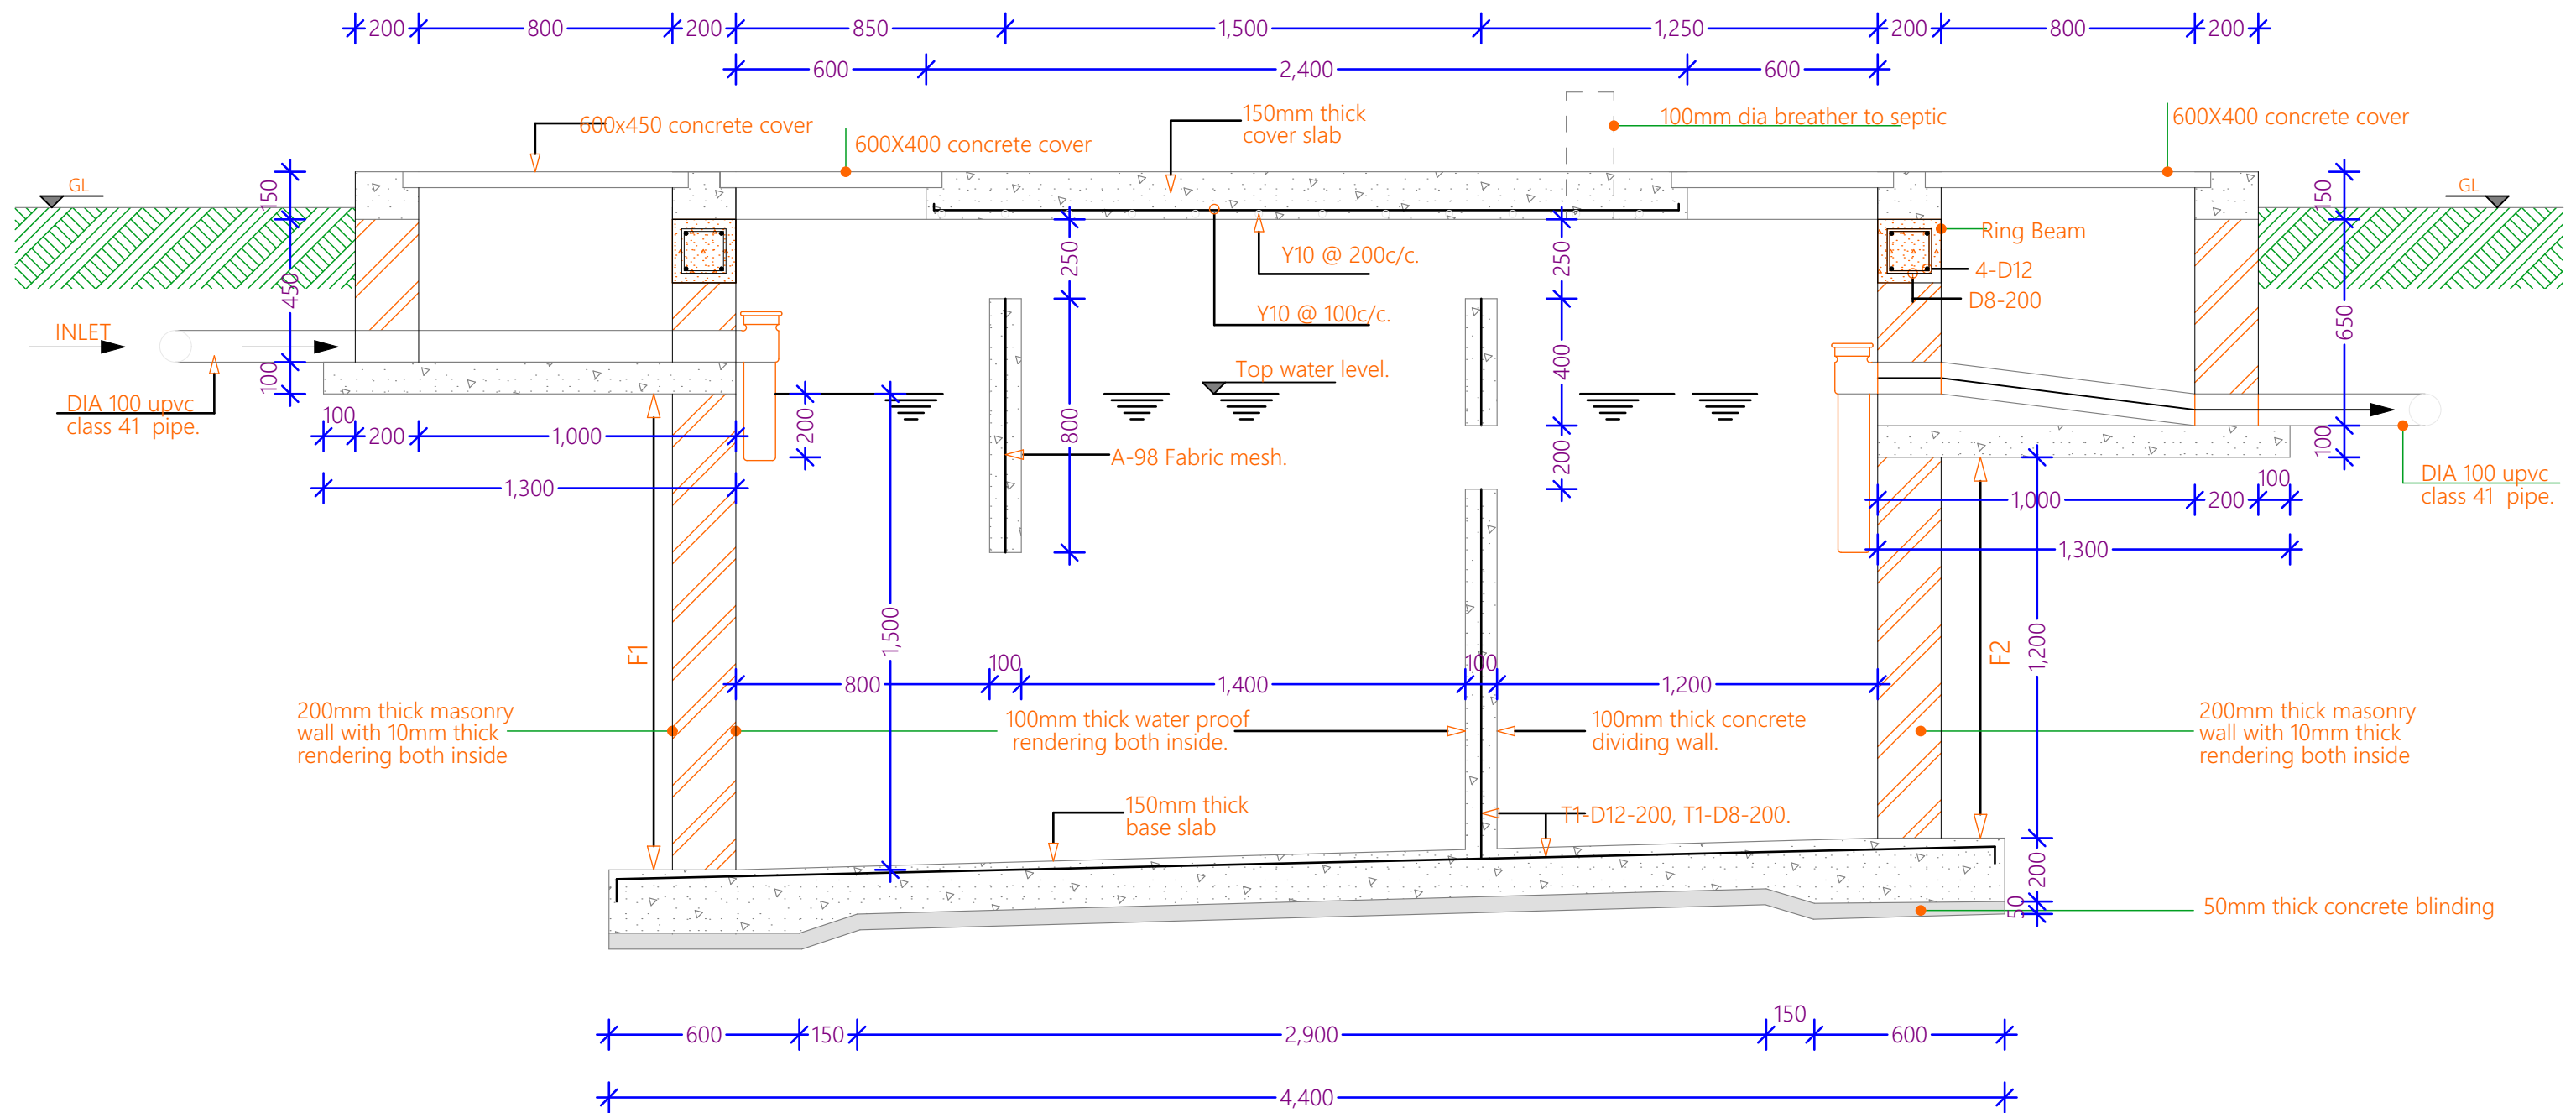
FIRST FLOOR-PLUMBING LAYOUT PLAN

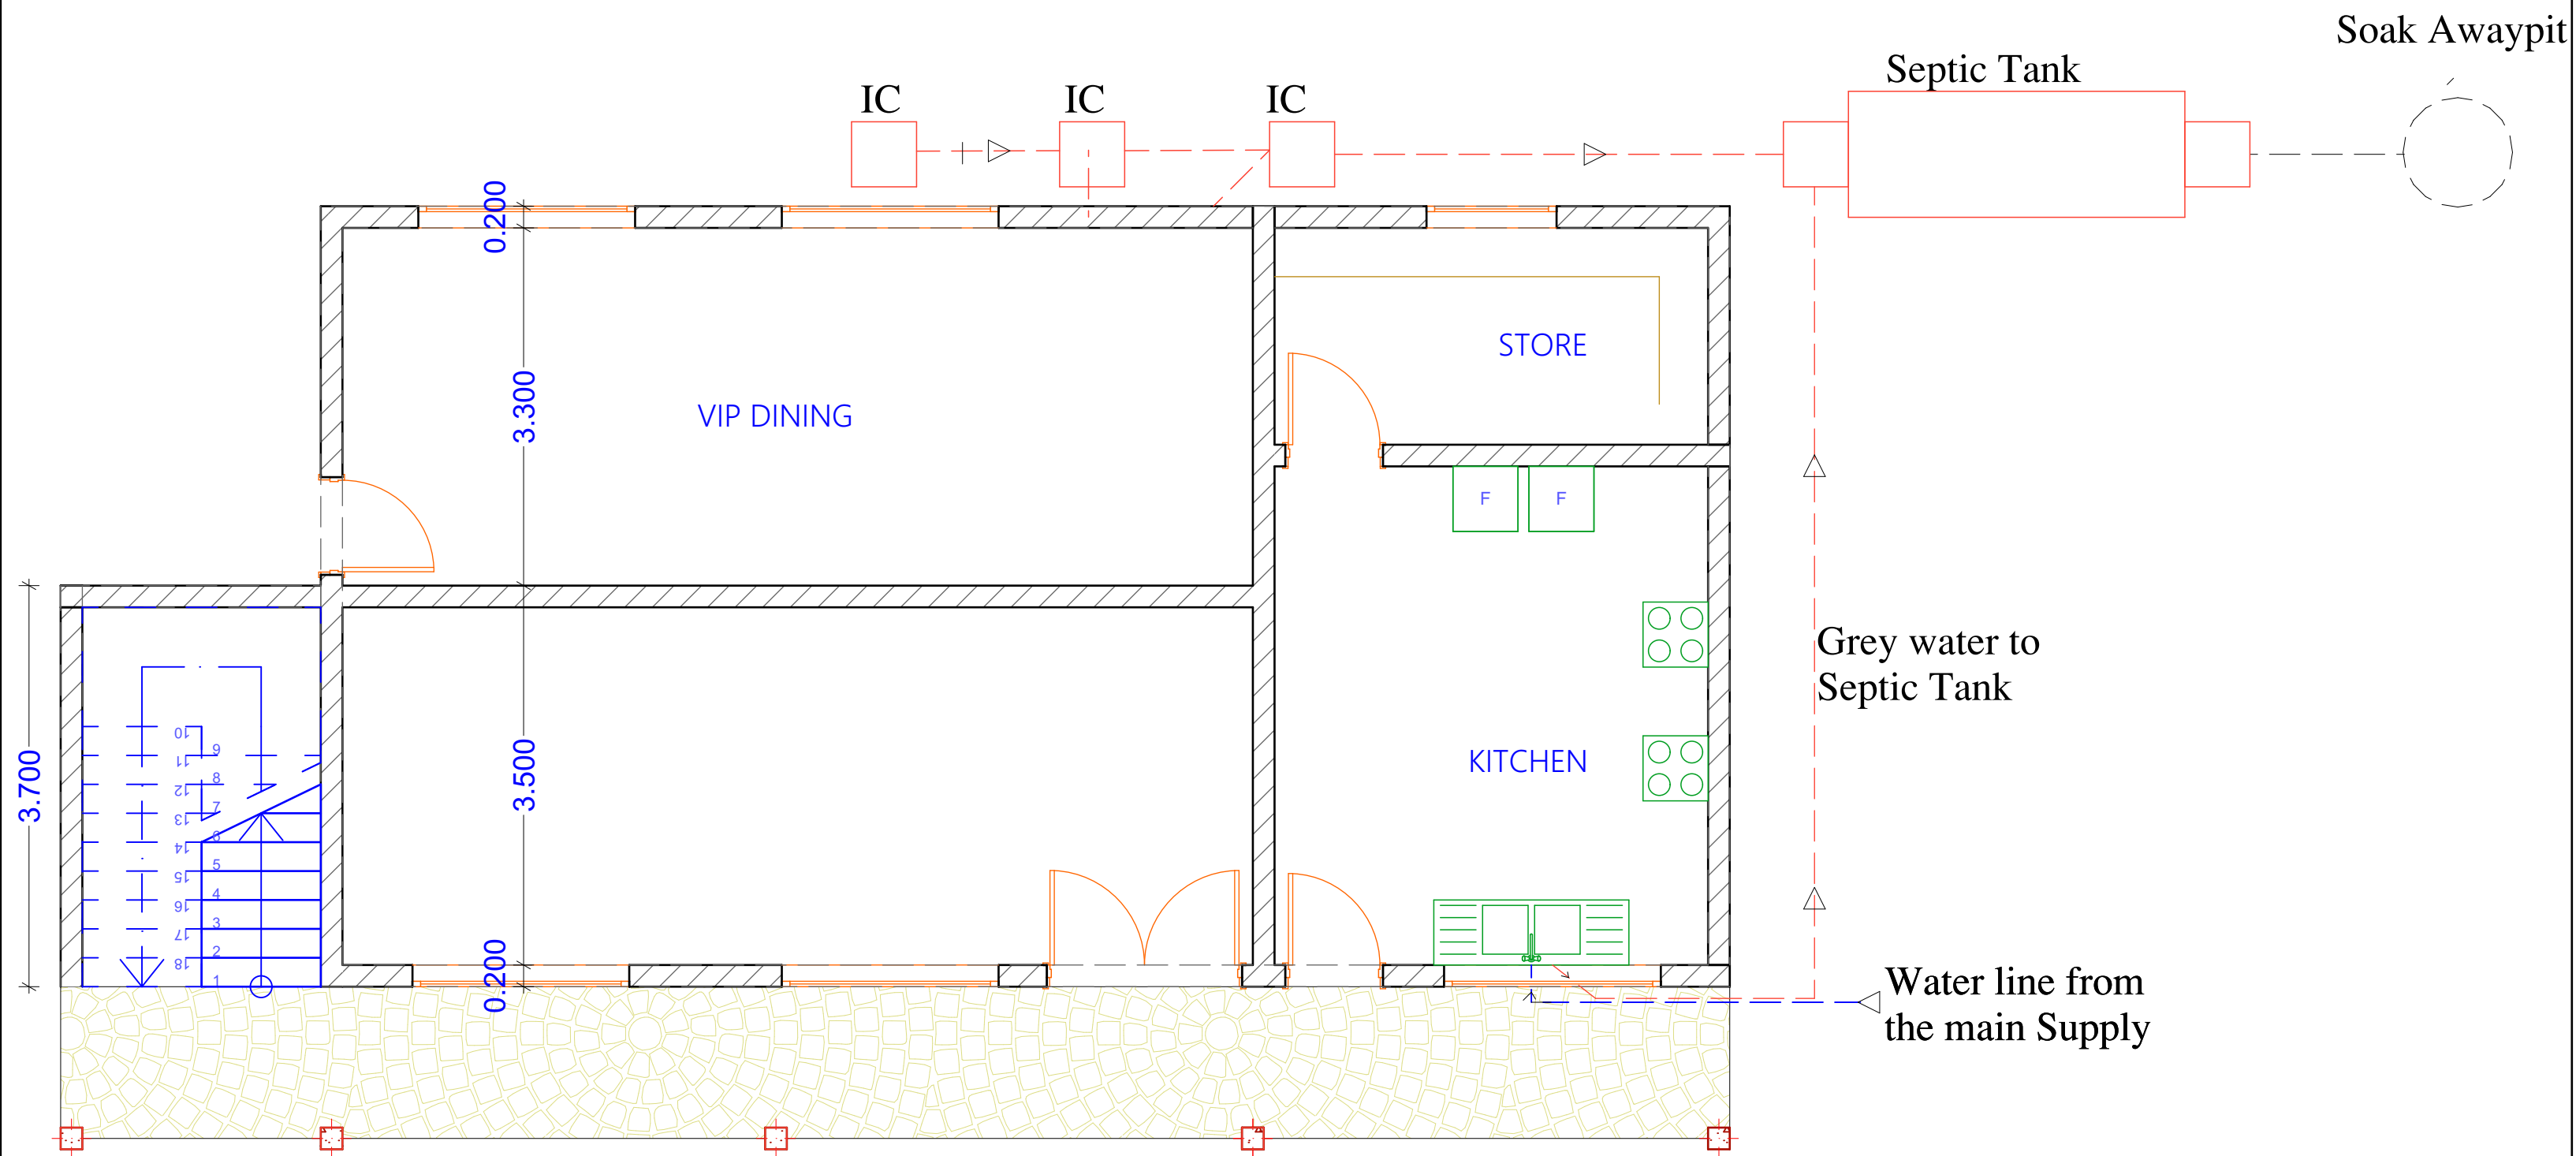


PROJECT TITLE:	DONOR:	DRAWING TITLE:	Project No.	Sheet No. 17/24	  Somalia
Dinning, Office, Kitchen and Toilets At Gahery Teachers Training Institue Xamar Jajab District, Banadir Region,Somalia	 		Scale: 1:100	Date: Sep 2021	
			Design: H.E.	Checked:	








GROUND FLOOR PLUMBING PLAN


PROJECT TITLE:	DONOR:	DRAWING TITLE:	Project No.	Sheet No. 18/24	 ENDING EXTREME POVERTY WHATEVER IT TAKES Somalia
Dinning, Office, Kitchen and Toilets At Gahery Teachers Training Institue Xamar Jajab District, Banadir Region,Somalia	 		Scale: 1:100	Date: Sep 2021	
			Design: H.E.	Checked:	

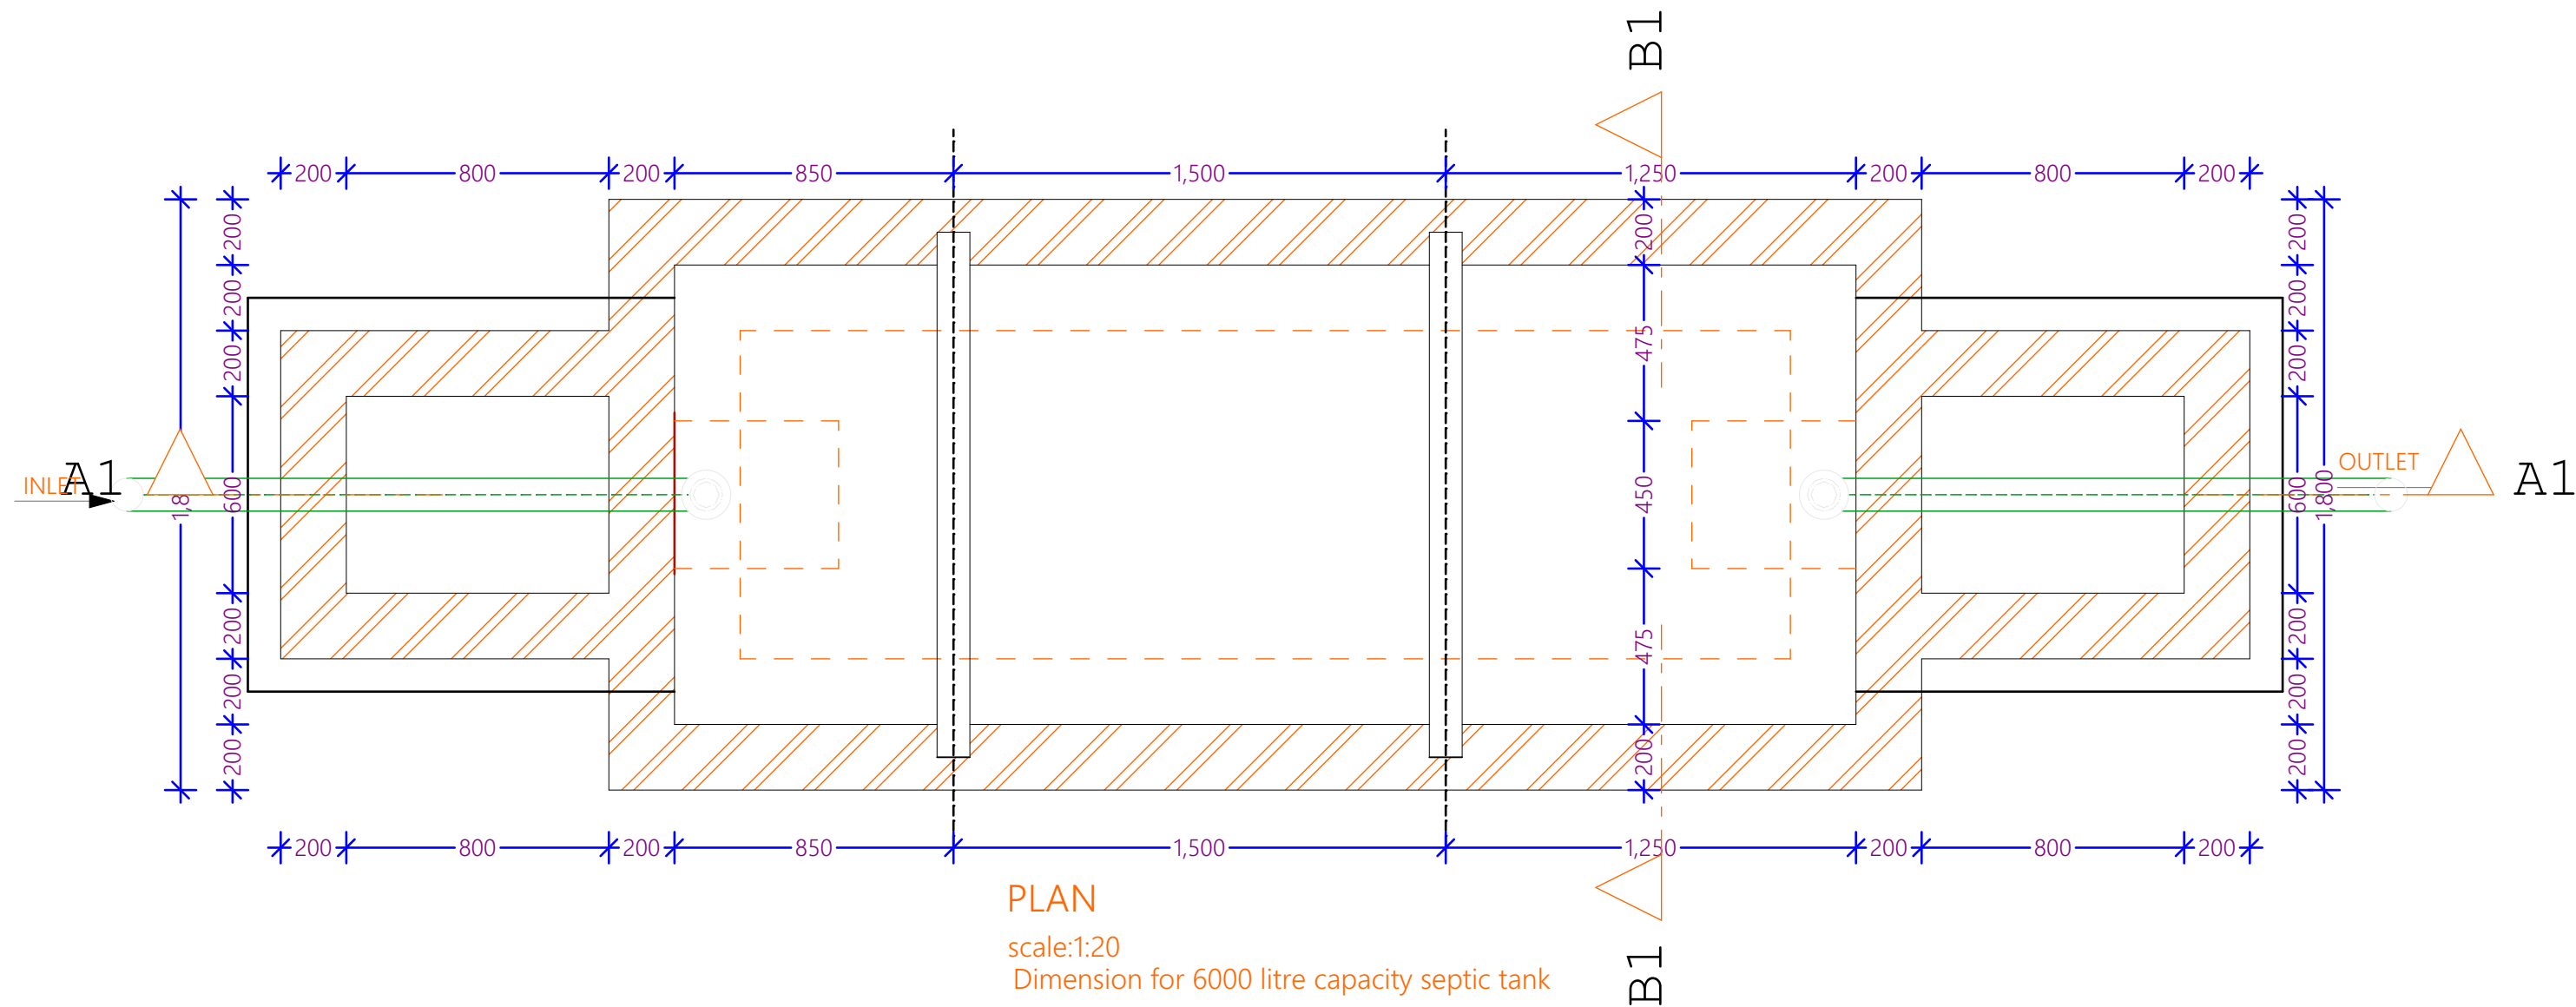

PROJECT TITLE:	DONOR:	DRAWING TITLE:	Project No.	Sheet No. 19/24	 <p>ENDING EXTREME POVERTY WHATEVER IT TAKES</p> <p>Somalia</p>
Dinning, Office, Kitchen and Toilets At Gahery Teachers Training Institue Xamar Jajab District, Banadir Region,Somalia	 		Scale: 1:100	Date: Sep 2021	
			Design: H.E.	Checked:	




PROJECT TITLE:	DONOR:	DRAWING TITLE:	Project No.	Sheet No. 20/24	  Somalia
Dinning, Office, Kitchen and Toilets At Gahery Teachers Training Institue Xamar Jajab District, Banadir Region,Somalia	 		Scale: 1:100	Date: Sep 2021	
			Design: H.E.	Checked:	

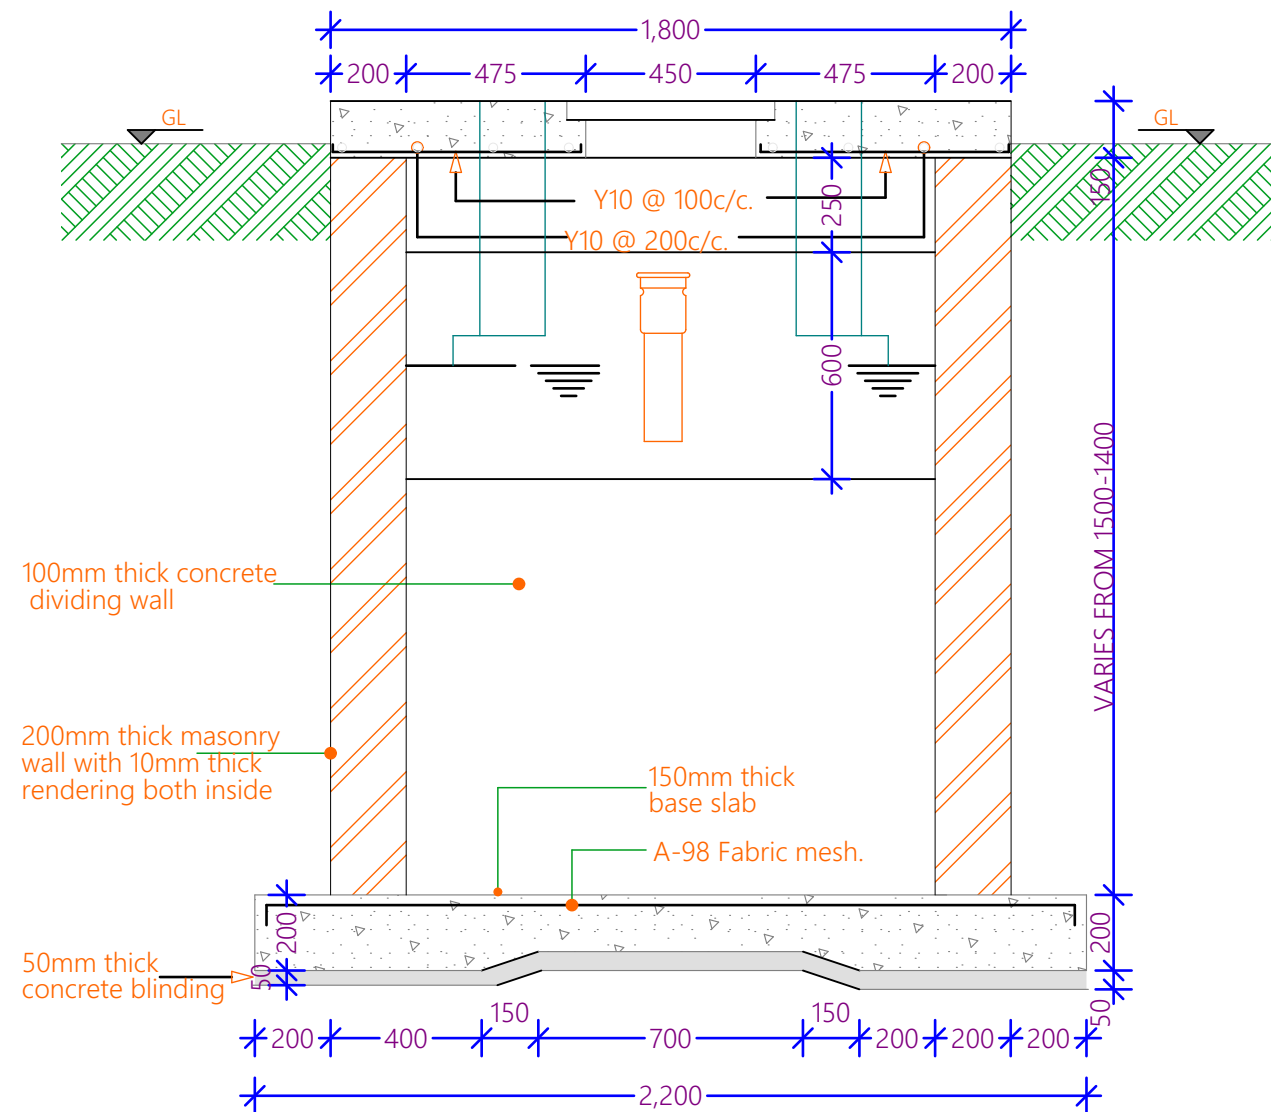



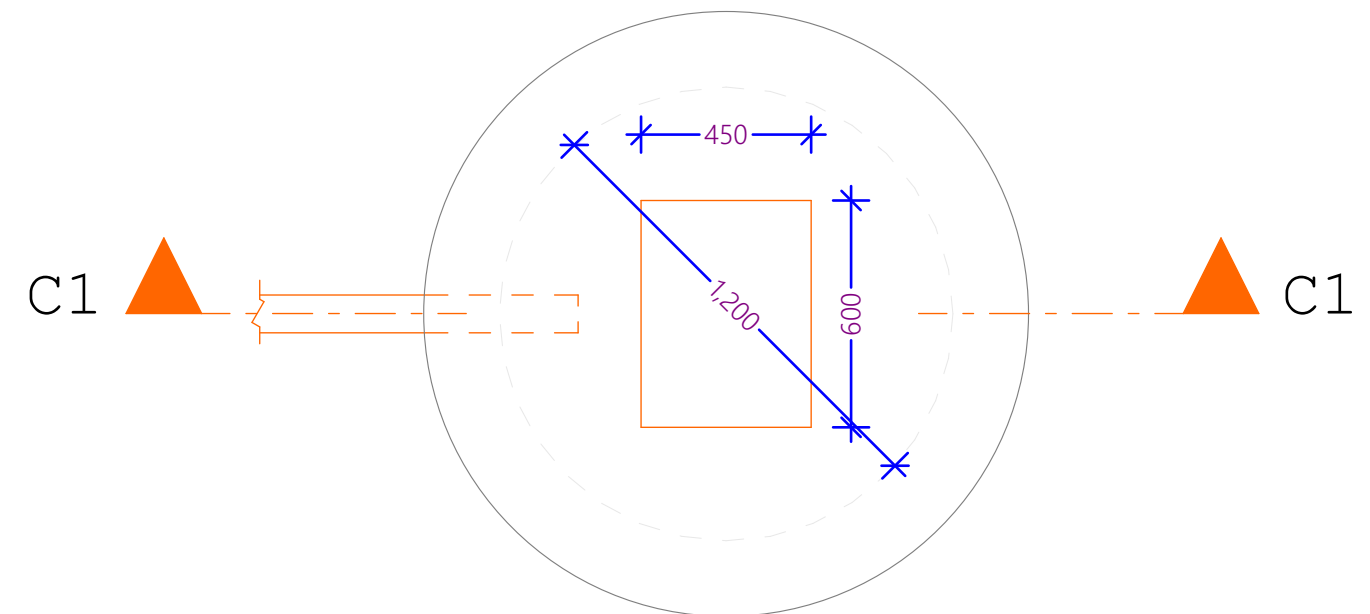

SECTION B-B


scale:1:20





PLAN


scale:1:20

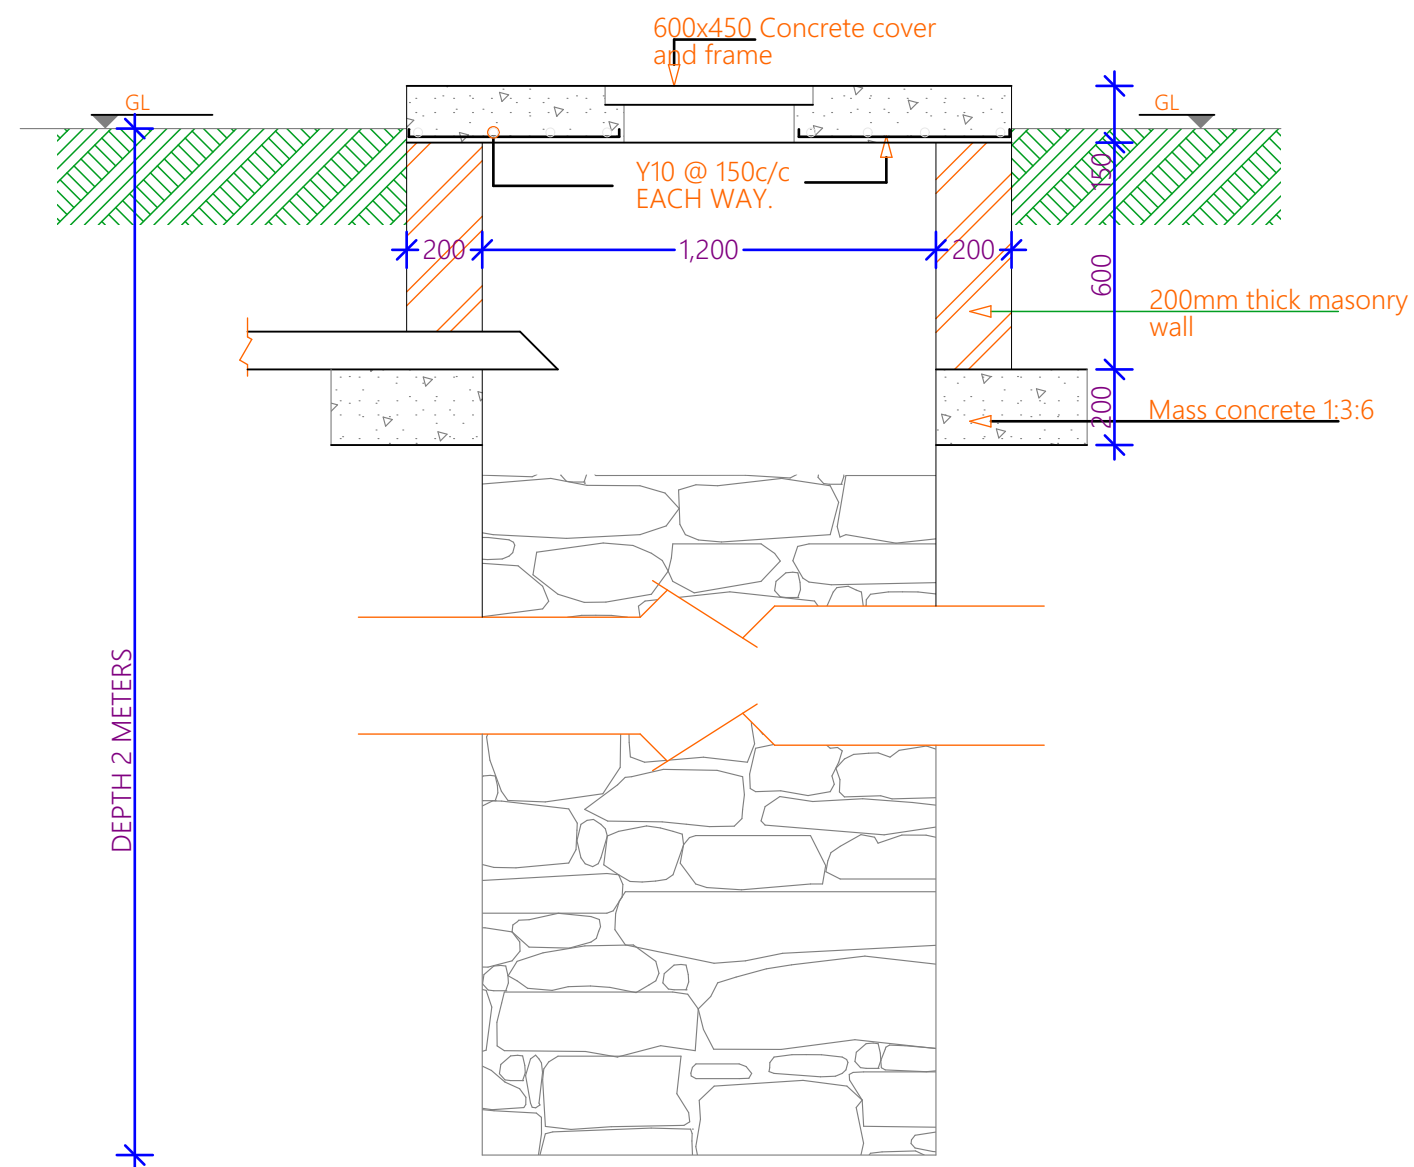PROJECT TITLE:	DONOR:	DRAWING TITLE:	Project No.	Sheet No. 21/24	  <p>Somalia</p>
Dinning, Office, Kitchen and Toilets At Gahery Teachers Training Institue Xamar Jajab District, Banadir Region,Somalia	 		Scale: 1:100	Date: Sep 2021	
			Design: H.E.	Checked:	






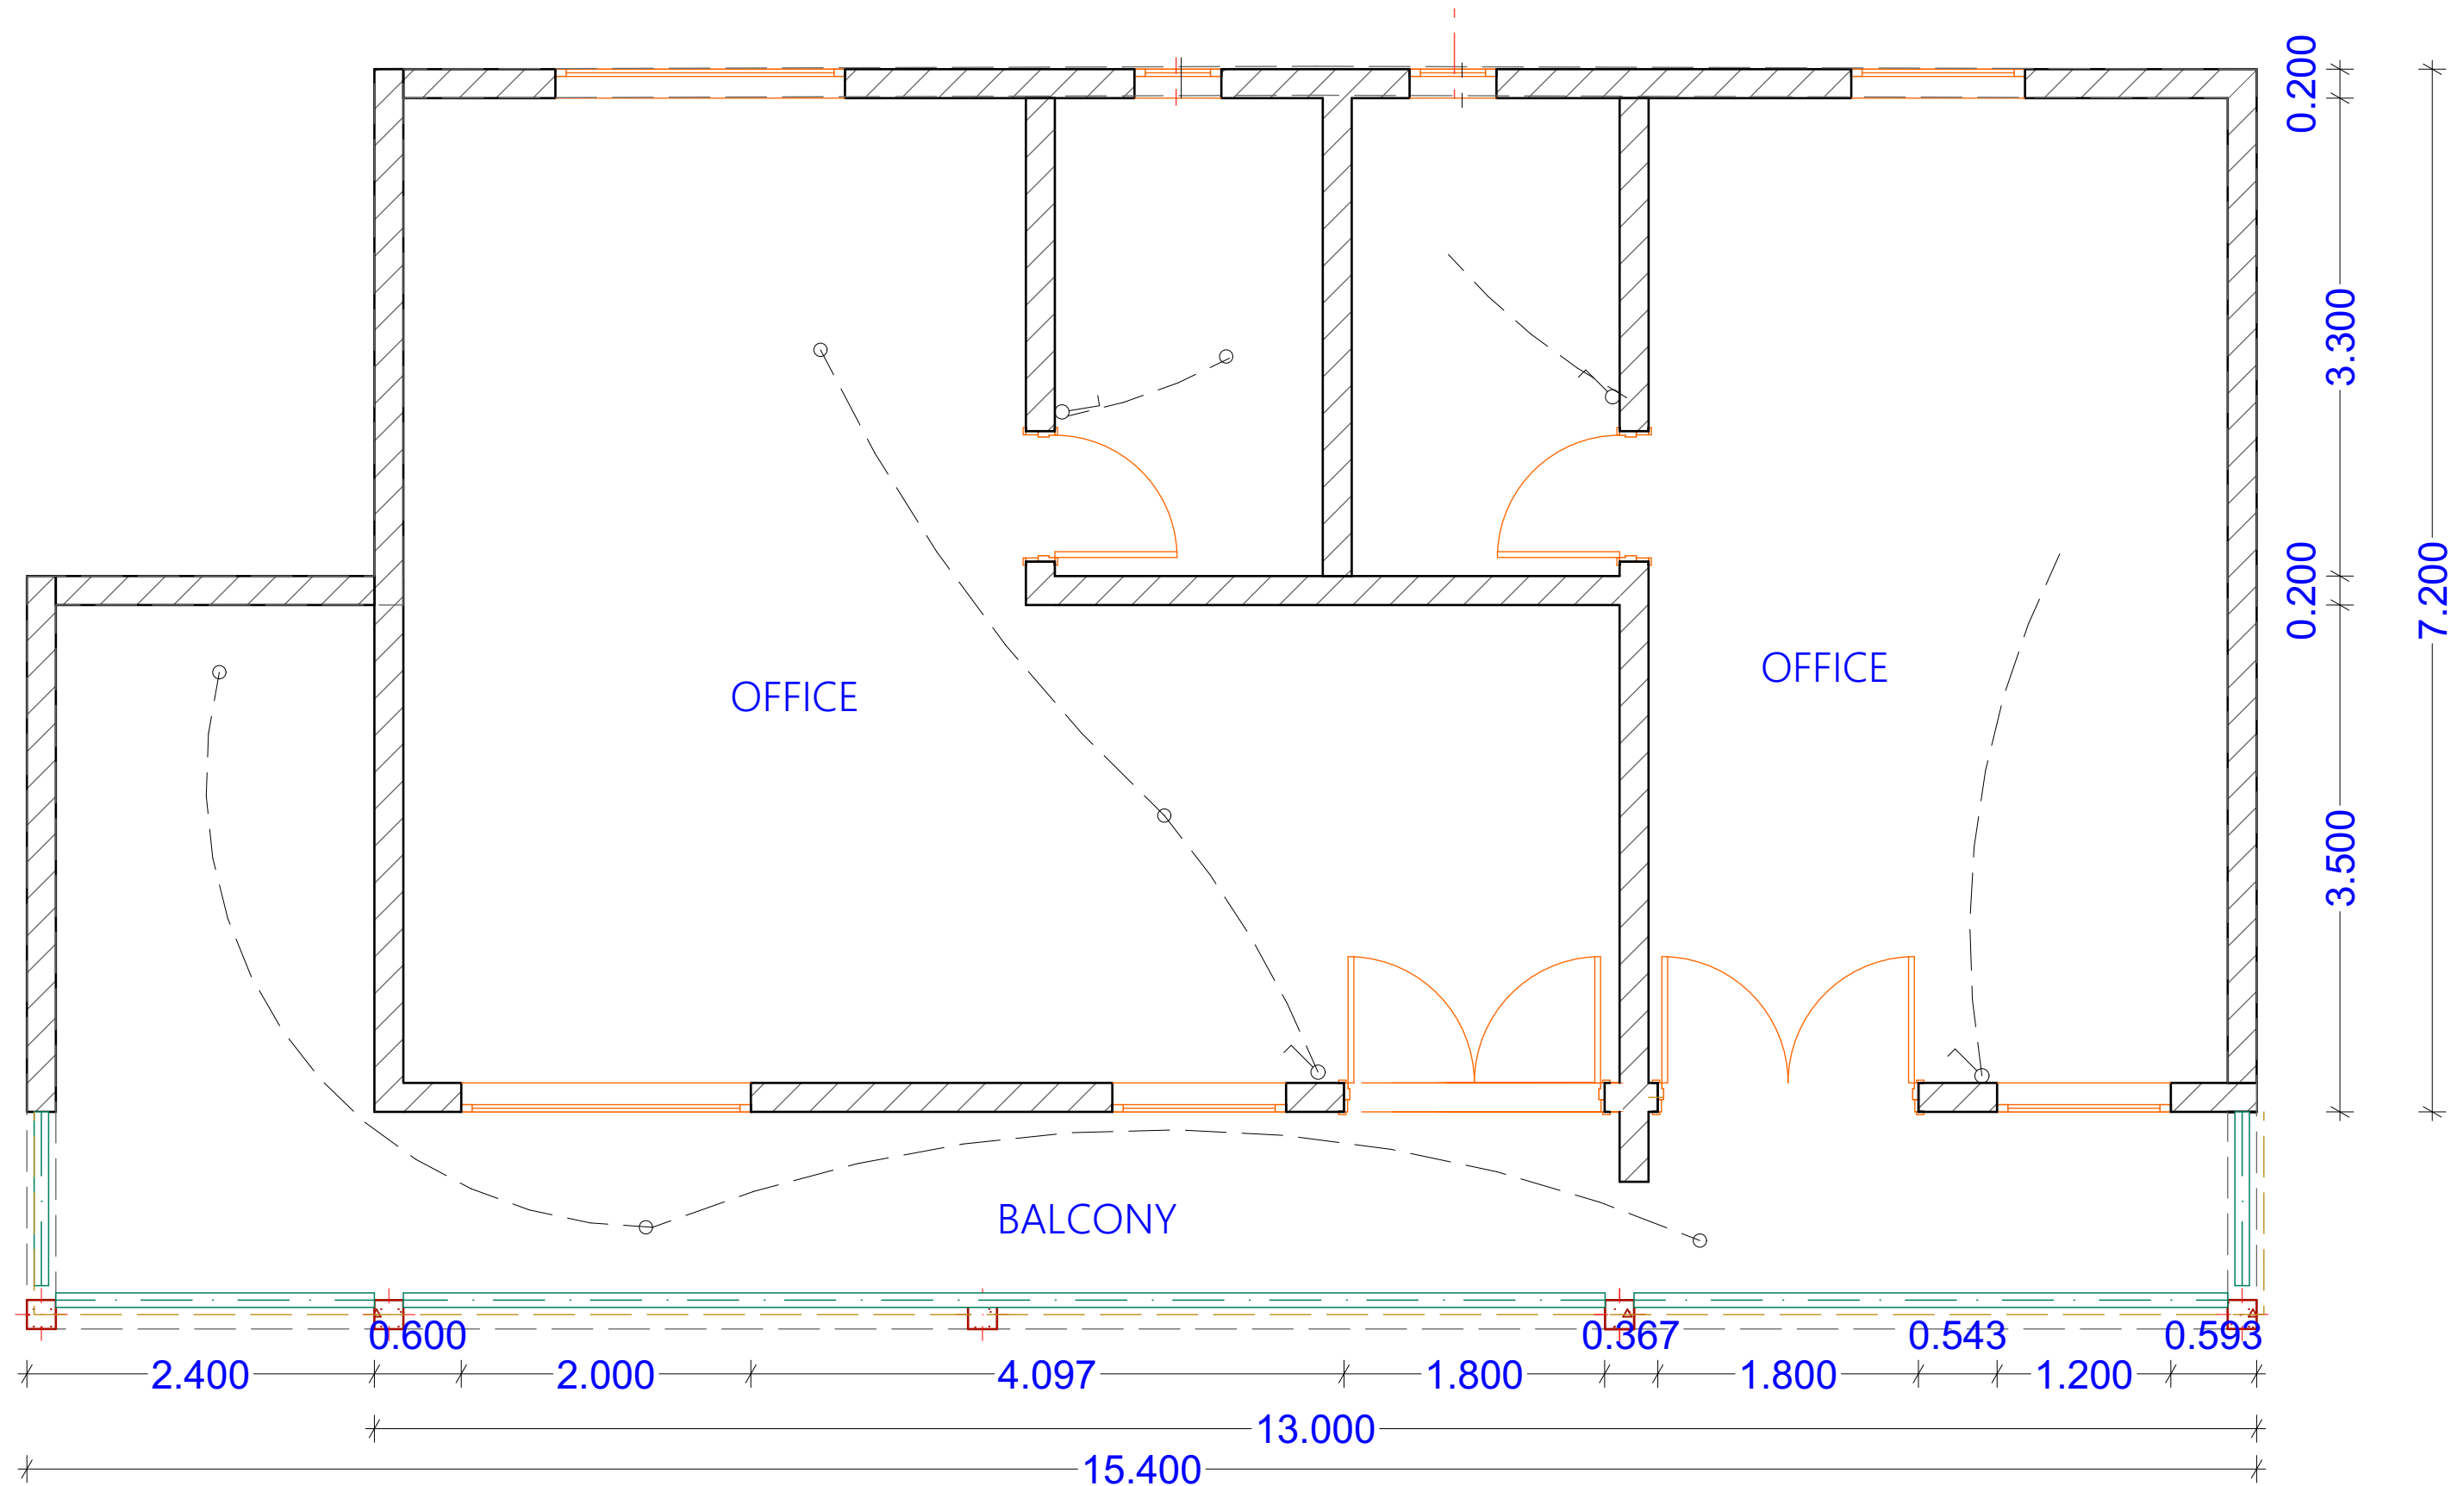
SECTION C-C
scale:1:20
SOAK PIT DETAILS

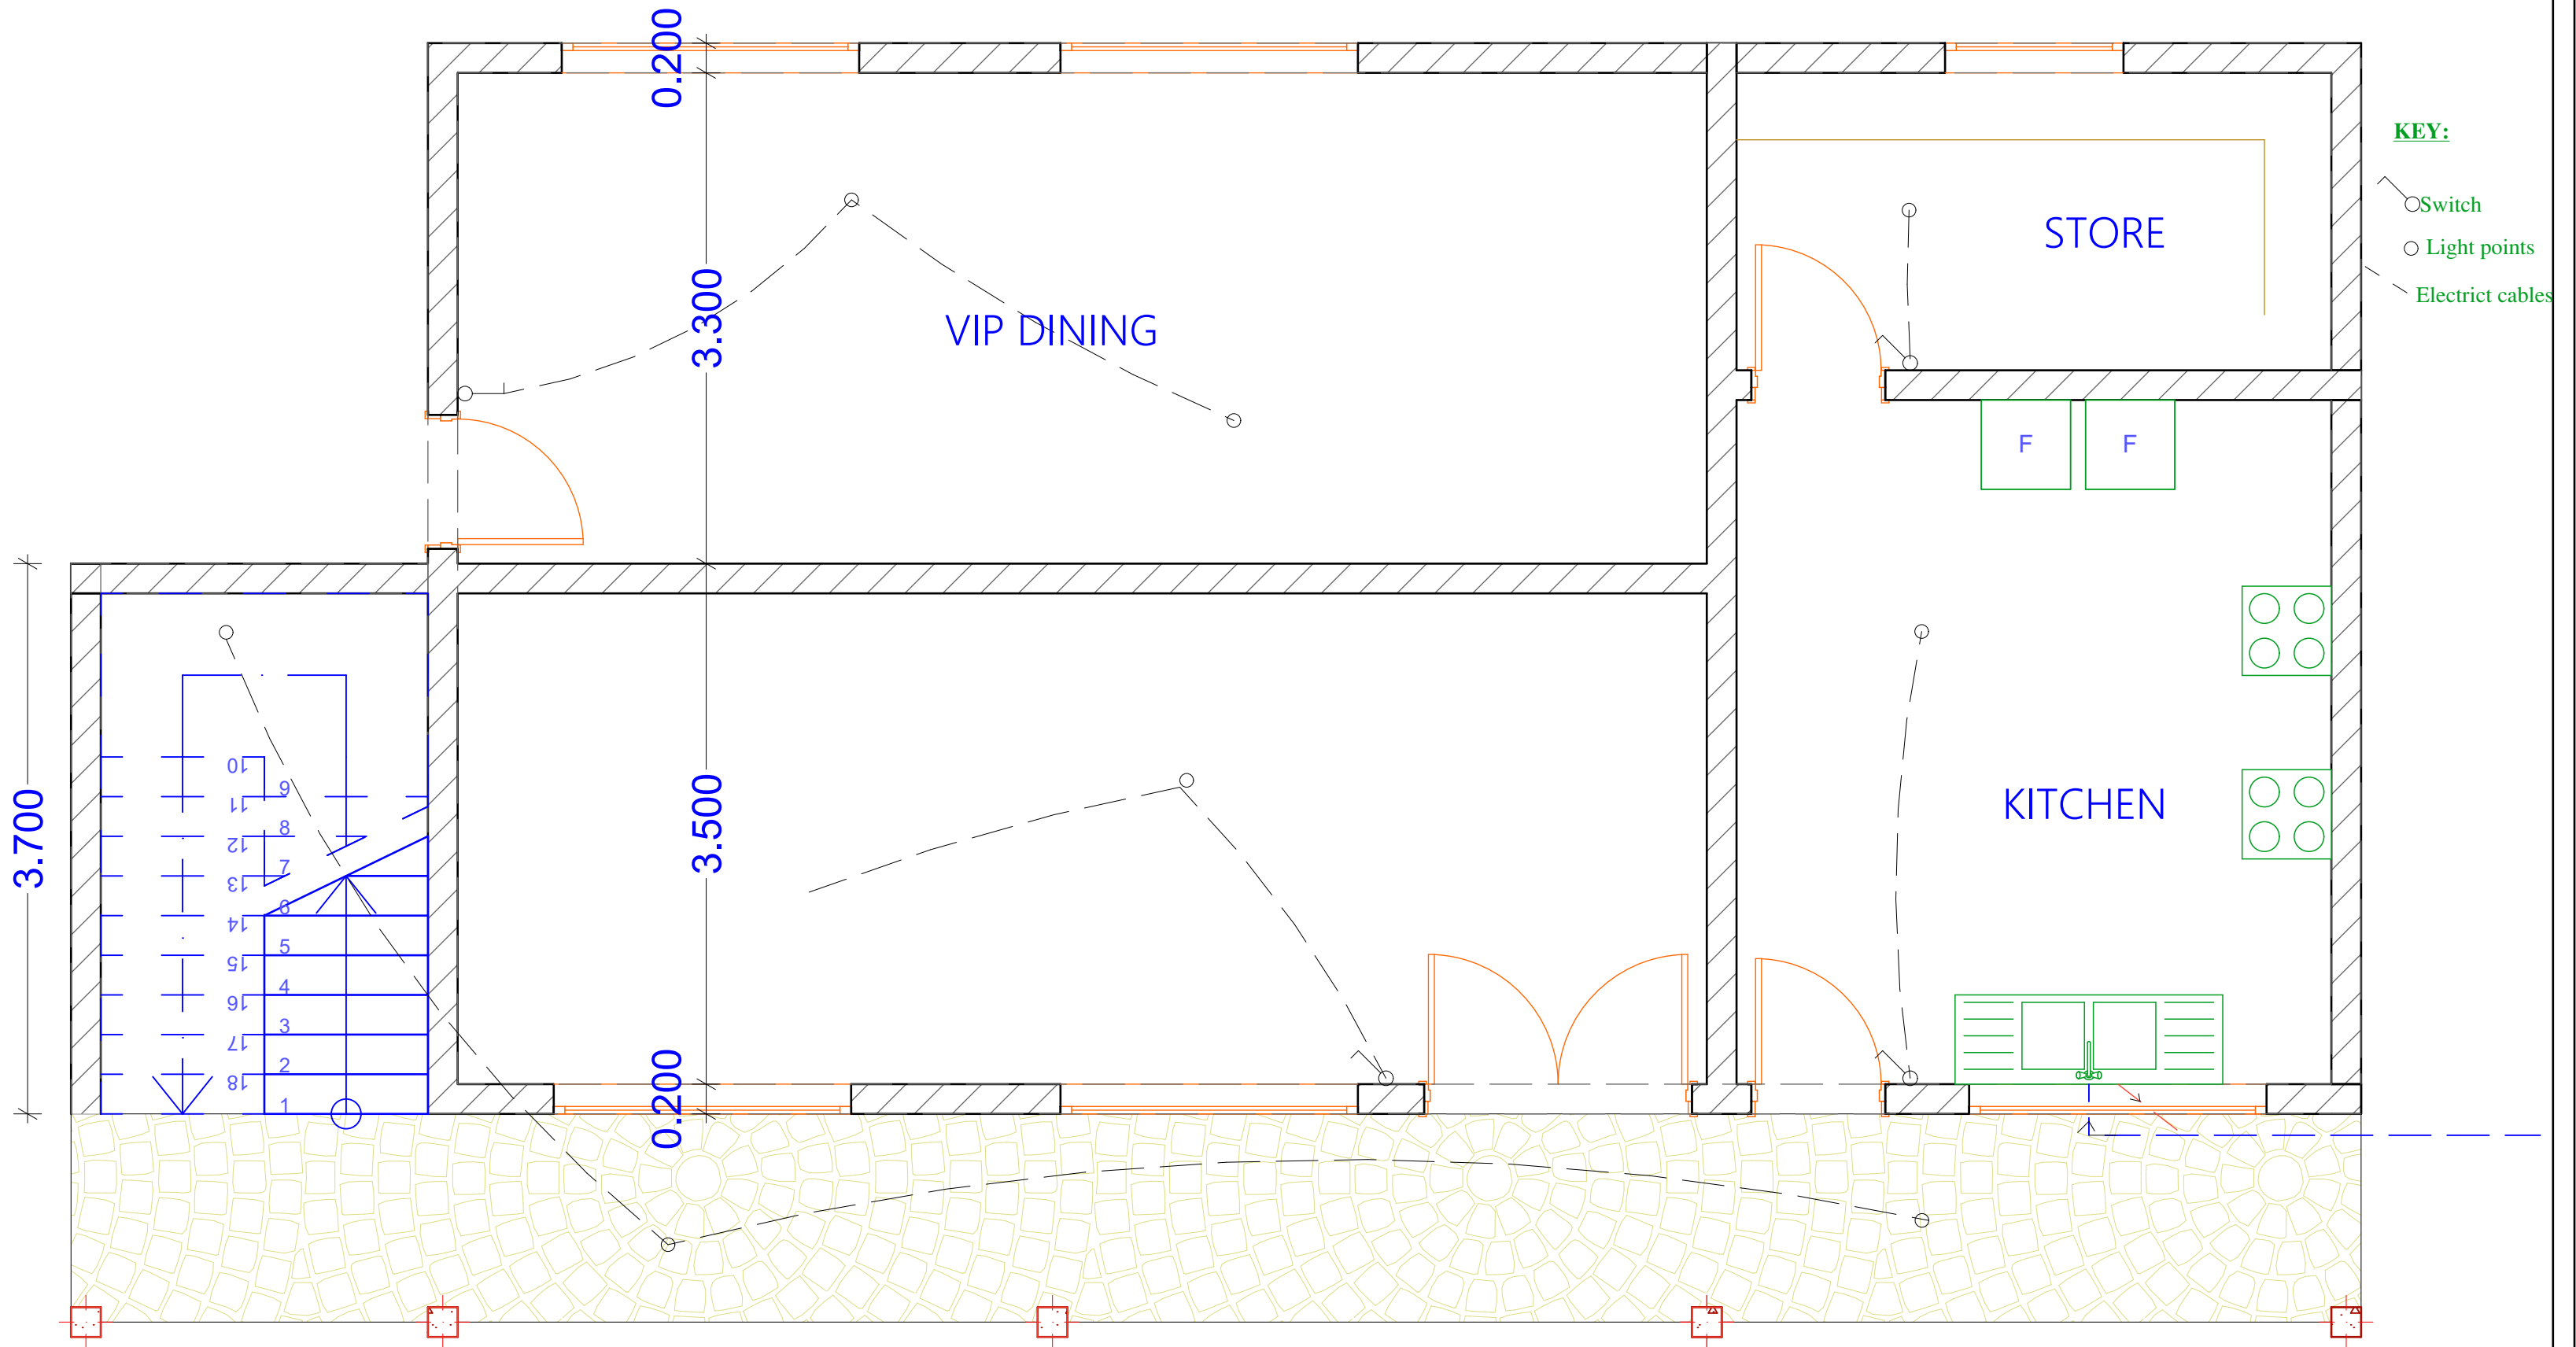PROJECT TITLE:	DONOR:	DRAWING TITLE:	Project No.	Sheet No. 22/24	<div><div>CONCERN</div><div>worldwide</div><div>ENDING EXTREME POVERTY WHATEVER IT TAKES</div><div>Somalia</div></div>
Dinning, Office, Kitchen and Toilets At Gahery Teachers Training Institue Xamar Jajab District, Banadir Region,Somalia	 		Scale: 1:100	Date: Sep 2021	
			Design: H.E.	Checked:	






GROUND LIGHTING PLAN

PROJECT TITLE:	DONOR:	DRAWING TITLE:	Project No.	Sheet No. 23/24	 ENDING EXTREME POVERTY WHATEVER IT TAKES Somalia
Dinning, Office, Kitchen and Toilets At Gahery Teachers Training Institue Xamar Jajab District, Banadir Region,Somalia	 		Scale: 1:100	Date: Sep 2021	
			Design: H.E.	Checked:	



FIRST FLOOR ELECTRICAL LAYOUT PLAN

PROJECT TITLE:	DONOR:	DRAWING TITLE:	Project No.	Sheet No. 24/24	 ENDING EXTREME POVERTY WHATEVER IT TAKES Somalia
Dinning, Office, Kitchen and Toilets At Gahery Teachers Training Institue Xamar Jajab District, Banadir Region,Somalia	 		Scale: 1:100	Date: Sep 2021	
			Design: H.E.	Checked:	