


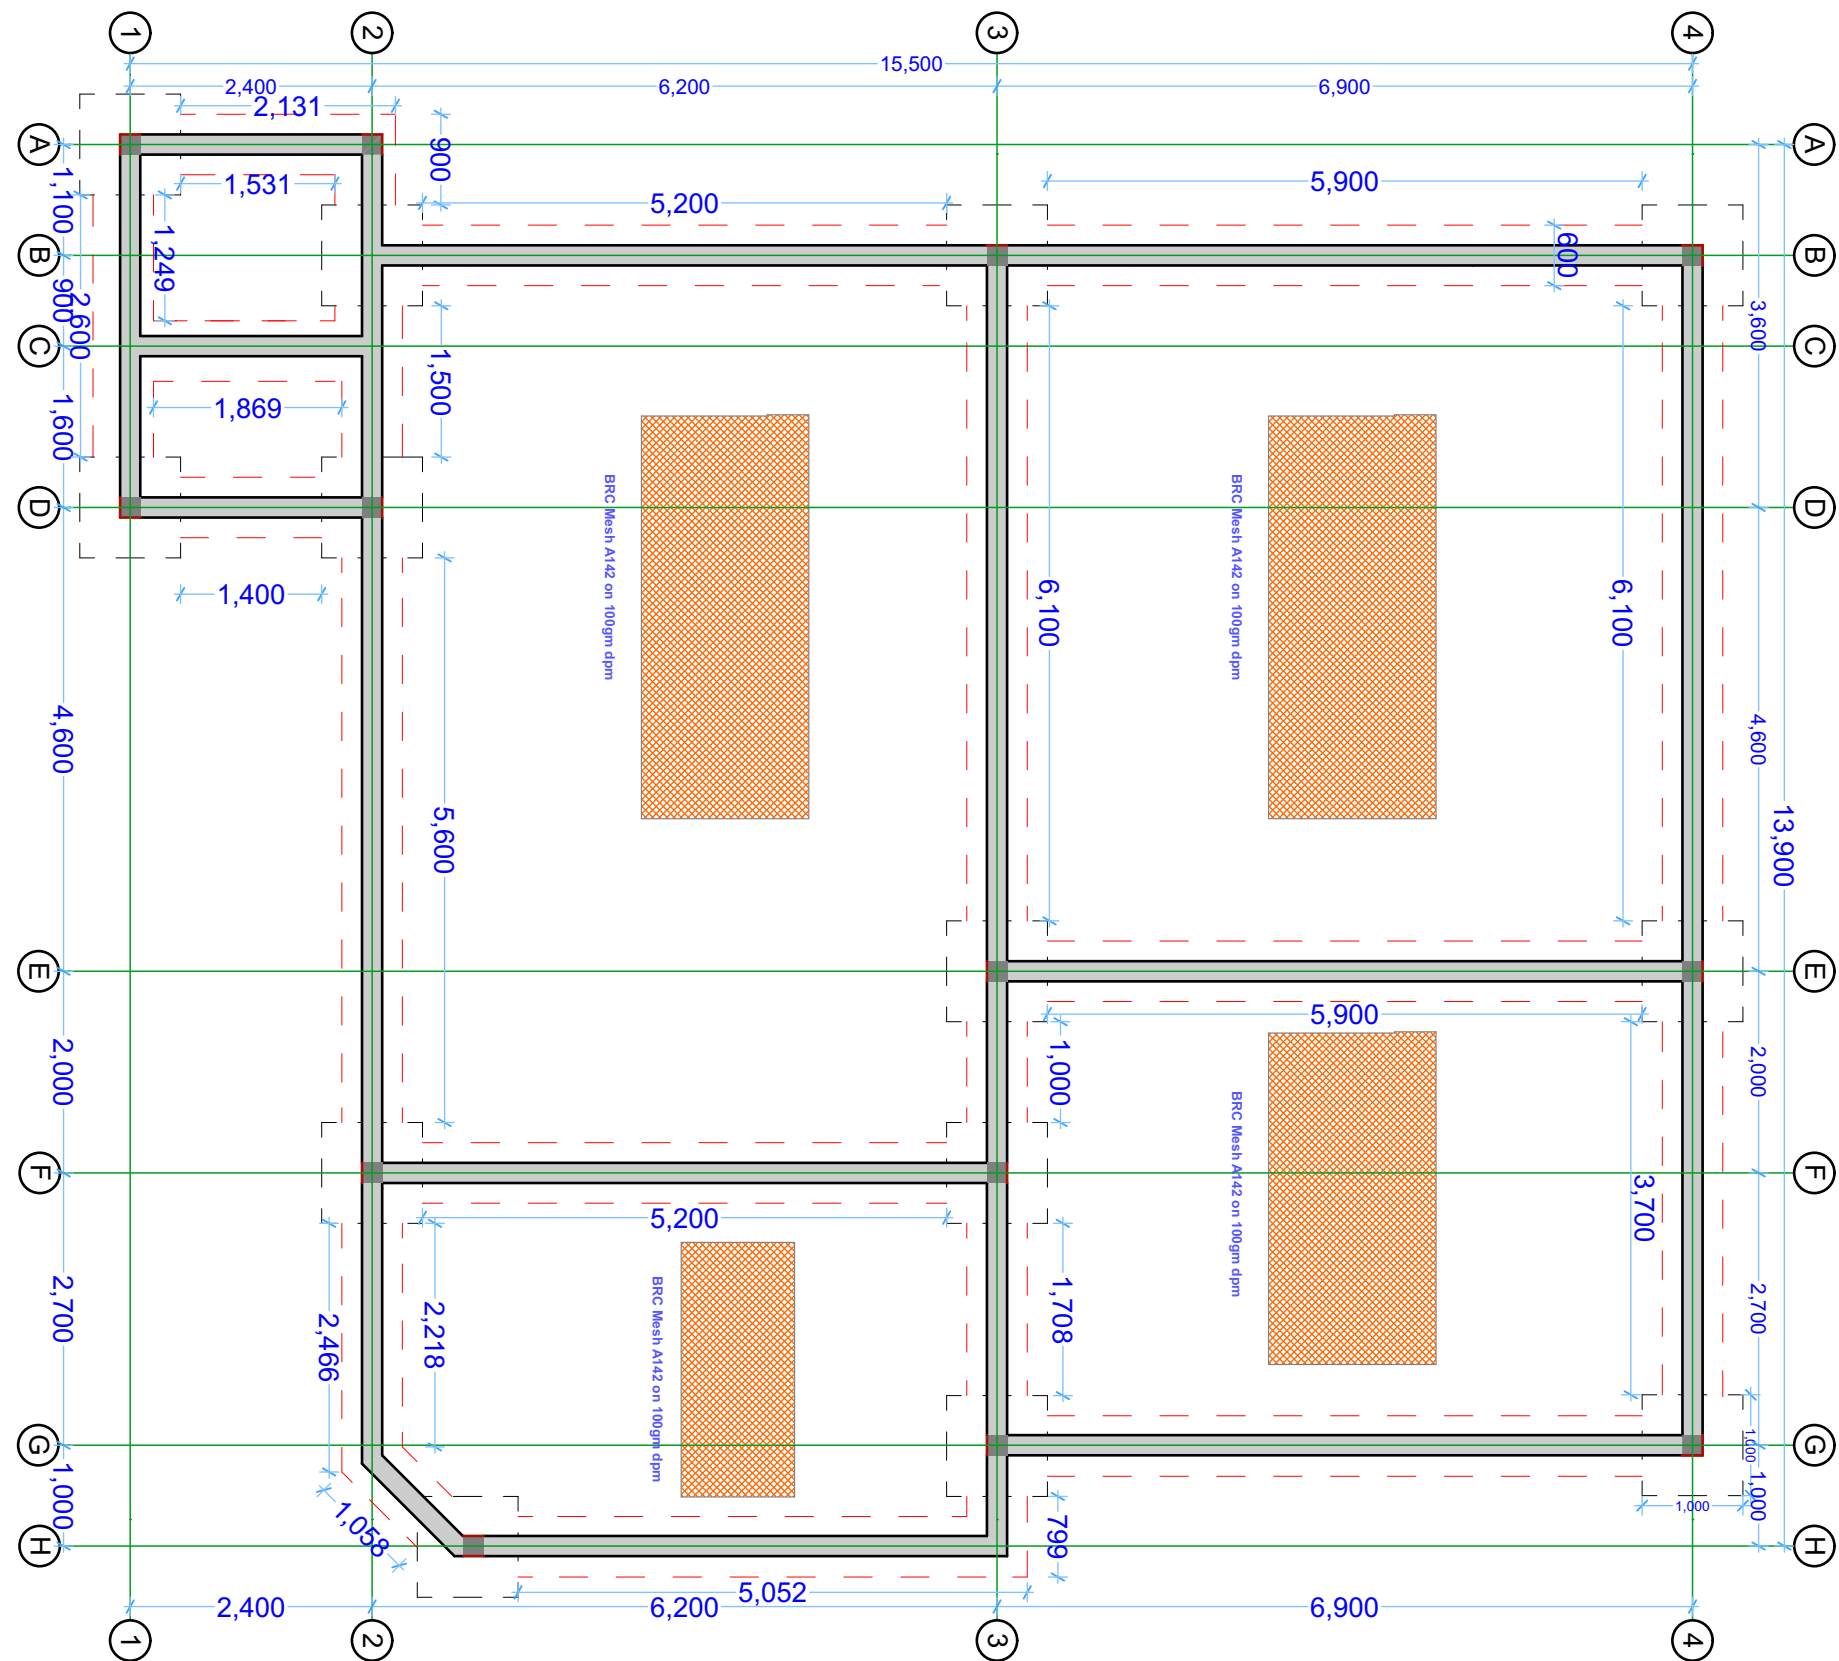




PROJECT TITLE:	DONOR:	DRAWING TITLE:	Drg No.	Sheet No. 1/10	 Somalia
GPE - ESPIG Construction Program, Somalia Construction of MoE Office Block	 	MOE office: 3D REF: E_MOE office	Scale: 1:100	Date: Sep. 2021	
			Design: Ainaanshe	Checked: HEK	



PROJECT TITLE:

GPE - ESPIG Construction Program,
Somalia
Construction of MoE Office Block

DONOR:



DRAWING TITLE:

MOE office: Foundation Layout

REF: E_MOE office

Drg No.

Scale: 1:100

Design: Ainaanshe


Sheet No. 2/10




Date: Sep. 2021


Checked: HEK



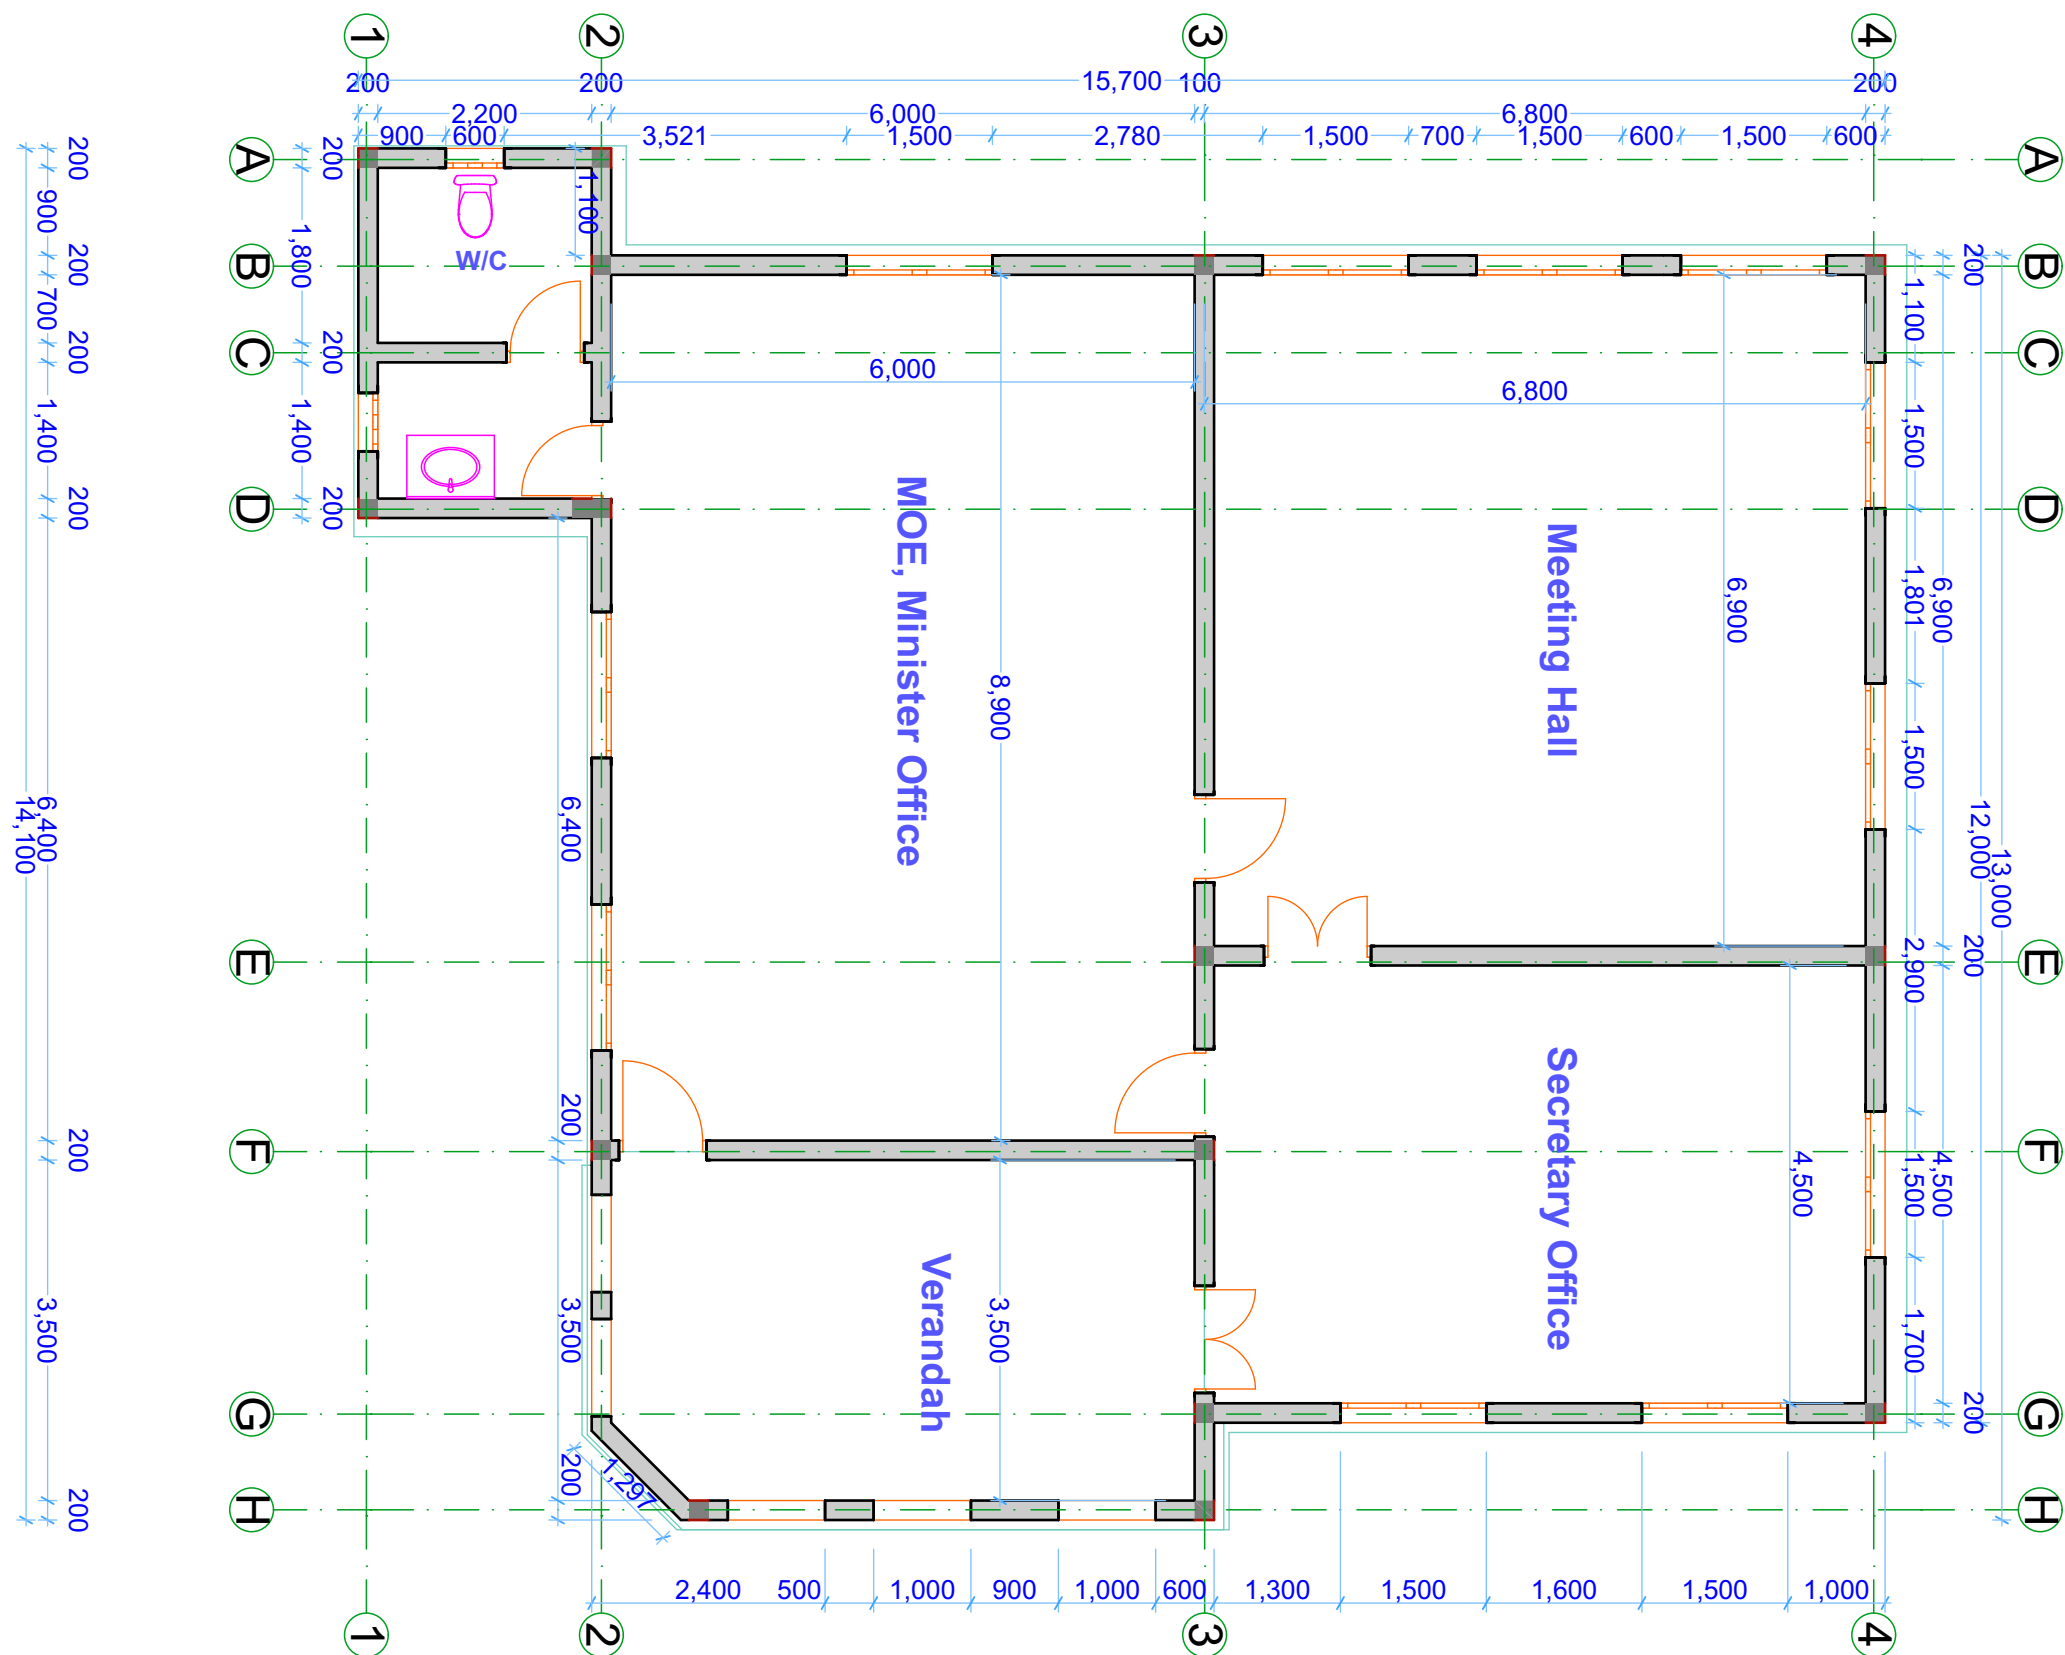


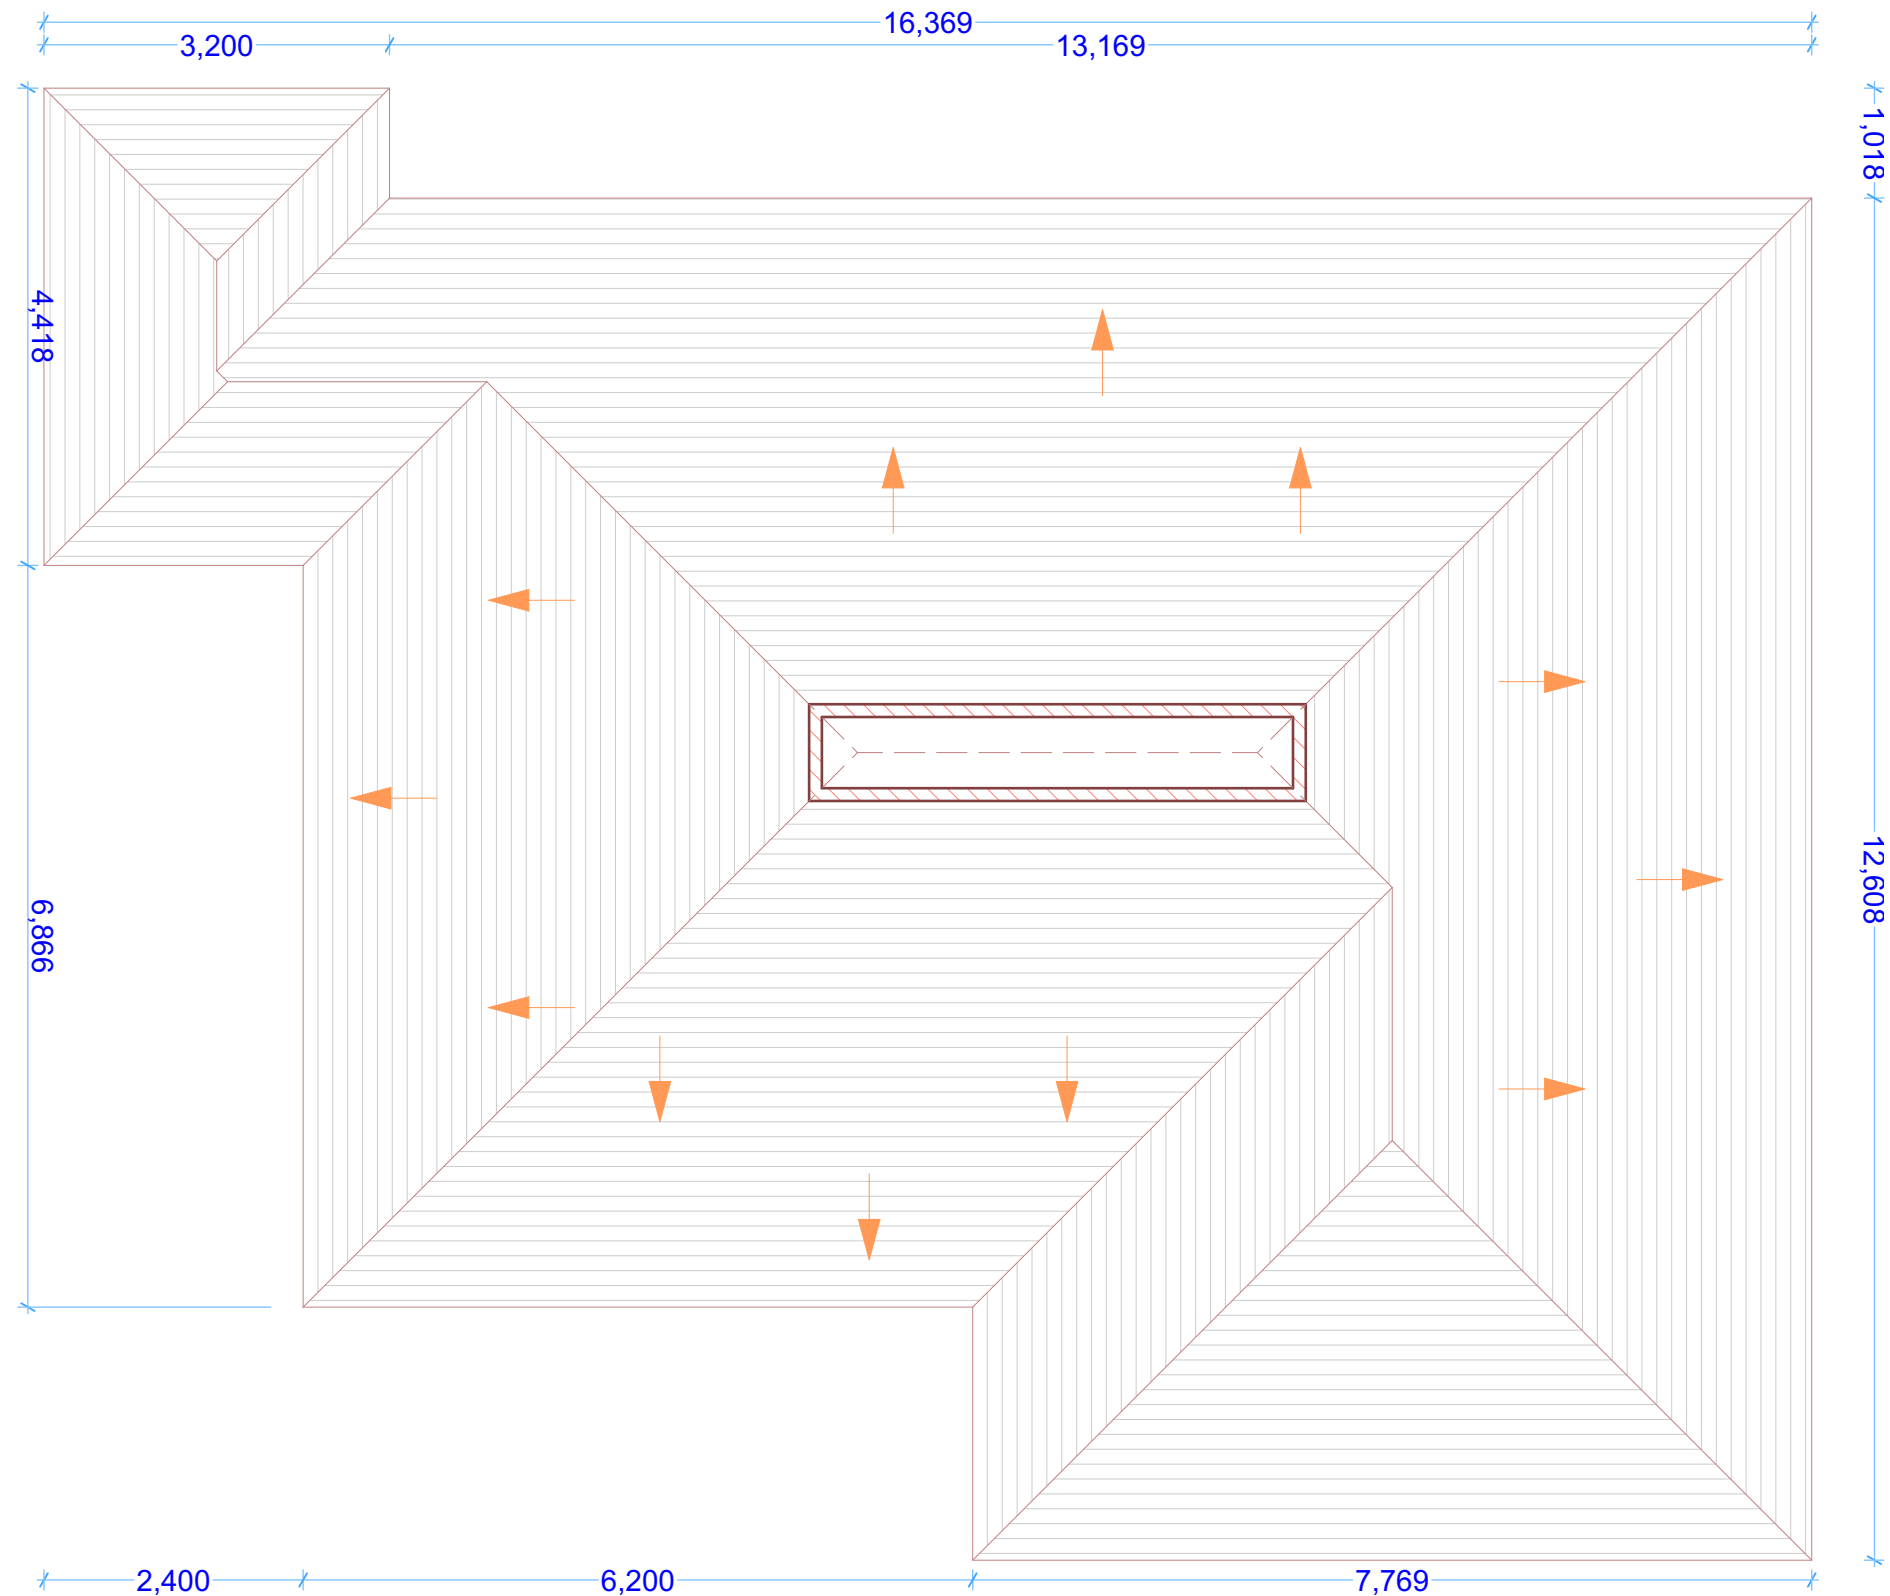
Somalia



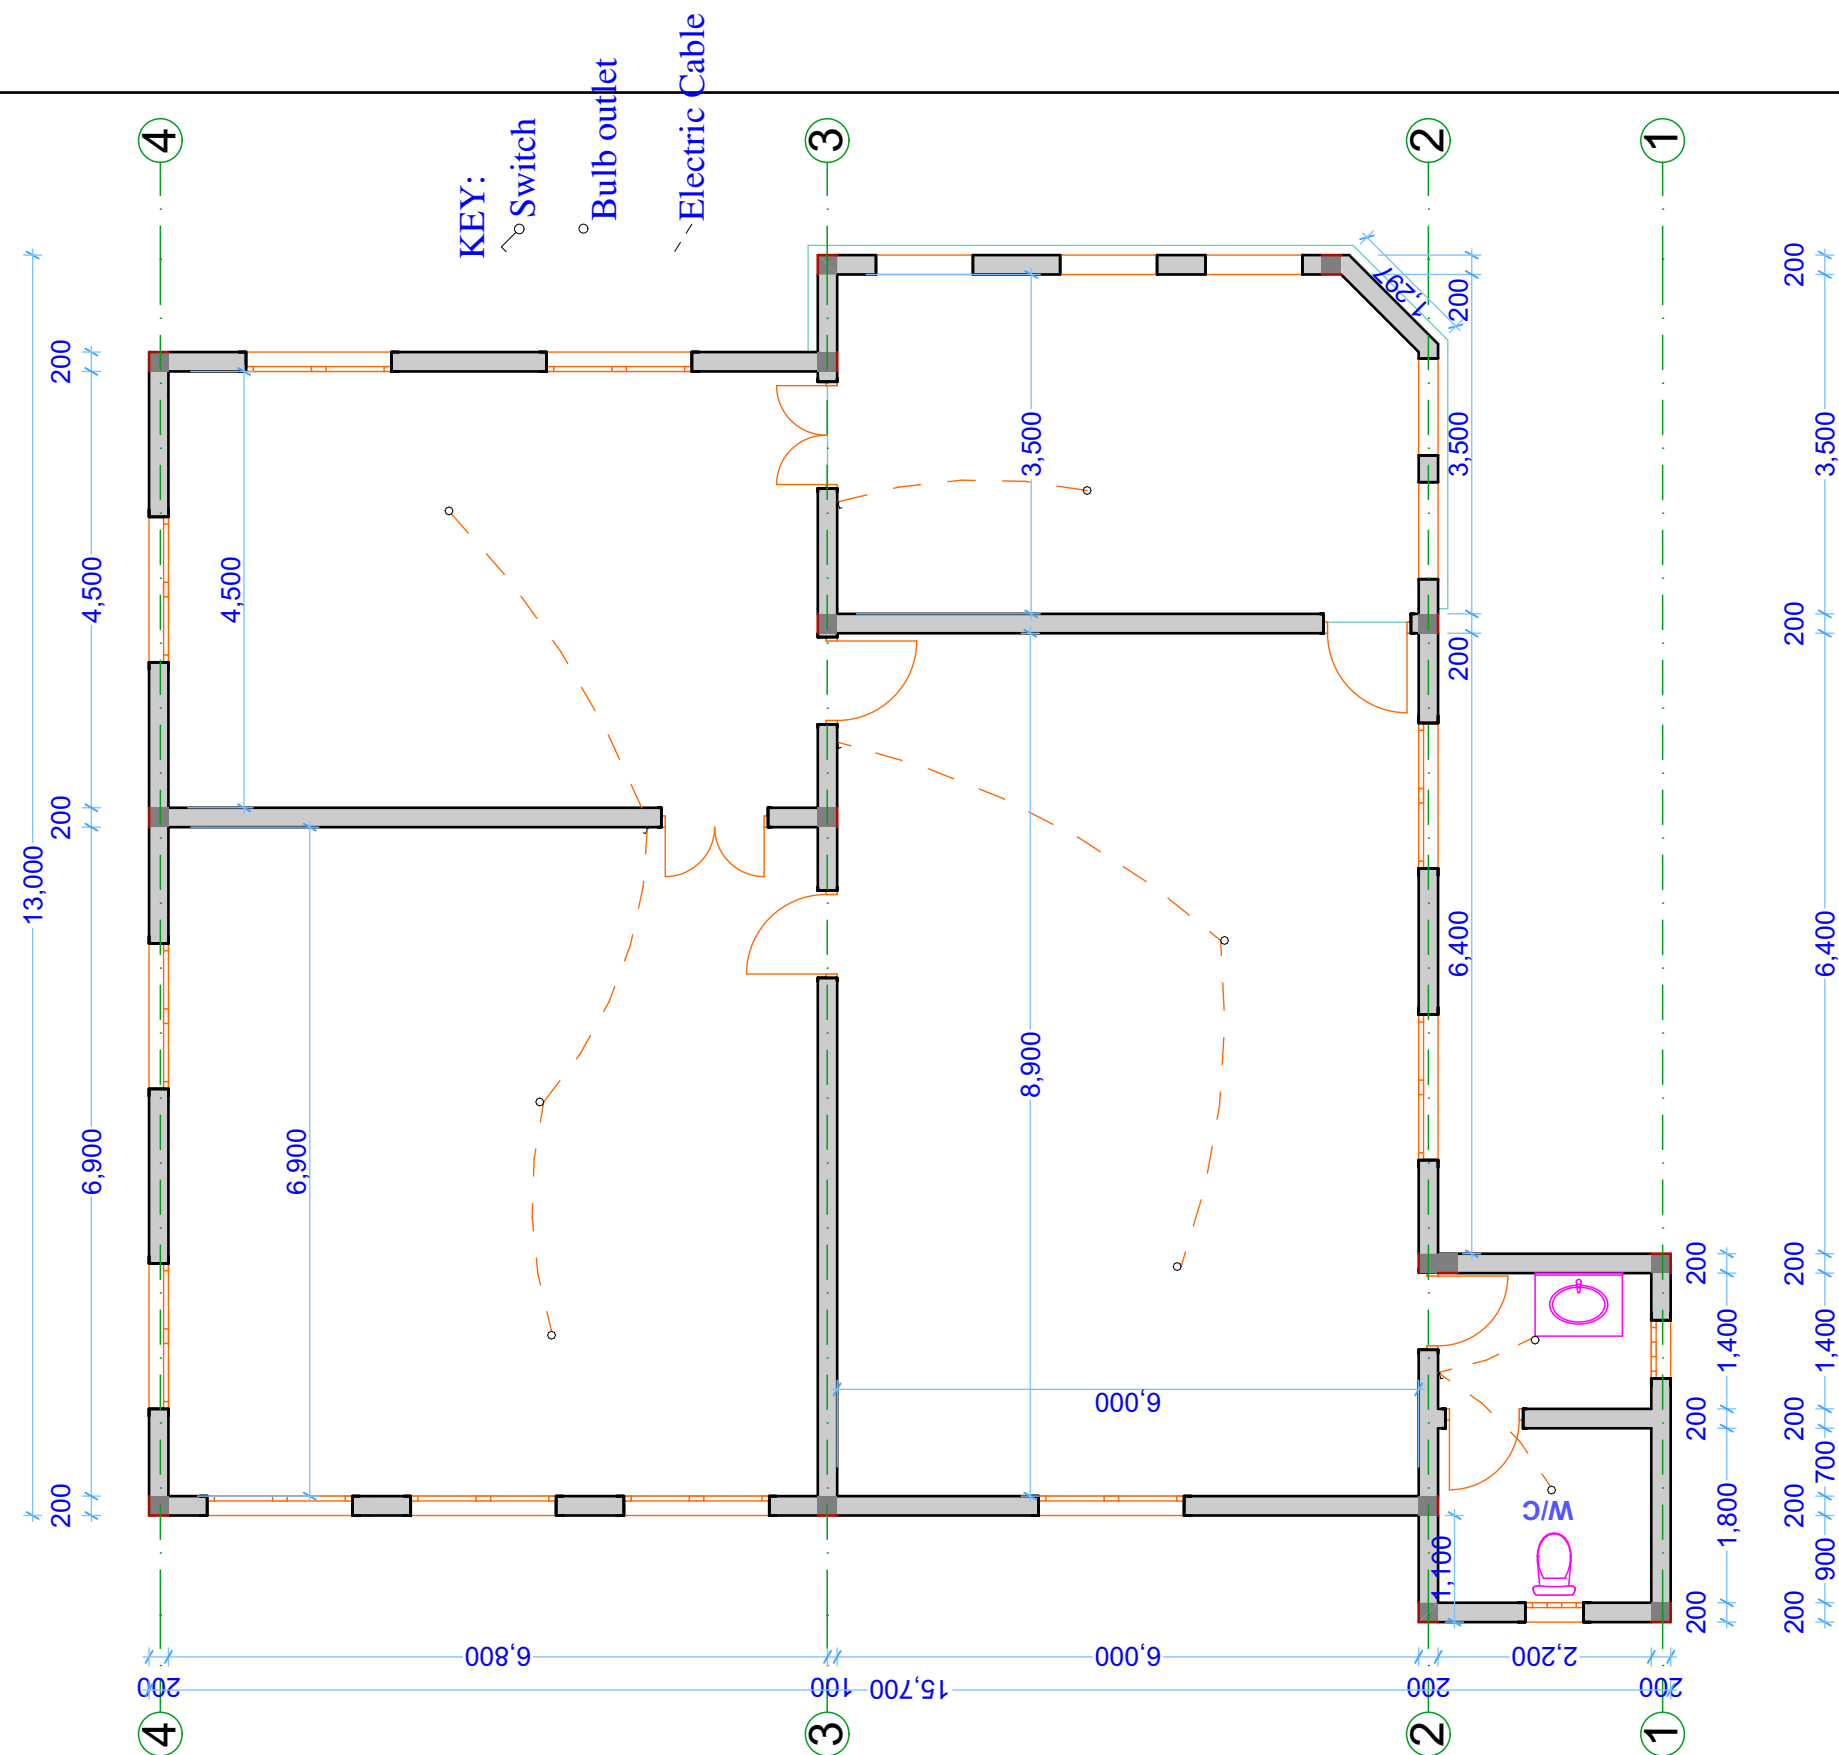


PROJECT TITLE:	DONOR:	DRAWING TITLE:	Drg No.	Sheet No. 3/10	 ENDING EXTREME POVERTY WHATEVER IT TAKES Somalia
GPE - ESPIG Construction Program, Somalia Construction of MoE Office Block	 	MOE office: Floor Plan	Scale: 1:100	Date: Sep. 2021	
		REF: E_MOE office	Design: Ainaanshe	Checked: HEK	








PROJECT TITLE:	DONOR:	DRAWING TITLE:	Drg No.	Sheet No. 4/10	 ENDING EXTREME POVERTY WHATEVER IT TAKES Somalia
GPE - ESPIG Construction Program, Somalia Construction of MoE Office Block	 	MOE office: Electrical plan	Scale: 1:100	Date: Sep. 2021	
		REF: E_MOE office	Design: Ainaanshe	Checked: HEK	

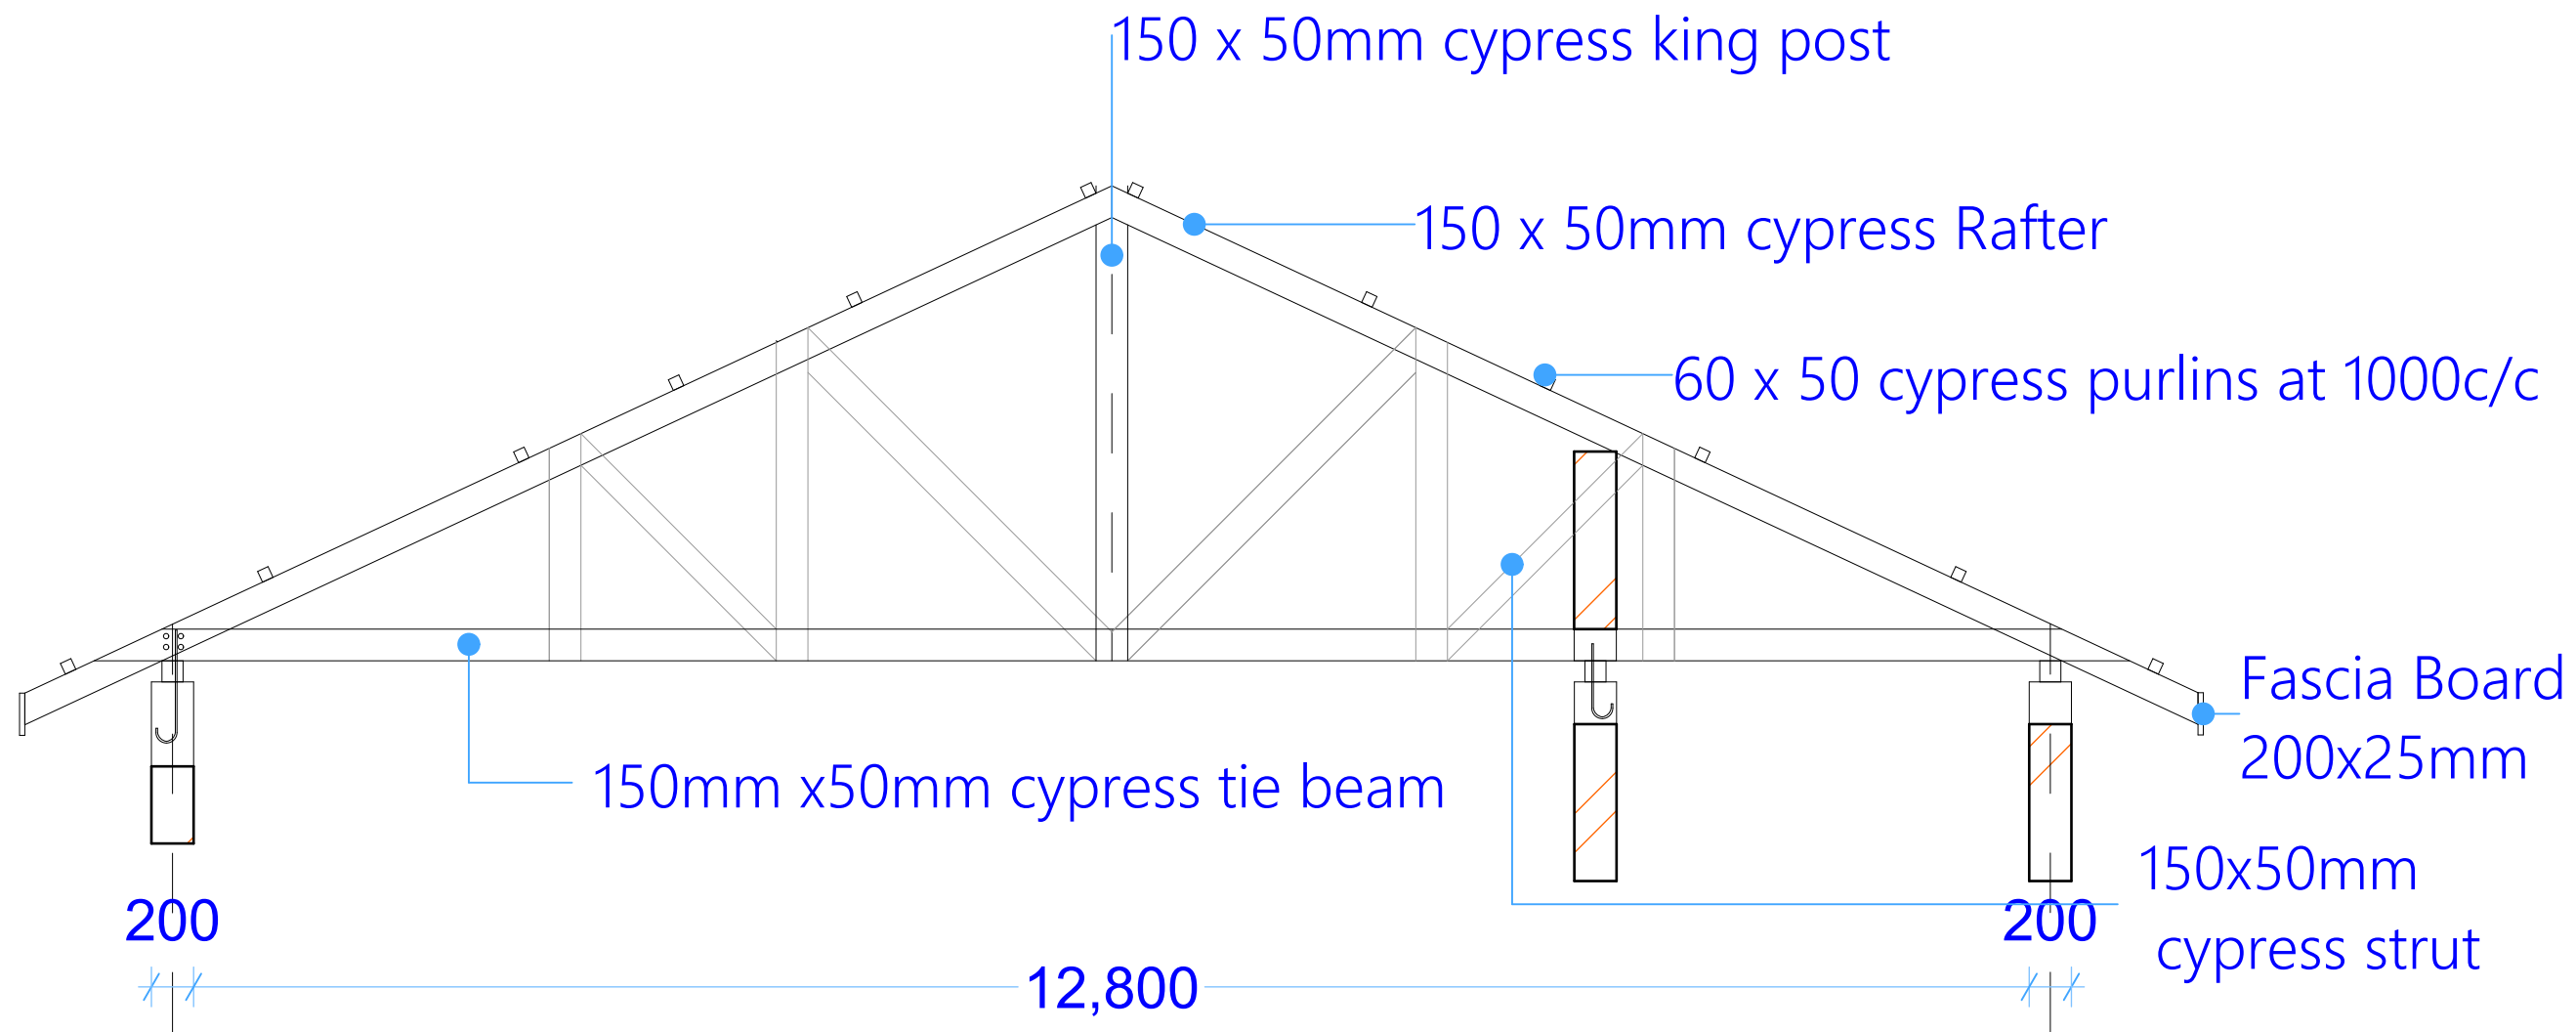




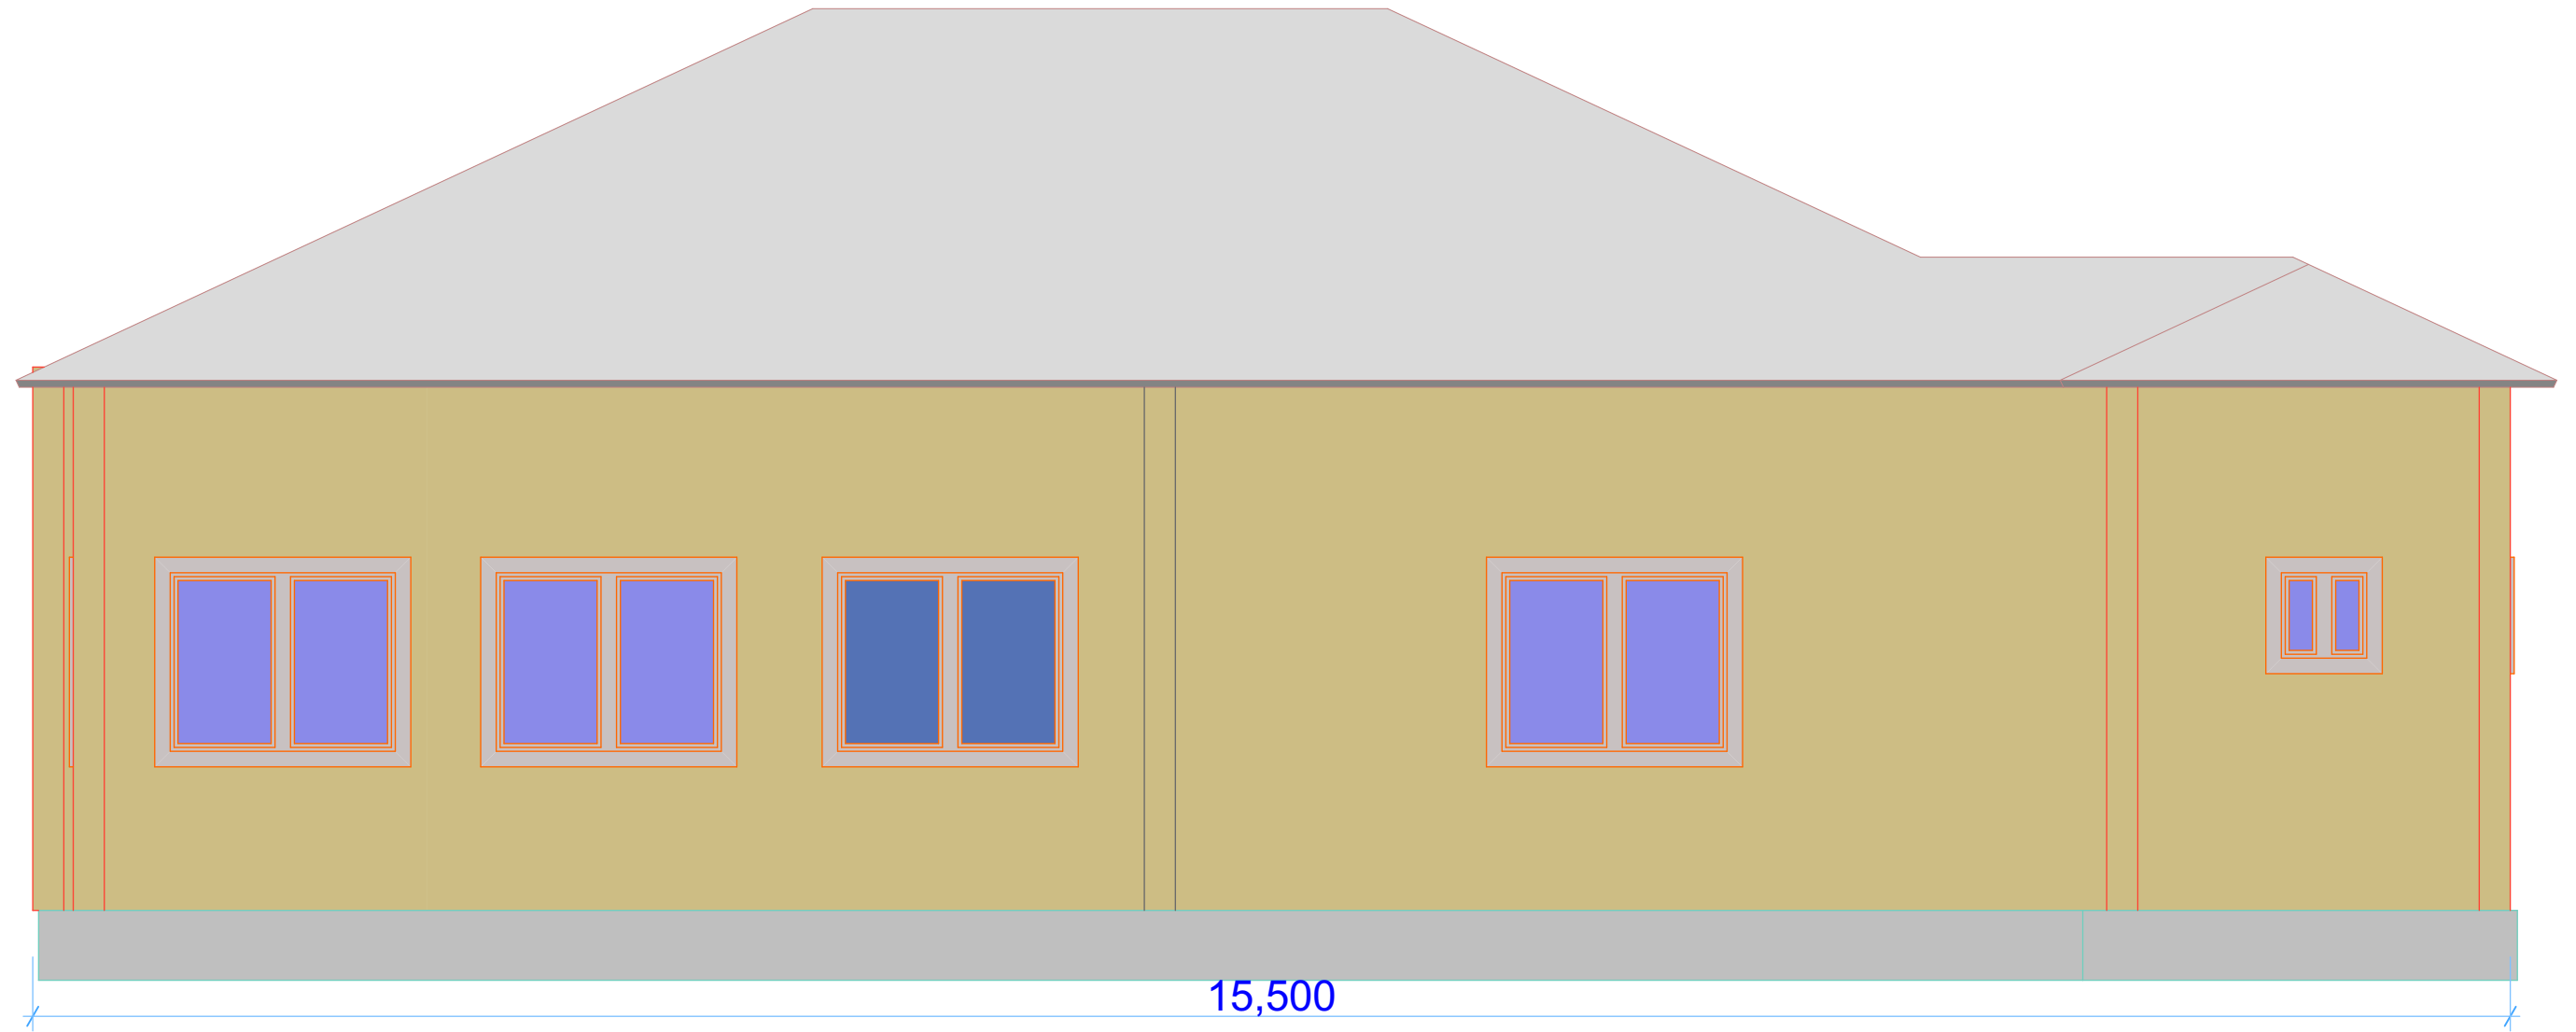
PROJECT TITLE:	DONOR:	DRAWING TITLE:	Drg No.	Sheet No. 5/10	<div>CONCERN worldwide</div> <div>ENDING EXTREME POVERTY WHATEVER IT TAKES</div> <div>Somalia</div>
GPE - ESPIG Construction Program, Somalia Construction of MoE Office Block	 	MoE office: Roof Plan REF: E_MOE office	Scale: 1:100	Date: Sep. 2021	
			Design: Ainaanshe	Checked: HEK	



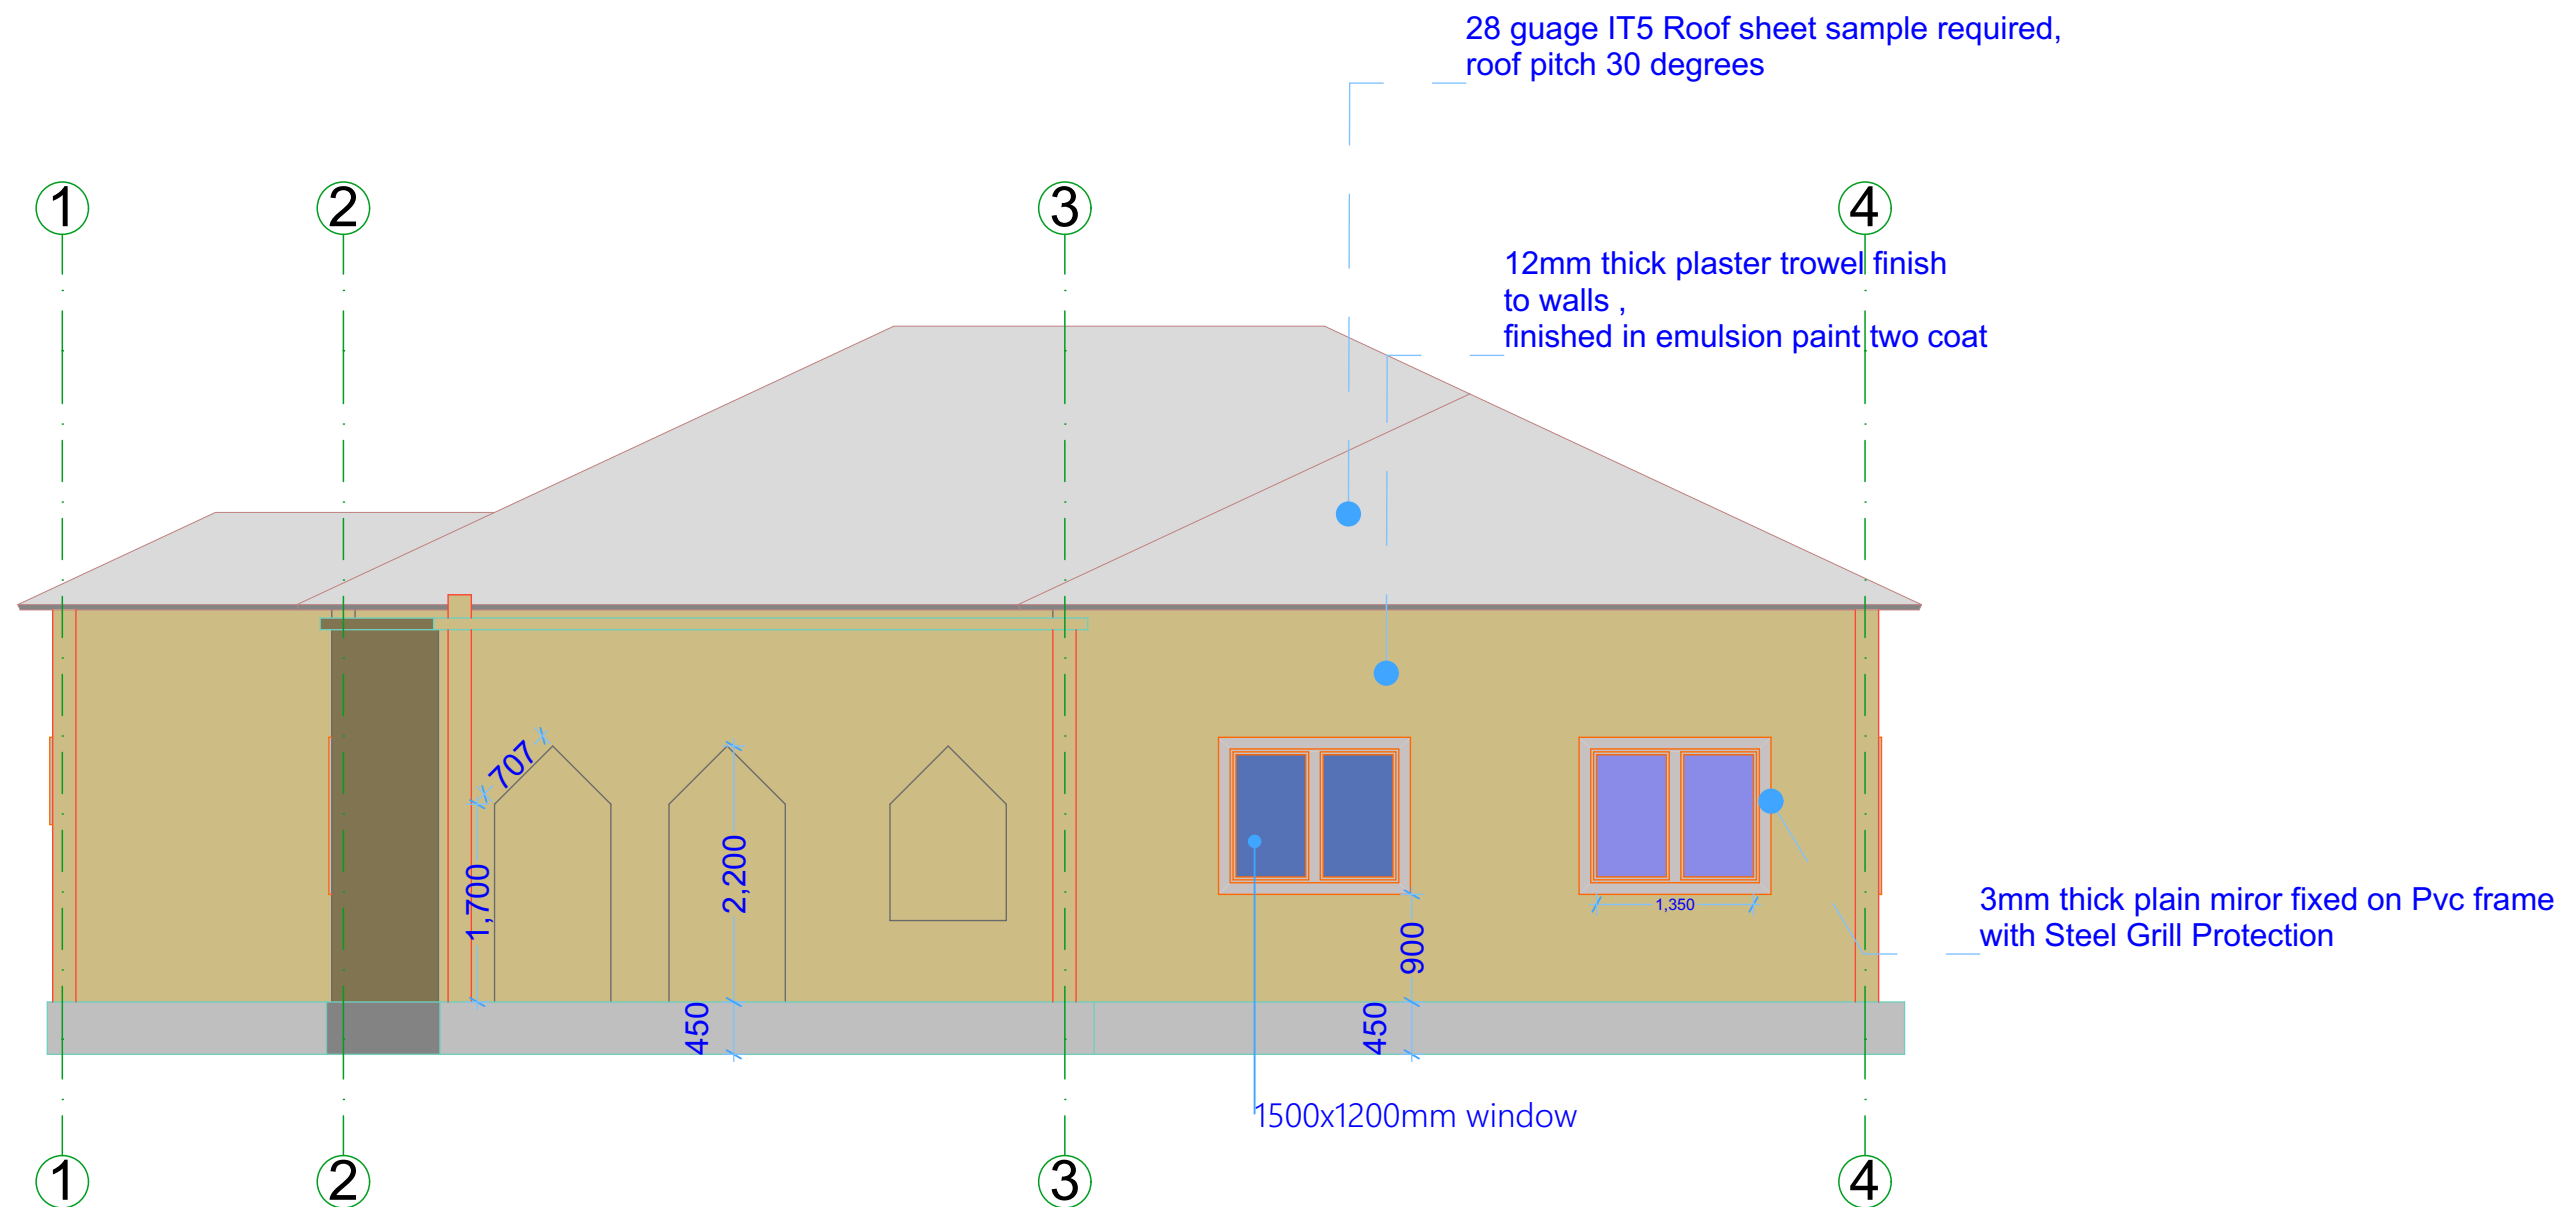


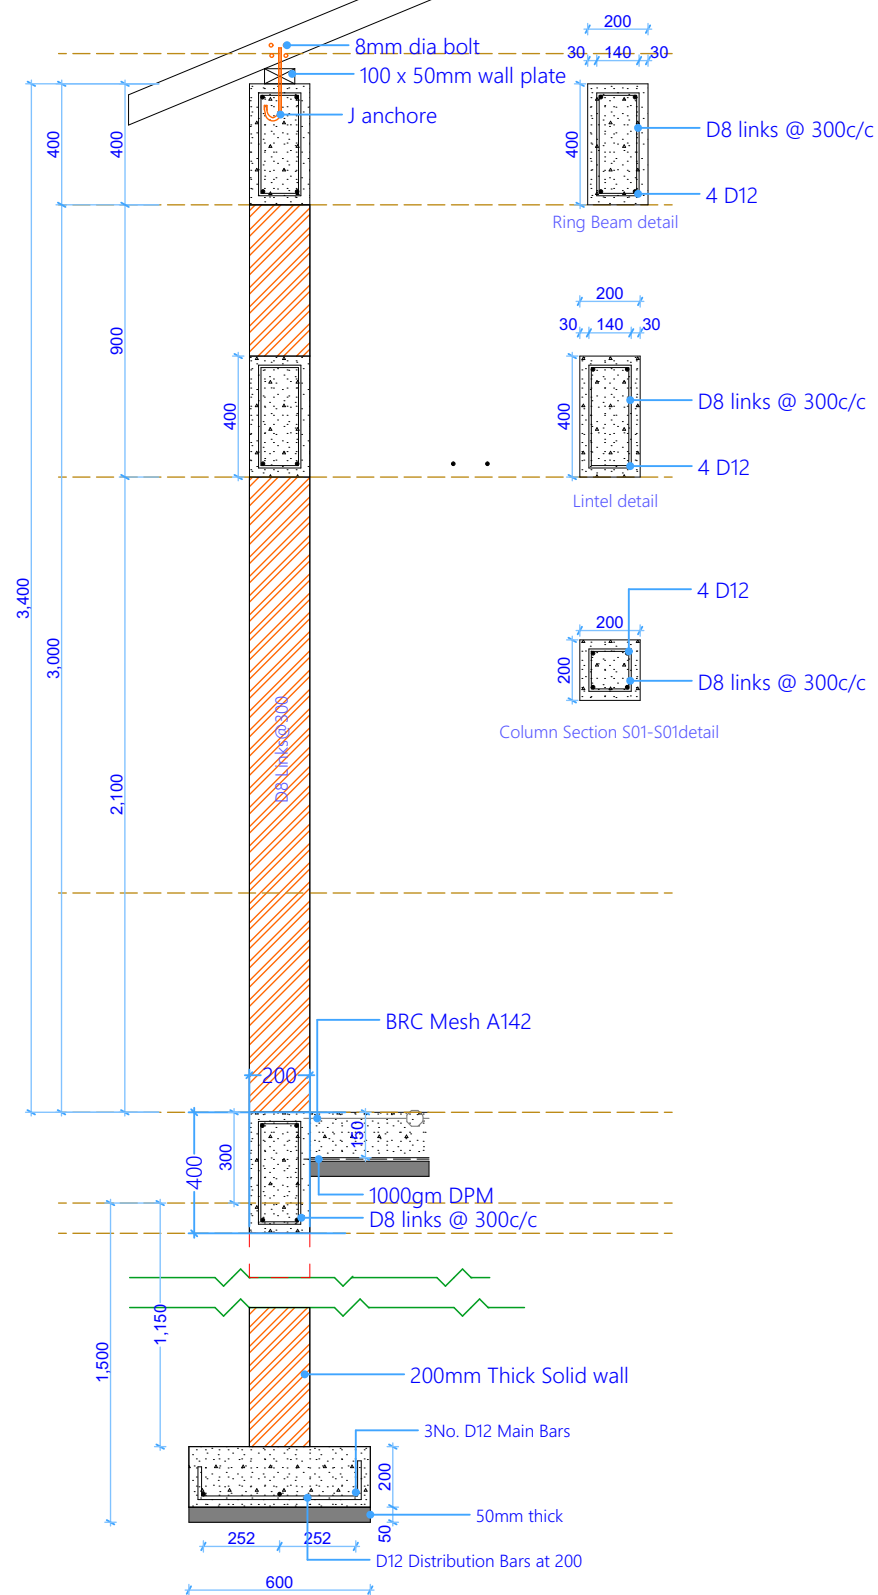
PROJECT TITLE:	DONOR:	DRAWING TITLE:	Drg No.	Sheet No. 6/10	  Somalia
GPE - ESPIG Construction Program, Somalia Construction of MoE Office Block	 	MOE office: Roof Section REF: E_MOE office	Scale: 1:100	Date: Sep. 2021	
			Design: Ainaanshe	Checked: HEK	




PROJECT TITLE:	DONOR:	DRAWING TITLE:	Drg No.	Sheet No. 7/10	 ENDING EXTREME POVERTY WHATEVER IT TAKES Somalia
GPE - ESPIG Construction Program, Somalia Construction of MoE Office Block	 	MOE office: Side Elevation REF: E_MOE office	Scale: 1:100	Date: Sep. 2021	
			Design: Ainaanshe	Checked: HEK	




PROJECT TITLE:	DONOR:	DRAWING TITLE:	Drg No.	Sheet No. 8/10	
GPE - ESPIG Construction Program, Somalia Construction of MoE Office Block	 	MOE office: End Elevation	Scale: 1:100	Date: Sep. 2021	
		REF: E_MOE office	Design: Ainaanshe	Checked: HEK	



Foundation Trench and wall - Section

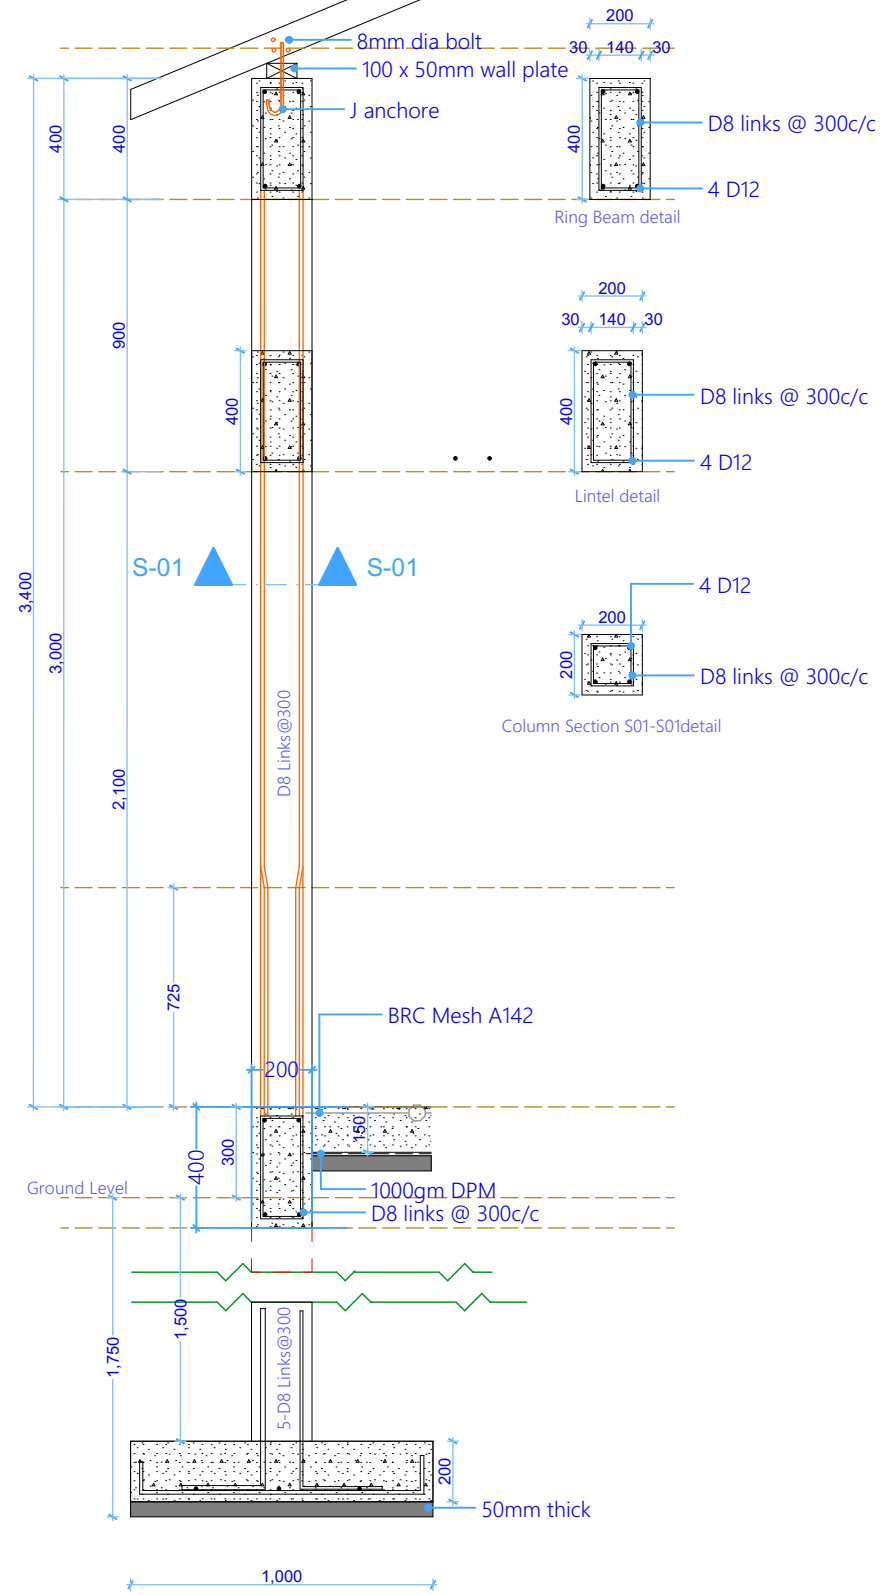

Foundation Column - Section

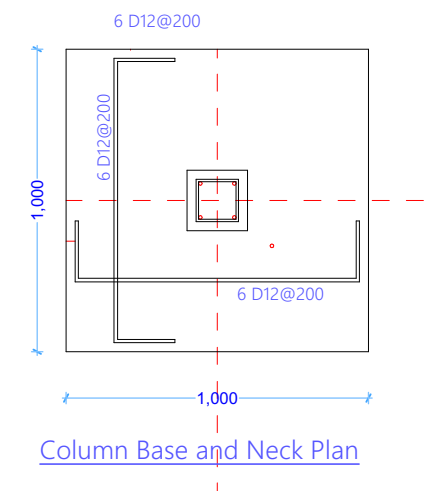

Column Base and Neck Plan

PROJECT TITLE:

GPE - ESPIG Construction Program,
Somalia
Construction of MoE Office Block

DONOR:



DRAWING TITLE:

MOE office: Column and Wall section
REF: E_MOE office

Drg No.

Scale: 1:100


Design: Ainaanshe



Sheet No. 9/10

Date: Sep. 2021

Checked: HEK

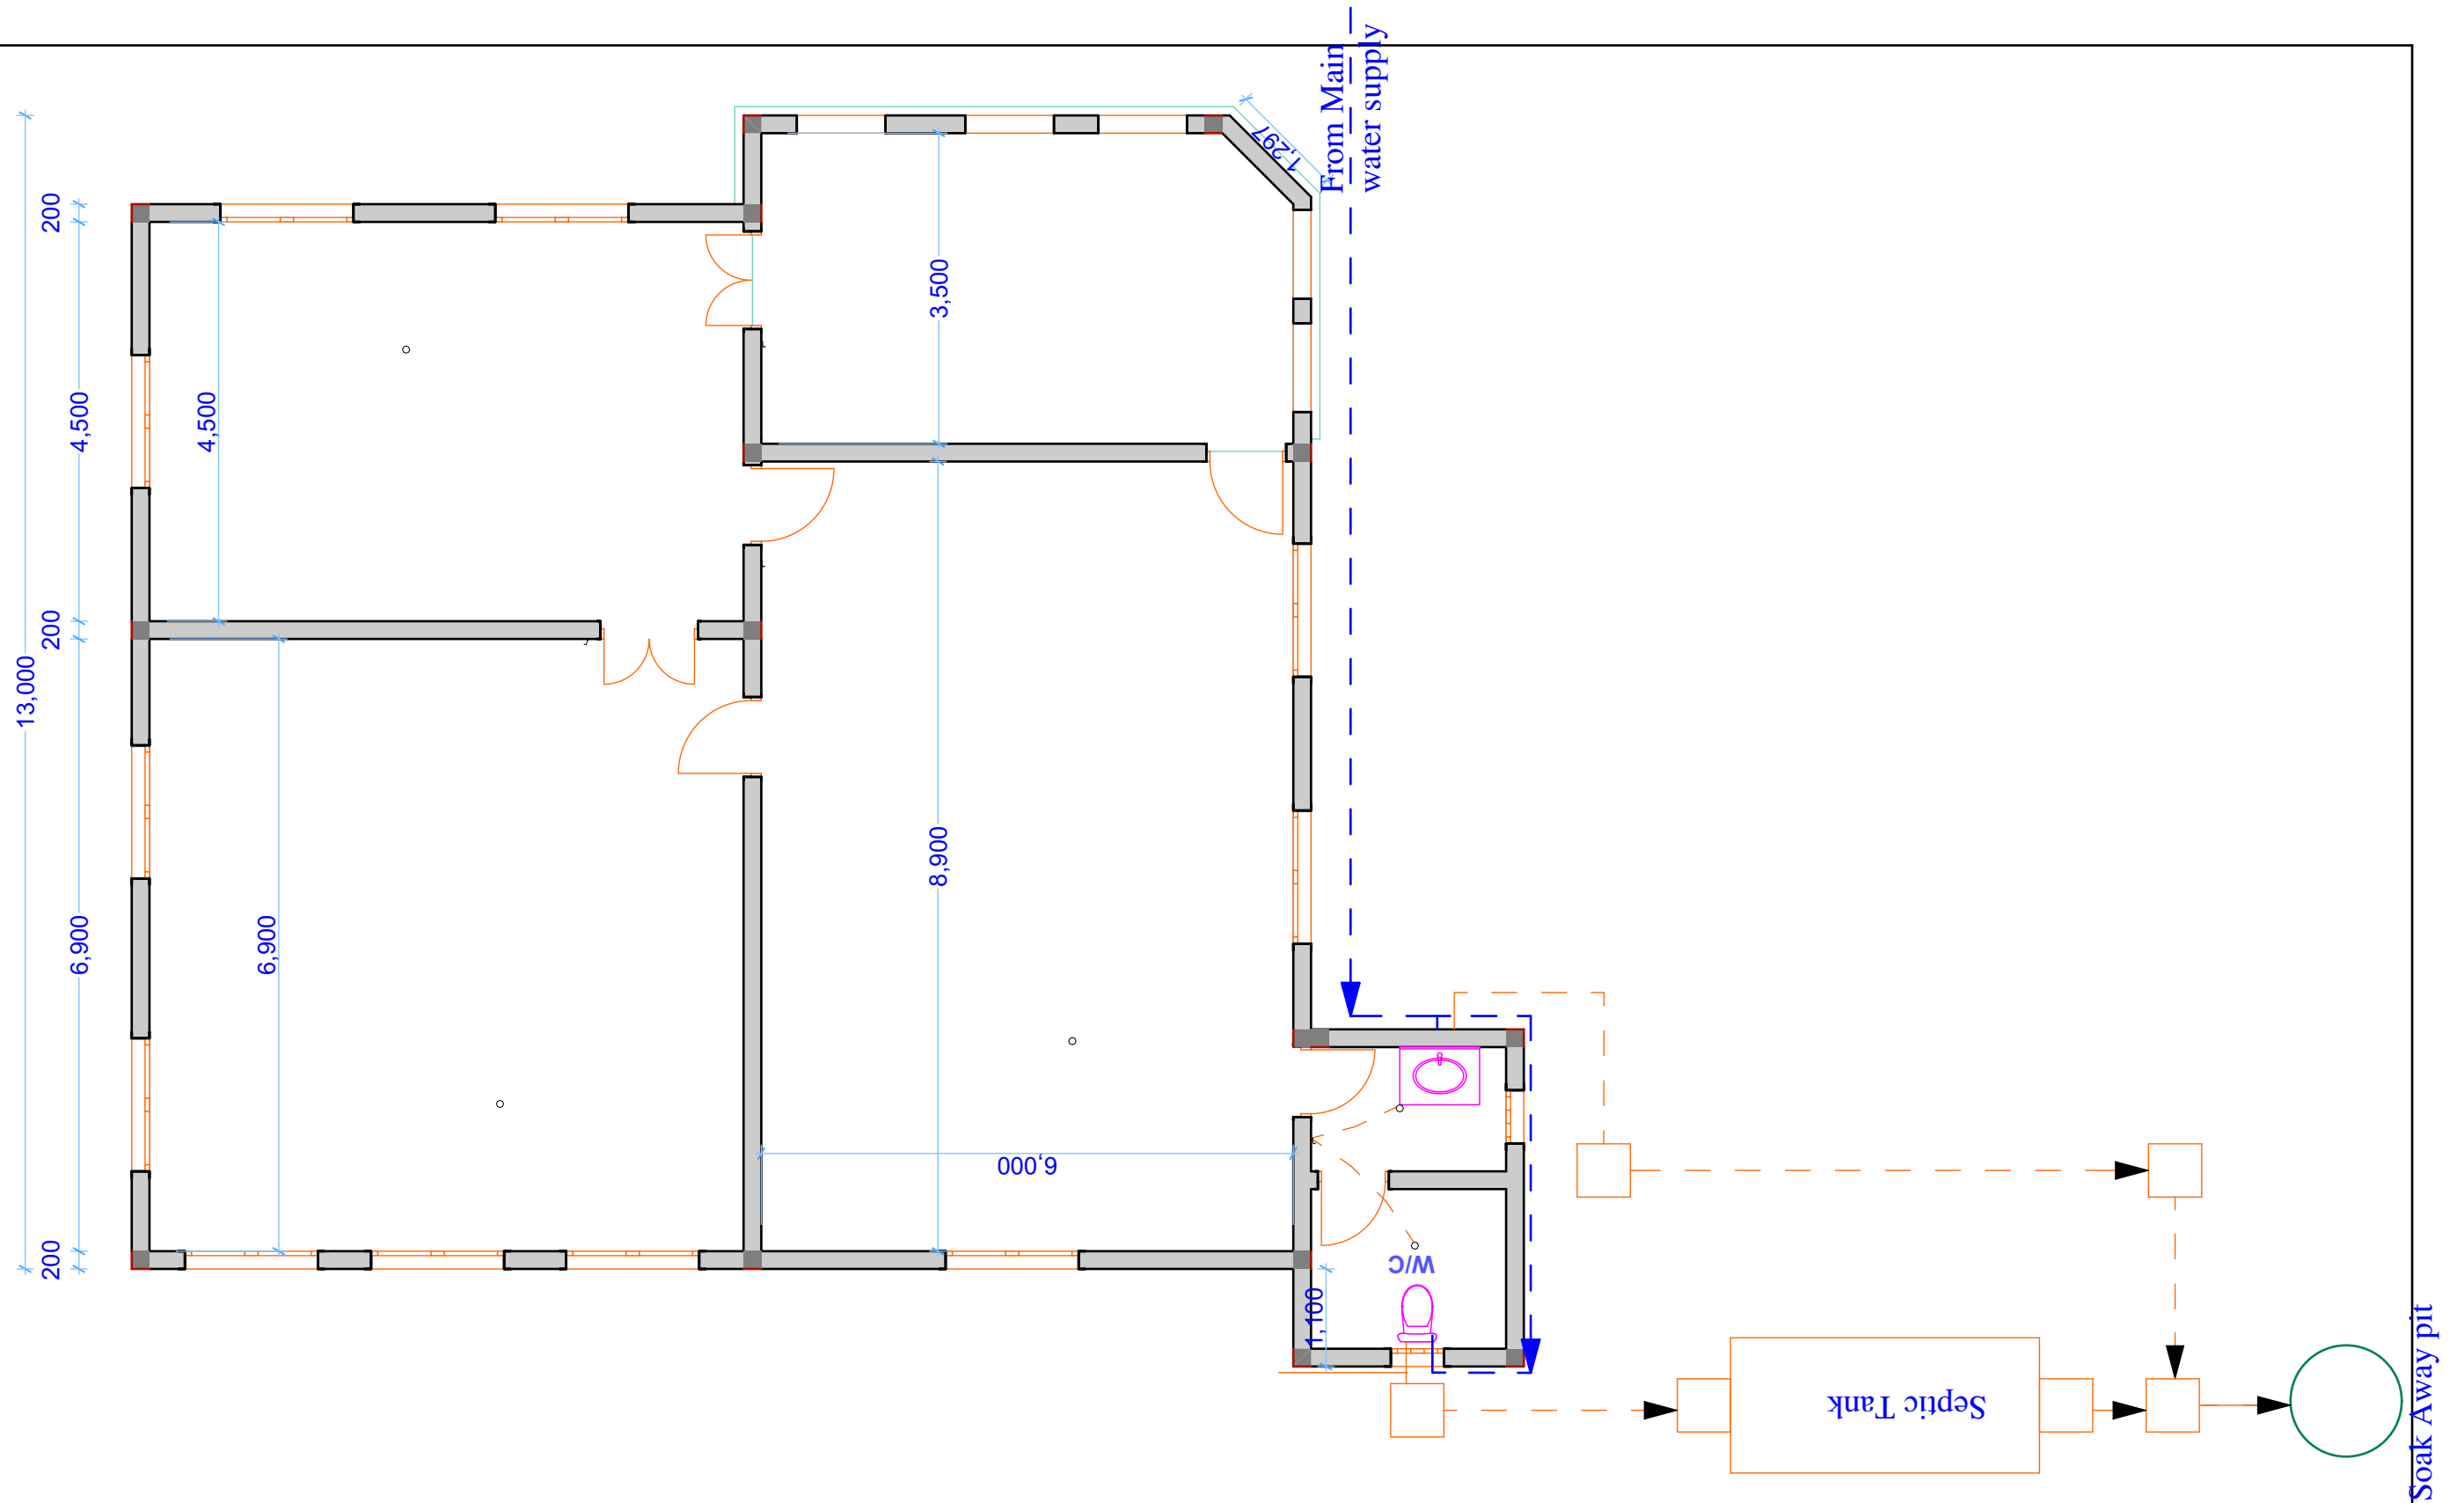CONCERN
worldwide
ENDING
EXTREME POVERTY
WHATEVER
IT TAKES
Somalia



PROJECT TITLE:	DONOR:	DRAWING TITLE:	Drg No.	Sheet No. 10/10	<div>CONCERN worldwide</div> <div>ENDING EXTREME POVERTY WHATEVER IT TAKES</div> <div>Somalia</div>
GPE - ESPIG Construction Program, Somalia Construction of MoE Office Block	 	Drainage Plan REF: E_MOE office	Scale: 1:100	Date: Sep. 2021	
			Design: Ainaanshe	Checked: HEK	