

 
 








PROJECT TITLE:	DONOR:	DRAWING TITLE:	Project No.	Sheet No. 1/10	  Somalia
JUBALAND TTI in Kismayo Jubaland State, Gedo Region, Somalia	 	10CM Elevated Tank: Foundation and Square Beam Layout Plan REF: JUBALAND TTI_S_10CM ELEVATED TANK	Scale: 1:100	Date: Oct 2021	
			Design: H.E.	Checked:	

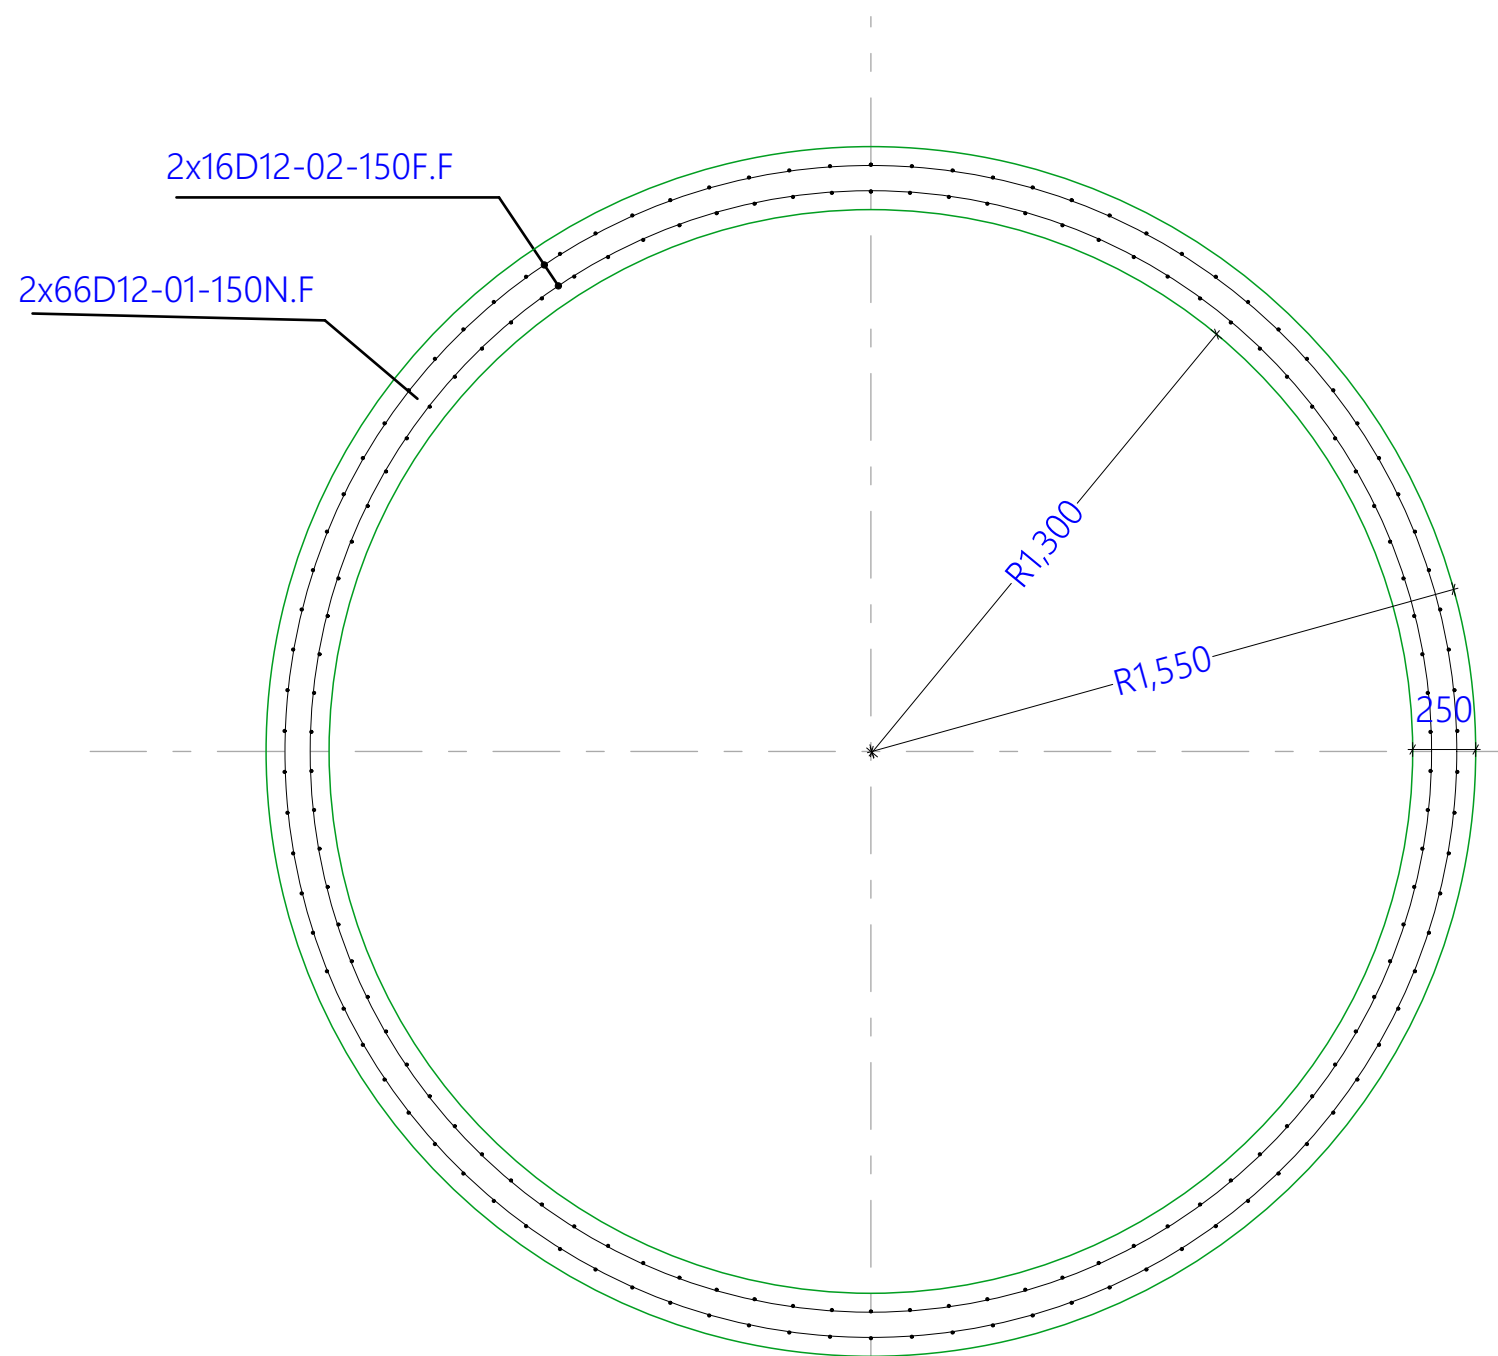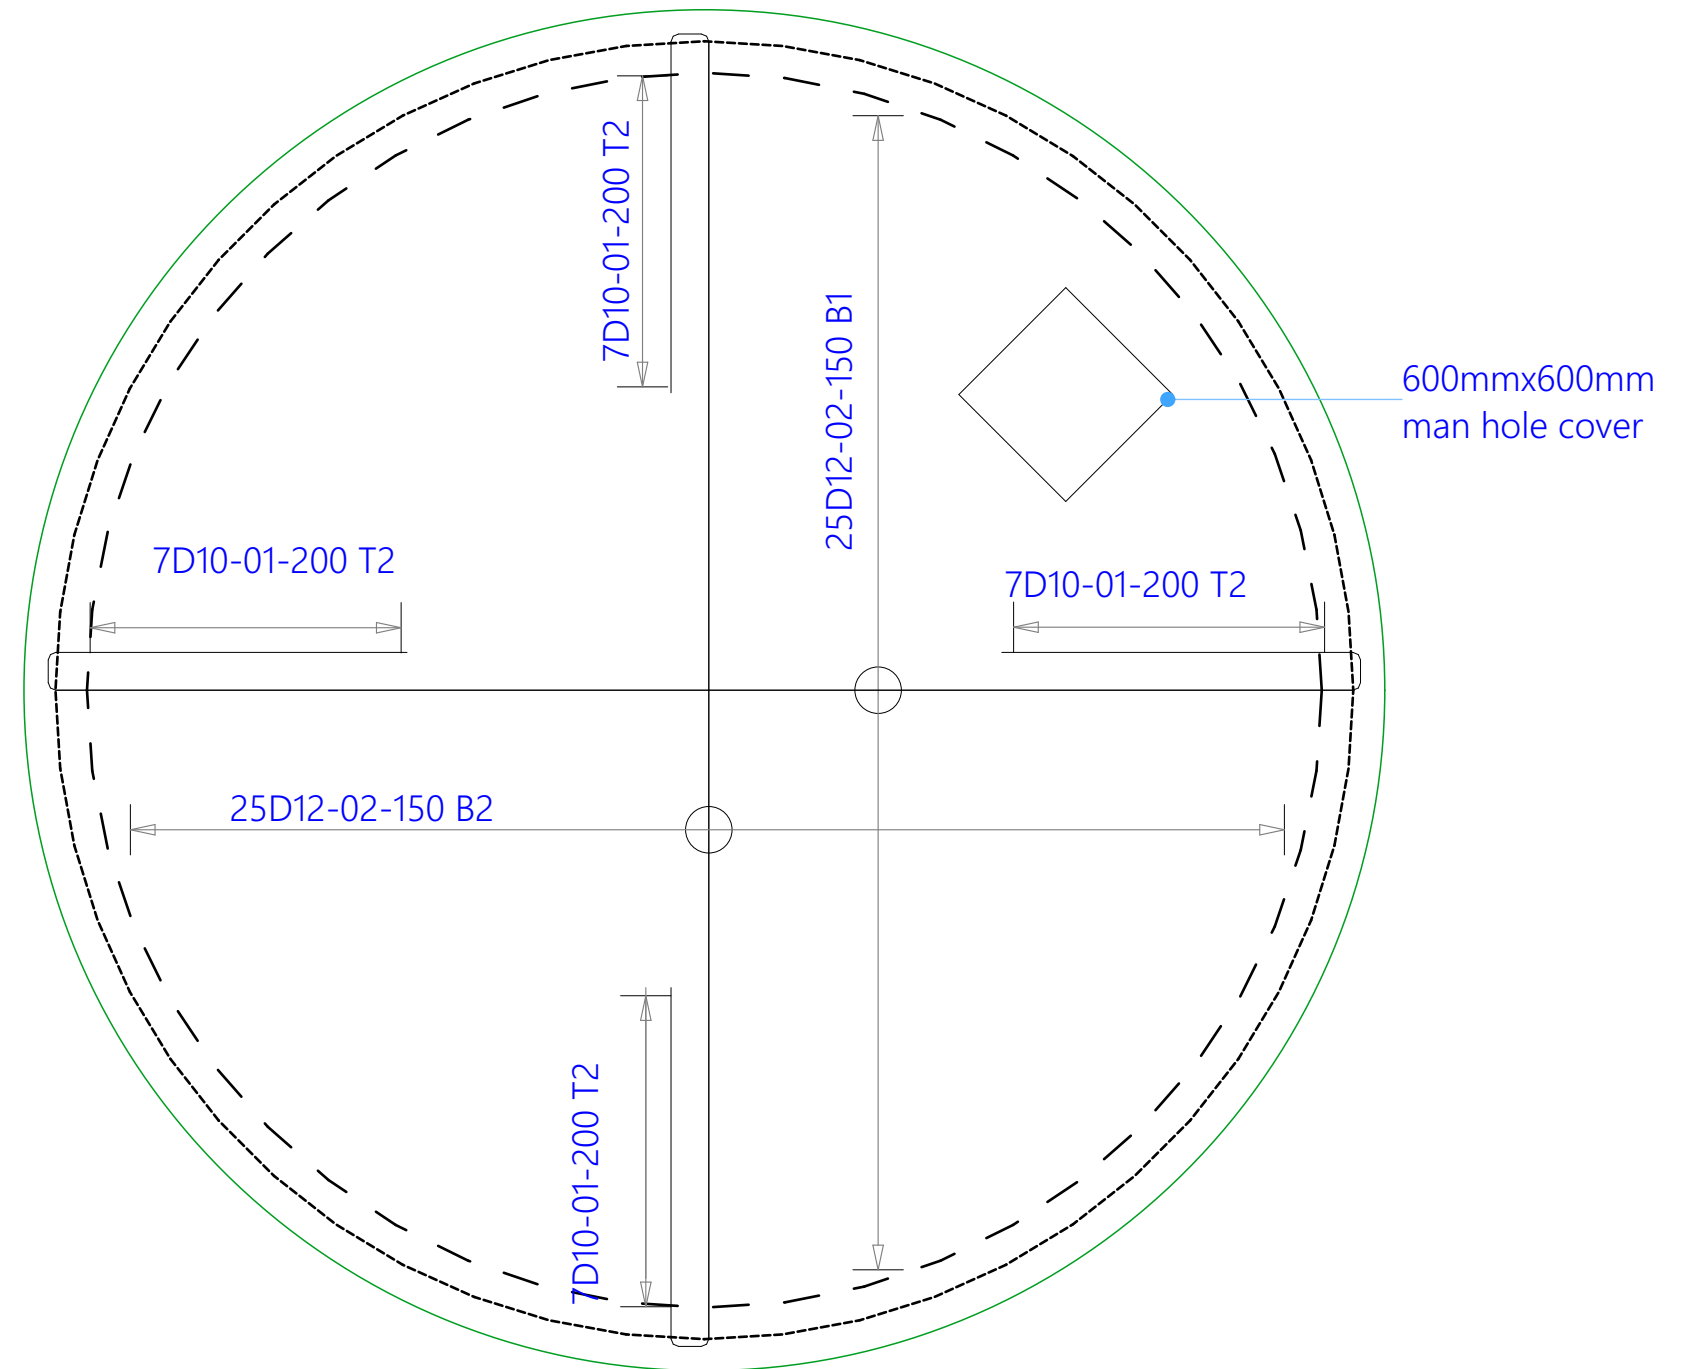


TANK WALL REINFORCEMENT DETAIL
SCALE 1:50






TOP SLAB REINFORCEMENT DETAILS
SCALE 1:50

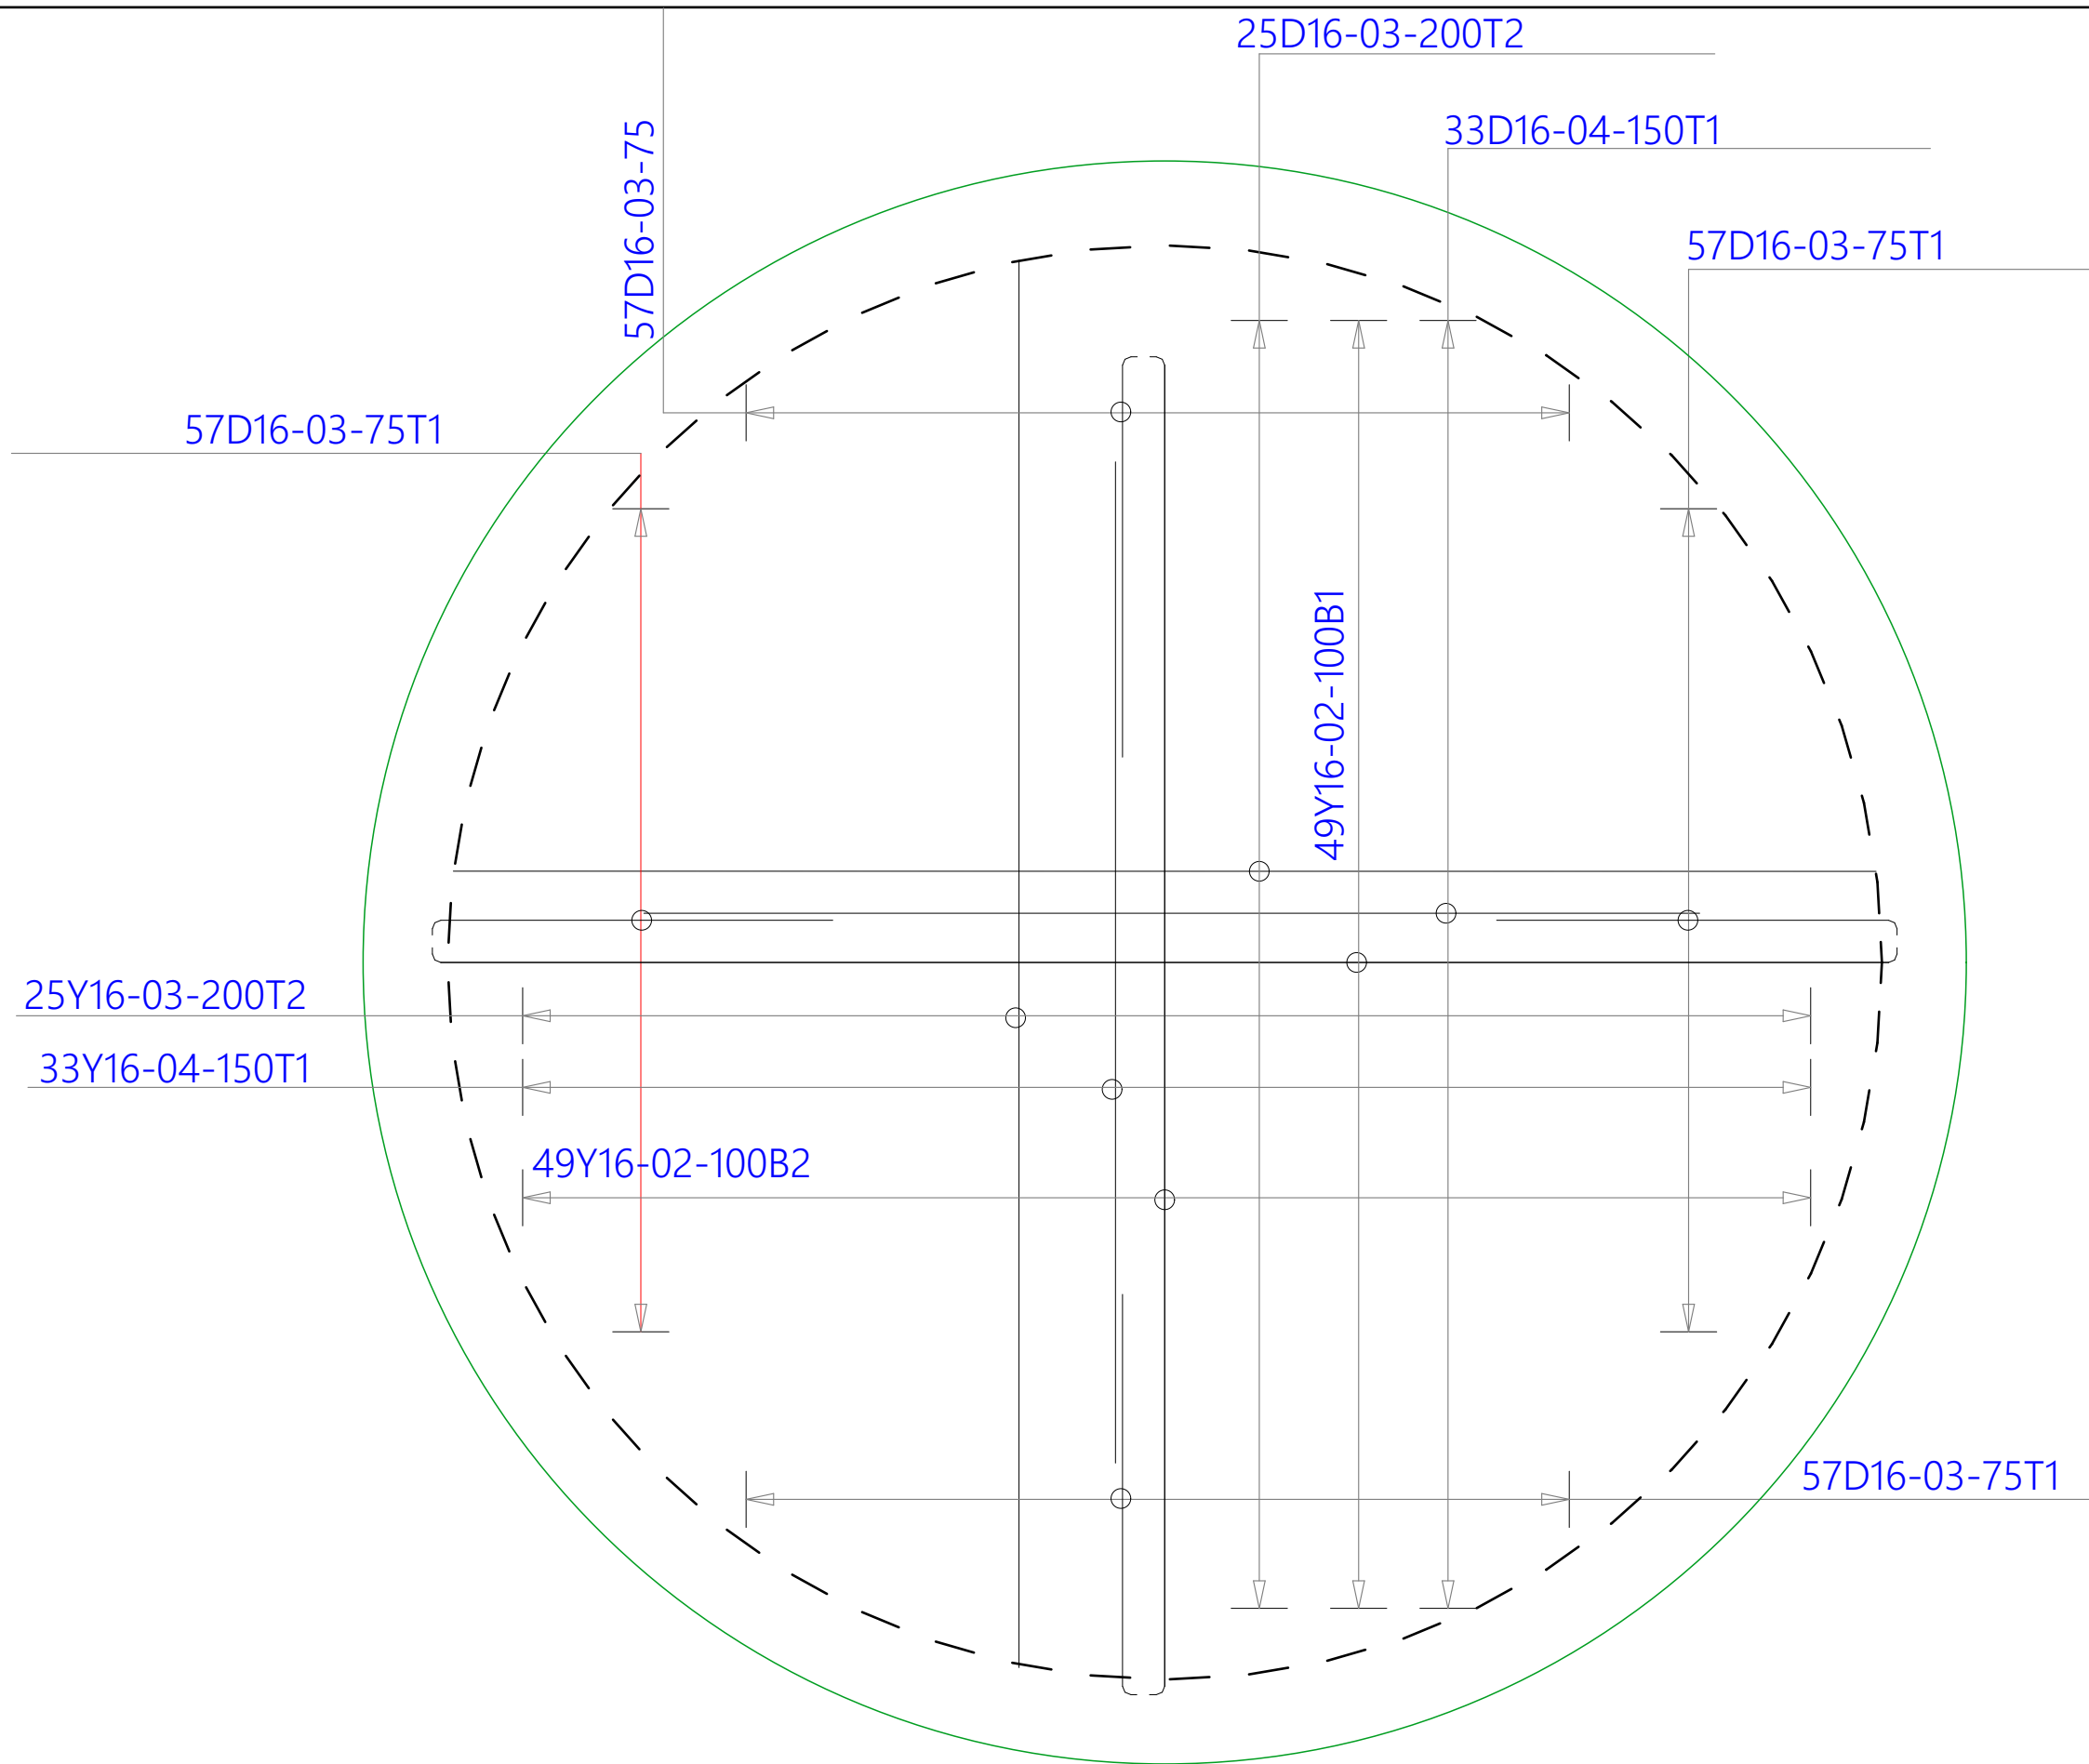
PROJECT TITLE:	DONOR:	DRAWING TITLE:	Project No.	Sheet No. 2/10	  Somalia
JUBALAND TTI in Kismayo Jubaland State, Gedo Region, Somalia	 	10CM Elevated Tank: Tank Wall and Top Slab Reinforcement Details REF: JUBALAND TTI_S_10CM ELEVATED TANK	Scale: 1:100	Date: Oct 2021	
			Design: H.E.	Checked:	



BOTTOM SLAB REINFORCEMENT DEATAILS



SCALE 1:50

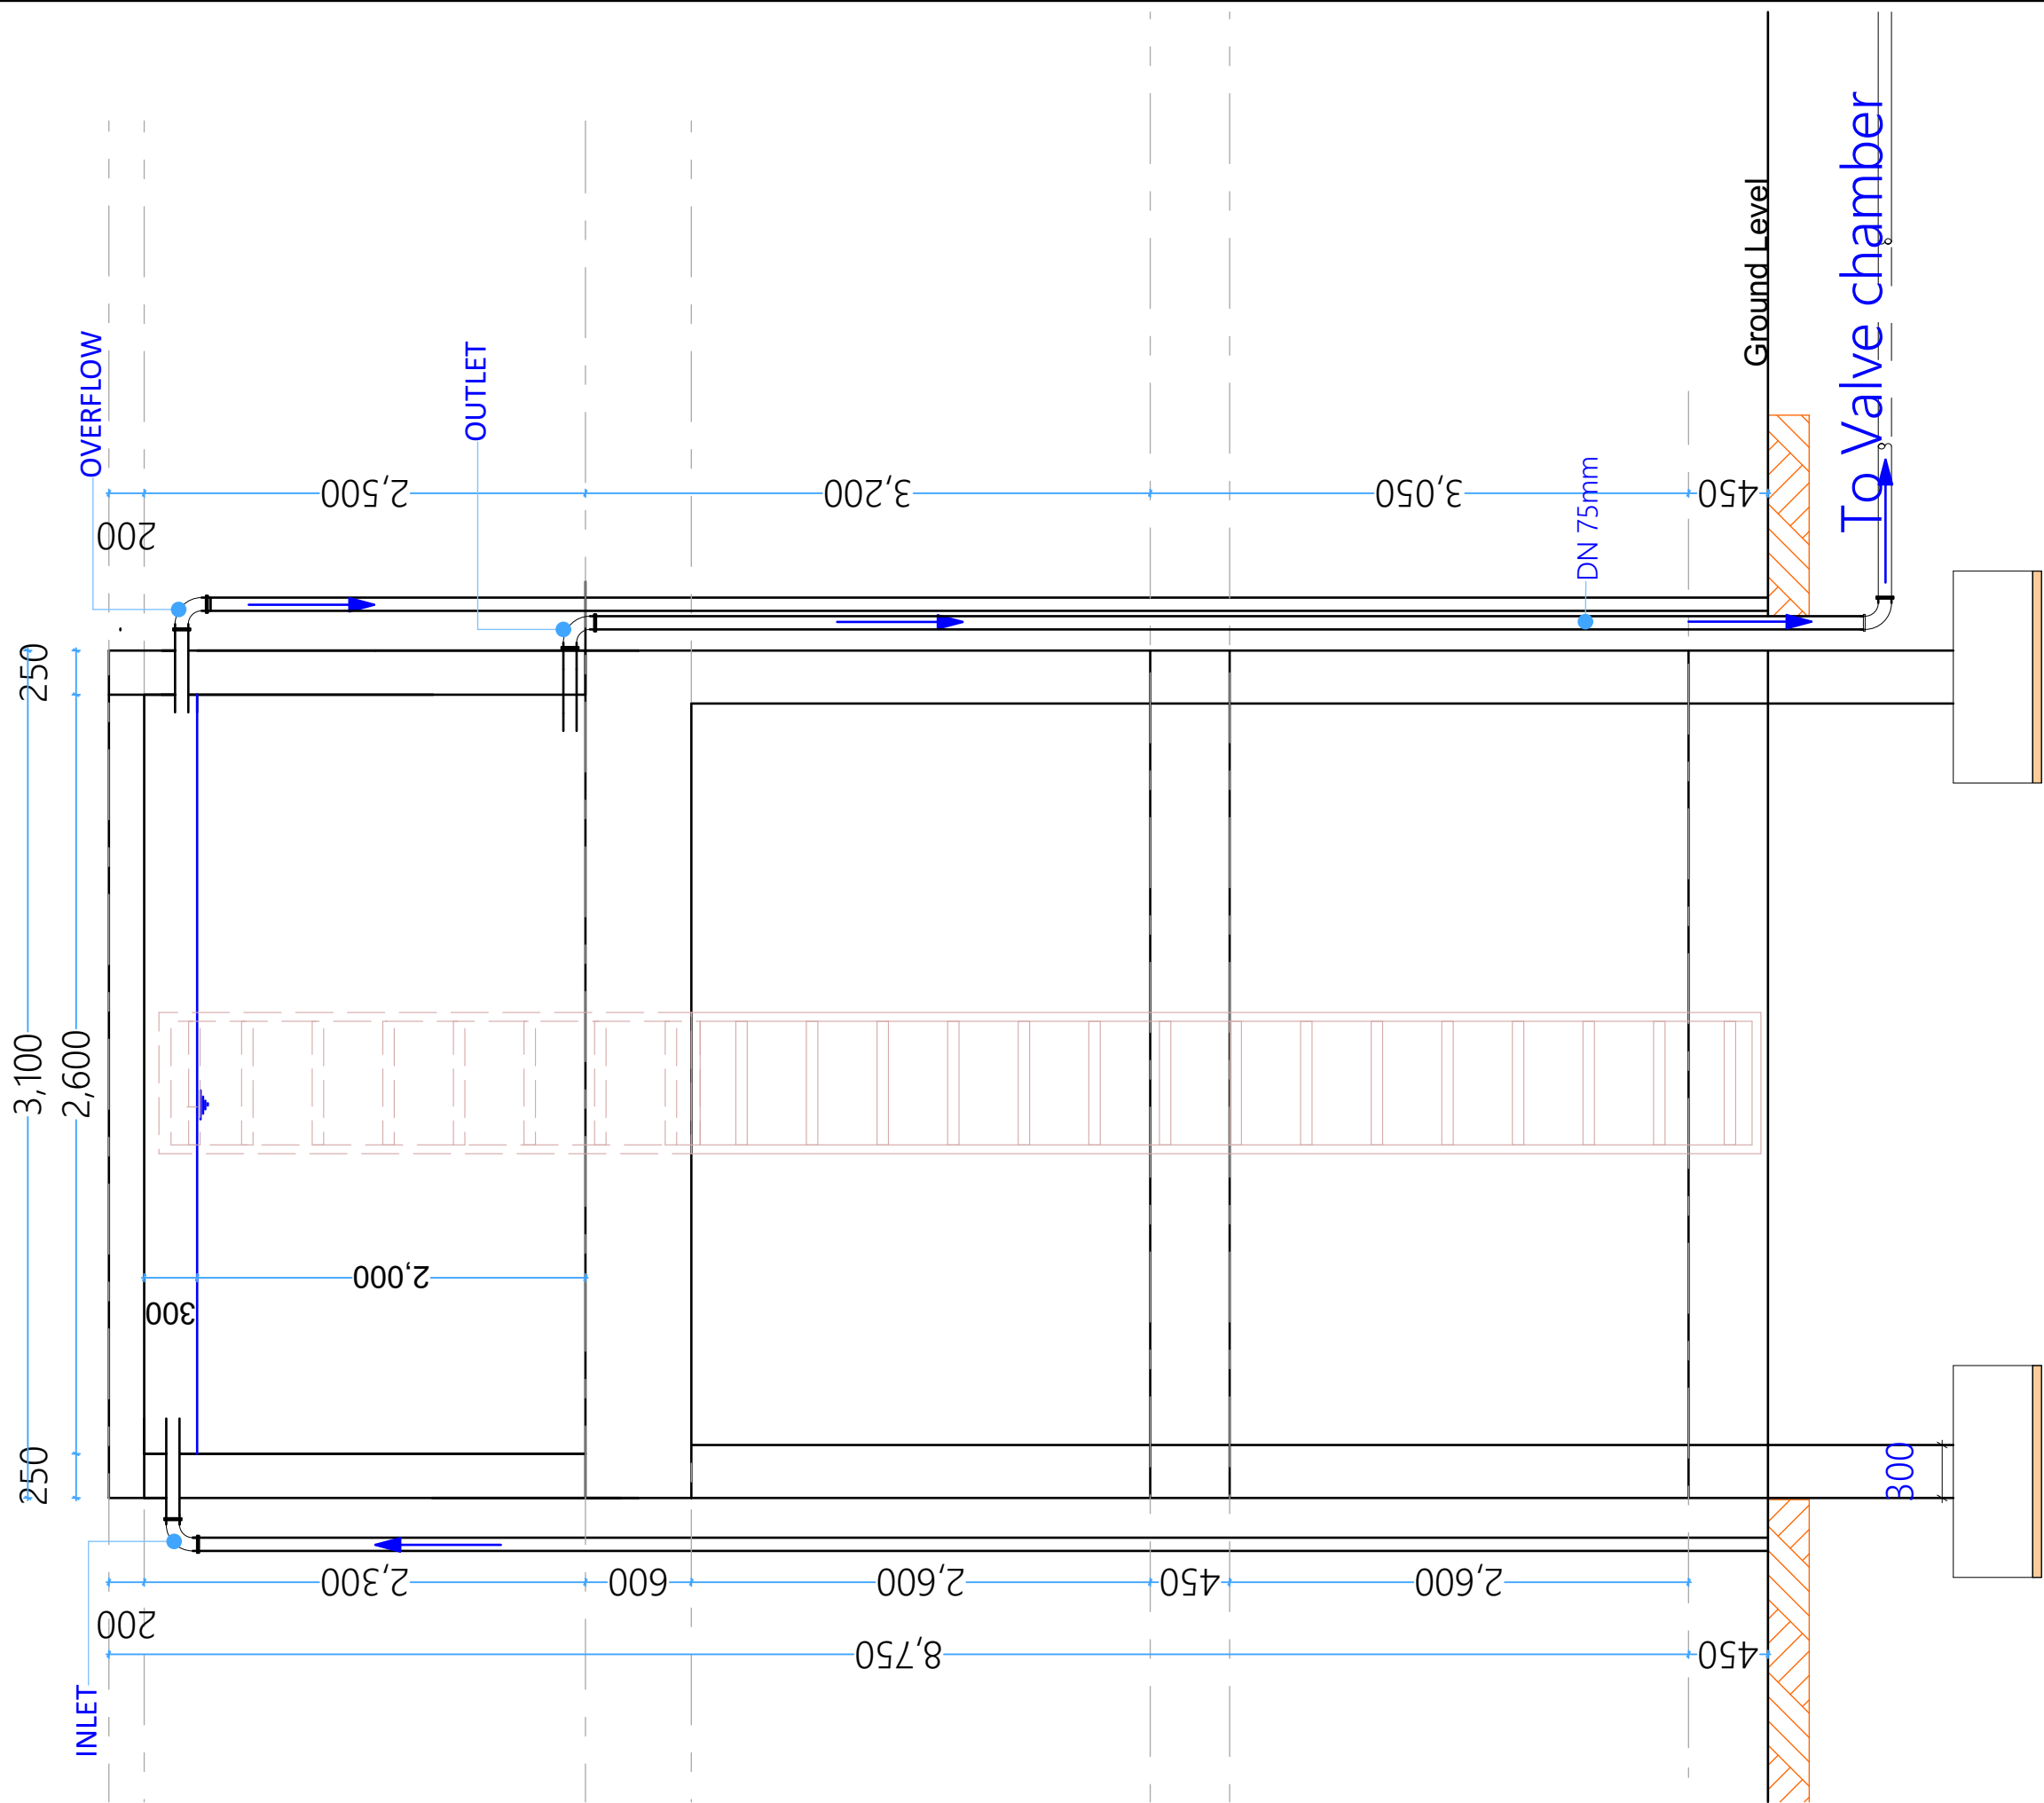
PROJECT TITLE:	DONOR:	DRAWING TITLE:	Project No.	Sheet No. 3/10	 ENDING EXTREME POVERTY WHATEVER IT TAKES Somalia
JUBALAND TTI in Kismayo Jubaland State, Gedo Region, Somalia	 	10CM Elevated Tank: Bottom Slab Reinforcement Details REF: JUBALAND TTI_S_10CM ELEVATED TANK	Scale: 1:100	Date: Oct 2021	
			Design: H.E.	Checked:	






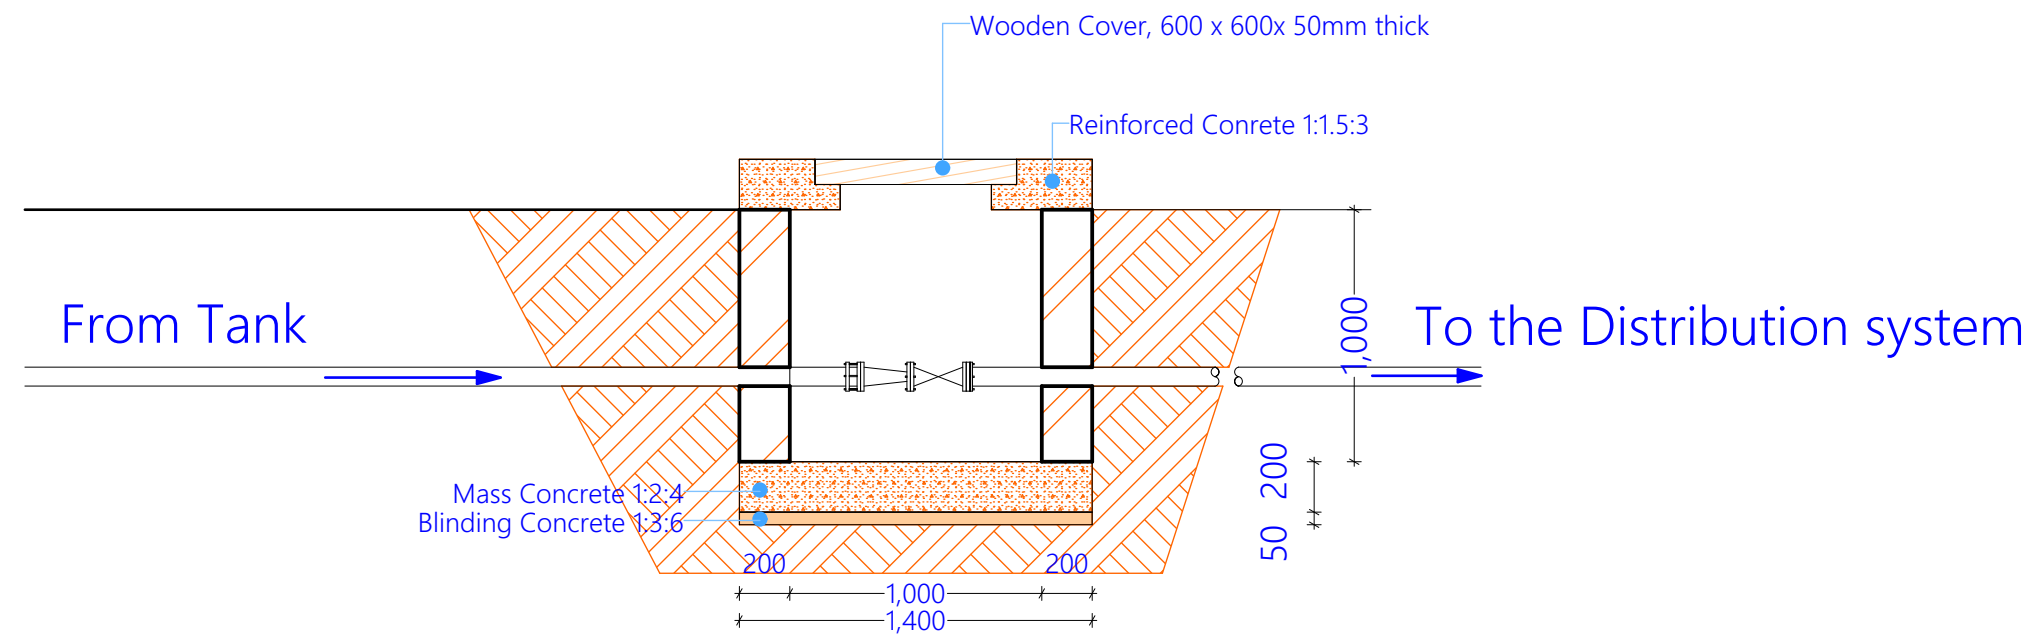
WATER TANK SECTION S11-S11

SCALE 1:50

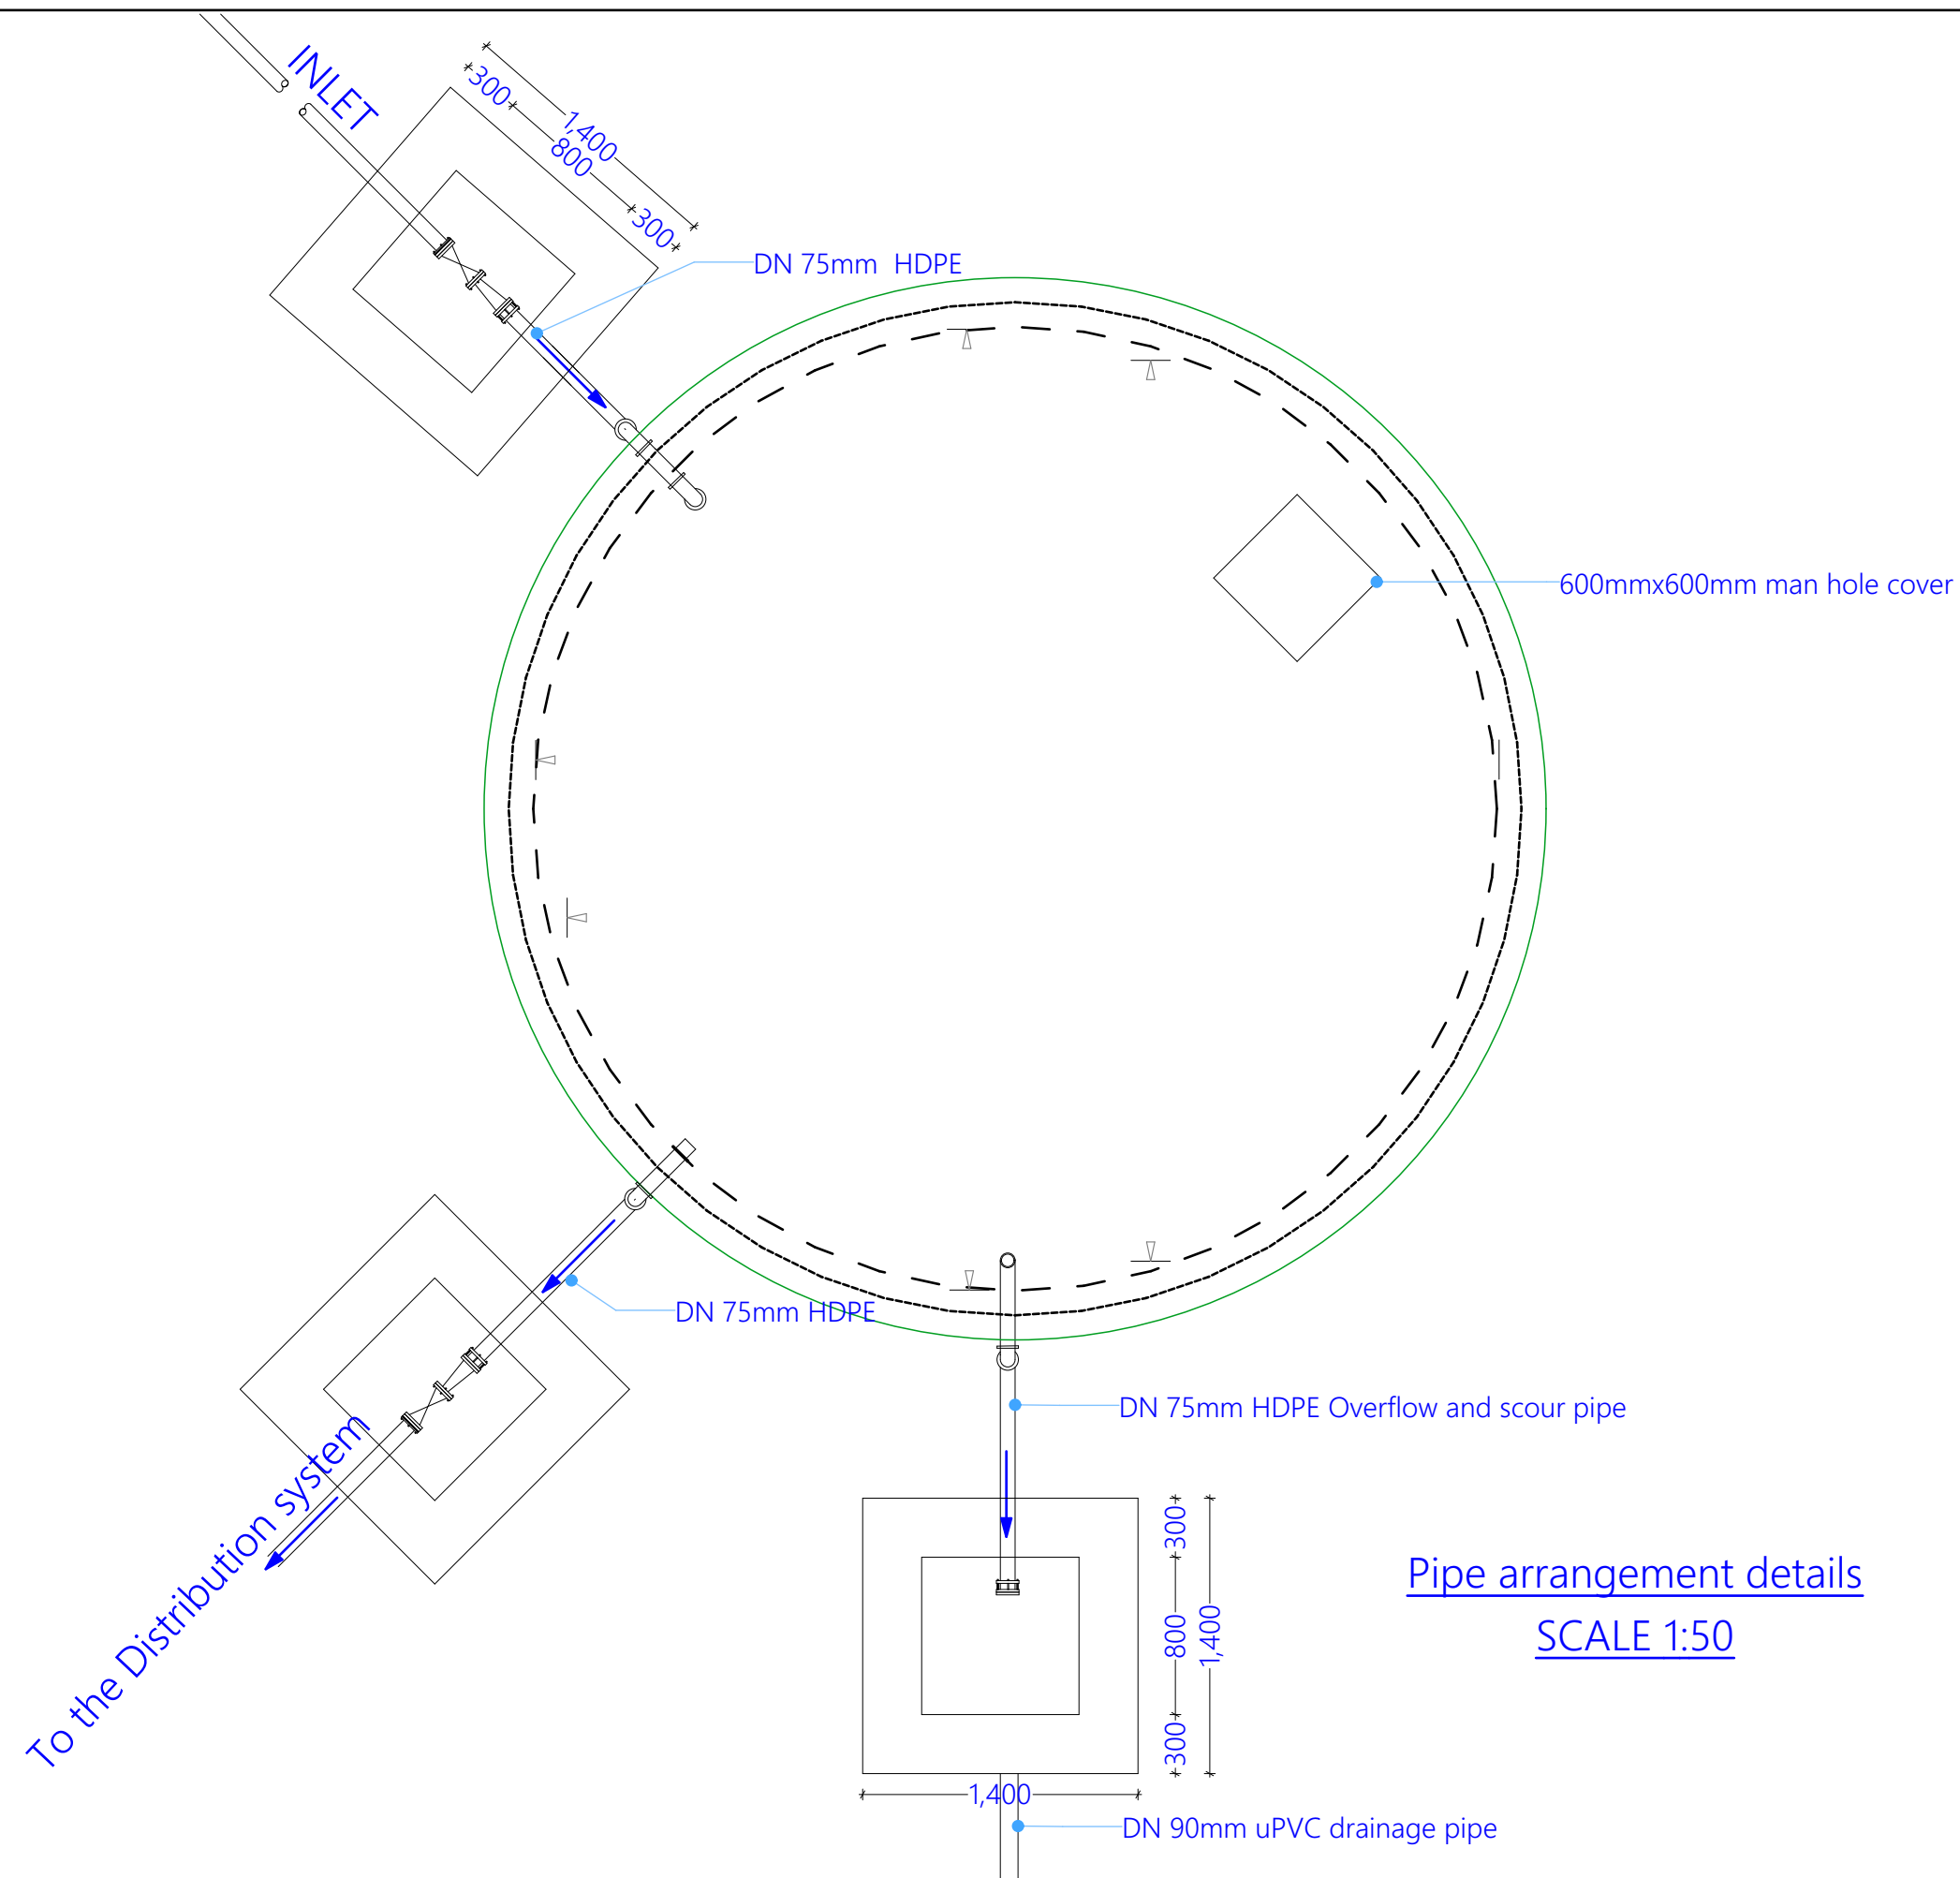
PROJECT TITLE:	DONOR:	DRAWING TITLE:	Project No.	Sheet No. 4/10	<div>CONCERN worldwide</div> <div>ENDING EXTREME POVERTY WHATEVER IT TAKES</div> <div>Somalia</div>
JUBALAND TTI in Kismayo Jubaland State, Gedo Region, Somalia	 	10CM Elevated Tank:Section S11-S11 REF: JUBALAND TTI_S_10CM ELEVATED TANK	Scale: 1:100	Date: Oct 2021	
			Design: H.E.	Checked:	






PROJECT TITLE:	DONOR:	DRAWING TITLE:	Project No.	Sheet No. 5/10	 ENDING EXTREME POVERTY WHATEVER IT TAKES Somalia
JUBALAND TTI in Kismayo Jubaland State, Gedo Region, Somalia	 	10CM Elevated Tank: Piping Layout Plan	Scale: 1:100	Date: Oct 2021	
		REF: JUBALAND TTI_S_10CM ELEVATED TANK	Design: H.E.	Checked:	




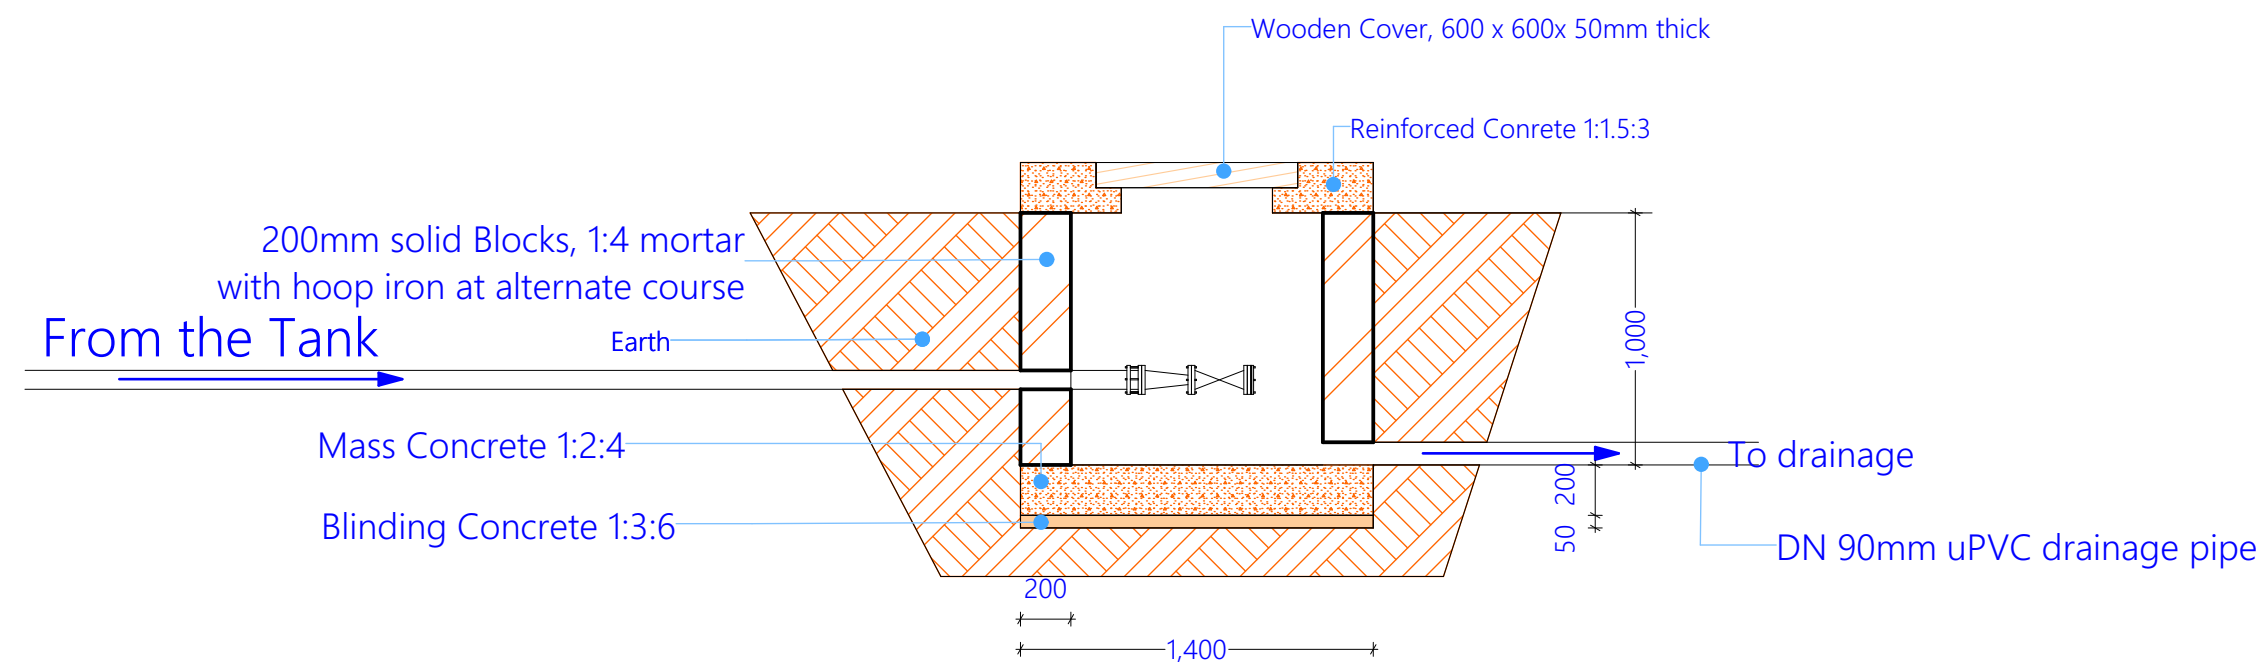


Valve Chamber outlet
SCALE 1:50




Drainage Chamber outlet
SCALE 1:20

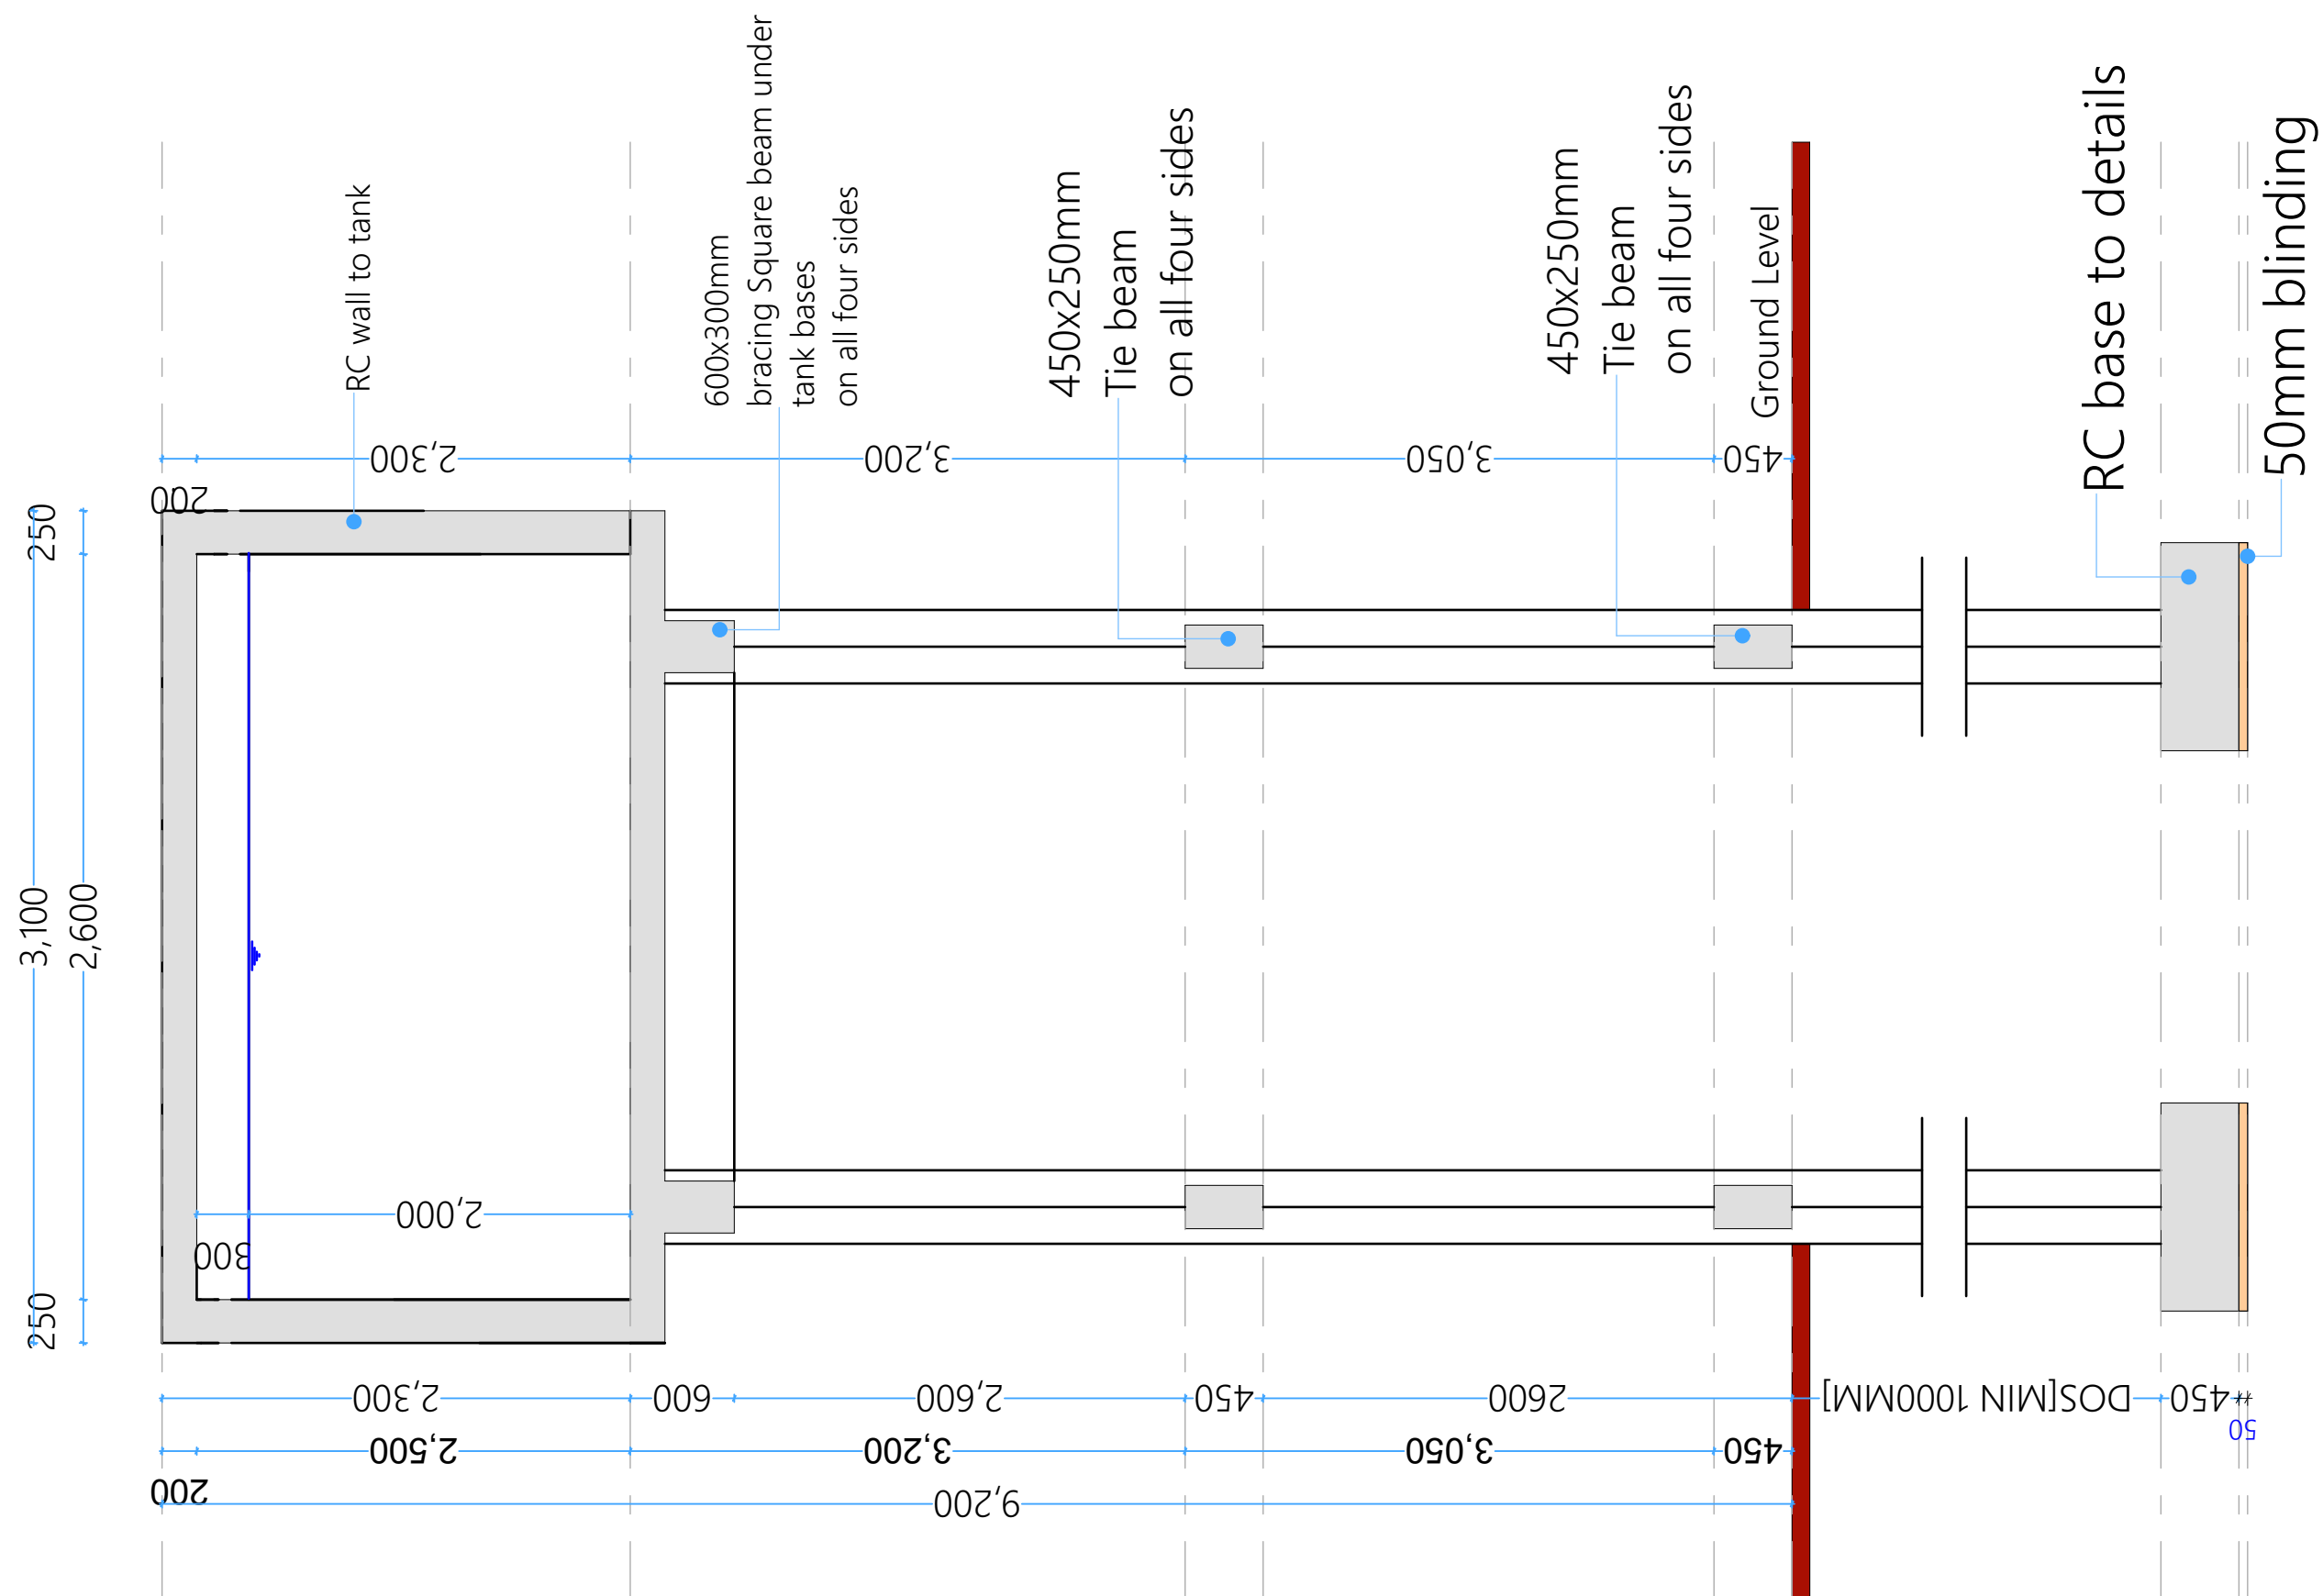PROJECT TITLE:	DONOR:	DRAWING TITLE:	Project No.	Sheet No. 6/10	 ENDING EXTREME POVERTY WHATEVER IT TAKES Somalia
JUBALAND TTI in Kismayo Jubaland State, Gedo Region, Somalia	 	10CM Elevated Tank: Drainage Section REF: JUBALAND TTI_S_10CM ELEVATED TANK	Scale: 1:100	Date: Oct 2021	
			Design: H.E.	Checked:	








PROJECT TITLE:	DONOR:	DRAWING TITLE:	Project No.	Sheet No. 7/10	 ENDING EXTREME POVERTY WHATEVER IT TAKES
JUBALAND TTI in Kismayo Jubaland State, Gedo Region, Somalia	 	10CM Elevated Tank: Section S10-S10	Scale: 1:100	Date: Oct 2021	
		REF: JUBALAND TTI_S_10CM ELEVATED TANK	Design: H.E.	Checked:	

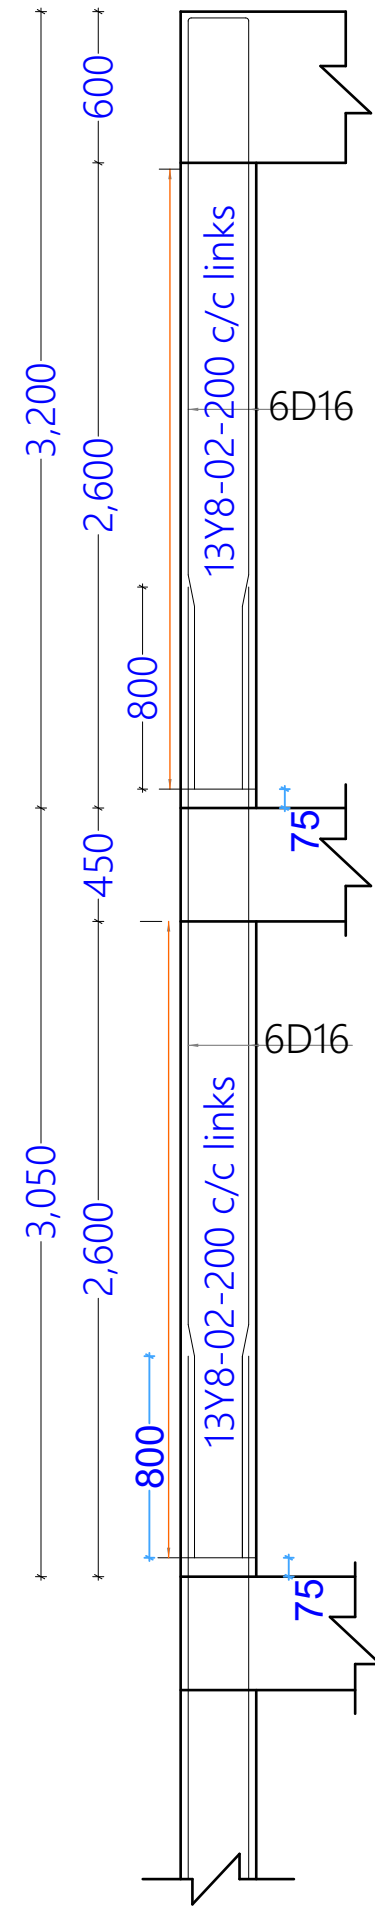
Somalia

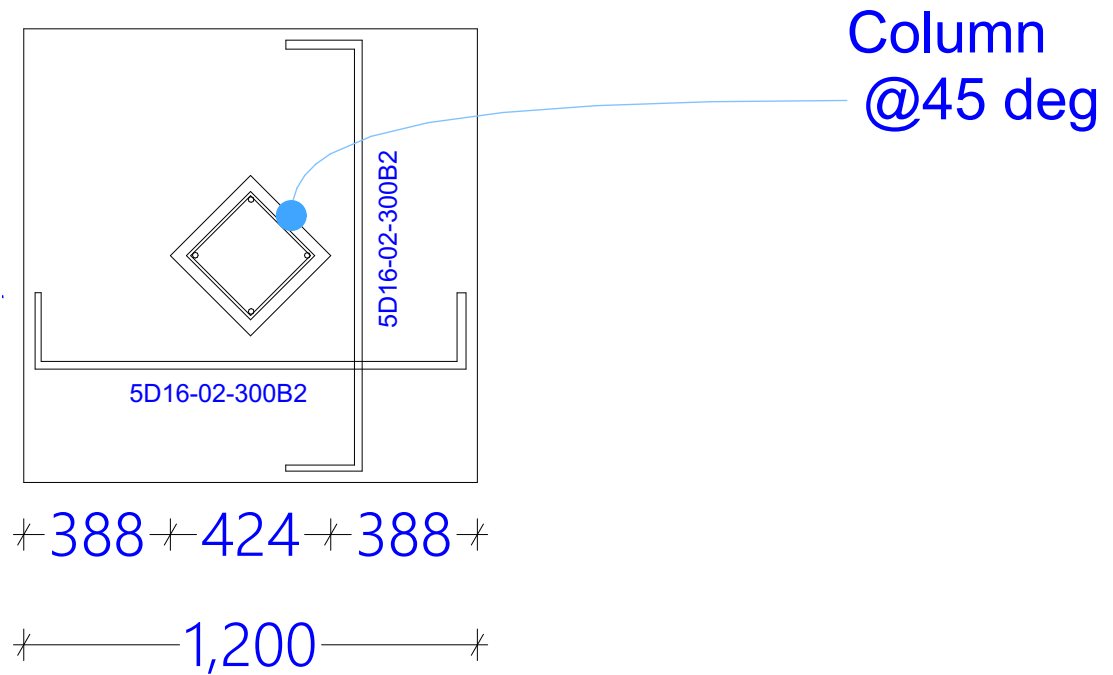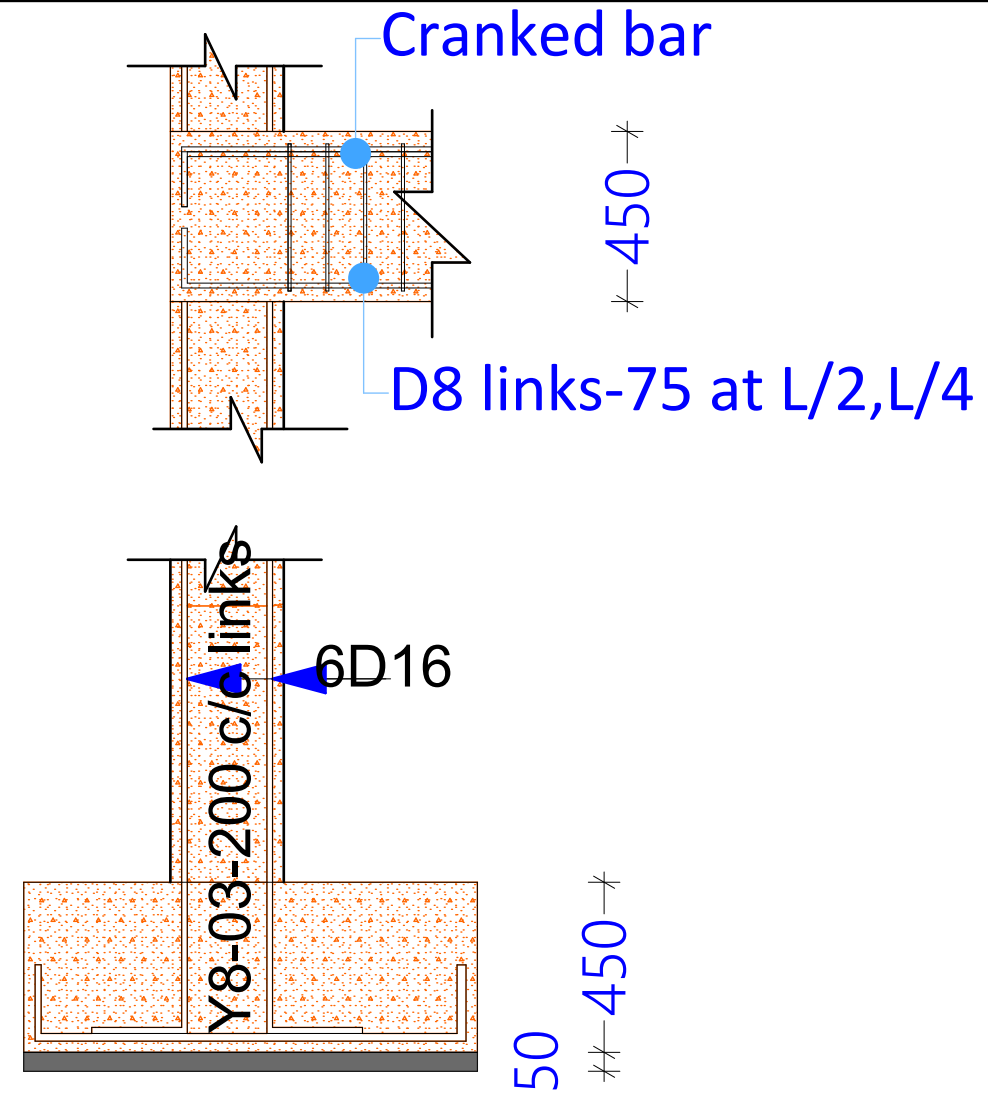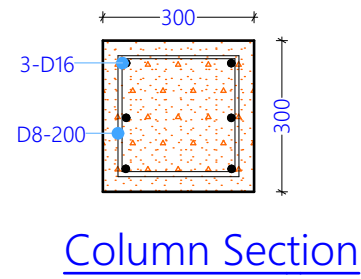


300x300 RC COL 4 Nos. Thus.
SCALE 1:25




PROJECT TITLE:	DONOR:	DRAWING TITLE:	Project No.	Sheet No. 8/10	<div>CONCERN worldwide</div> <div>ENDING EXTREME POVERTY WHATEVER IT TAKES</div> <div>Somalia</div>
JUBALAND TTI in Kismayo Jubaland State, Gedo Region, Somalia	 	10CM Elevated Tank: Rebar arrangement REF: JUBALAND TTI_S_10CM ELEVATED TANK	Scale: 1:100	Date: Oct 2021	
			Design: H.E.	Checked:	

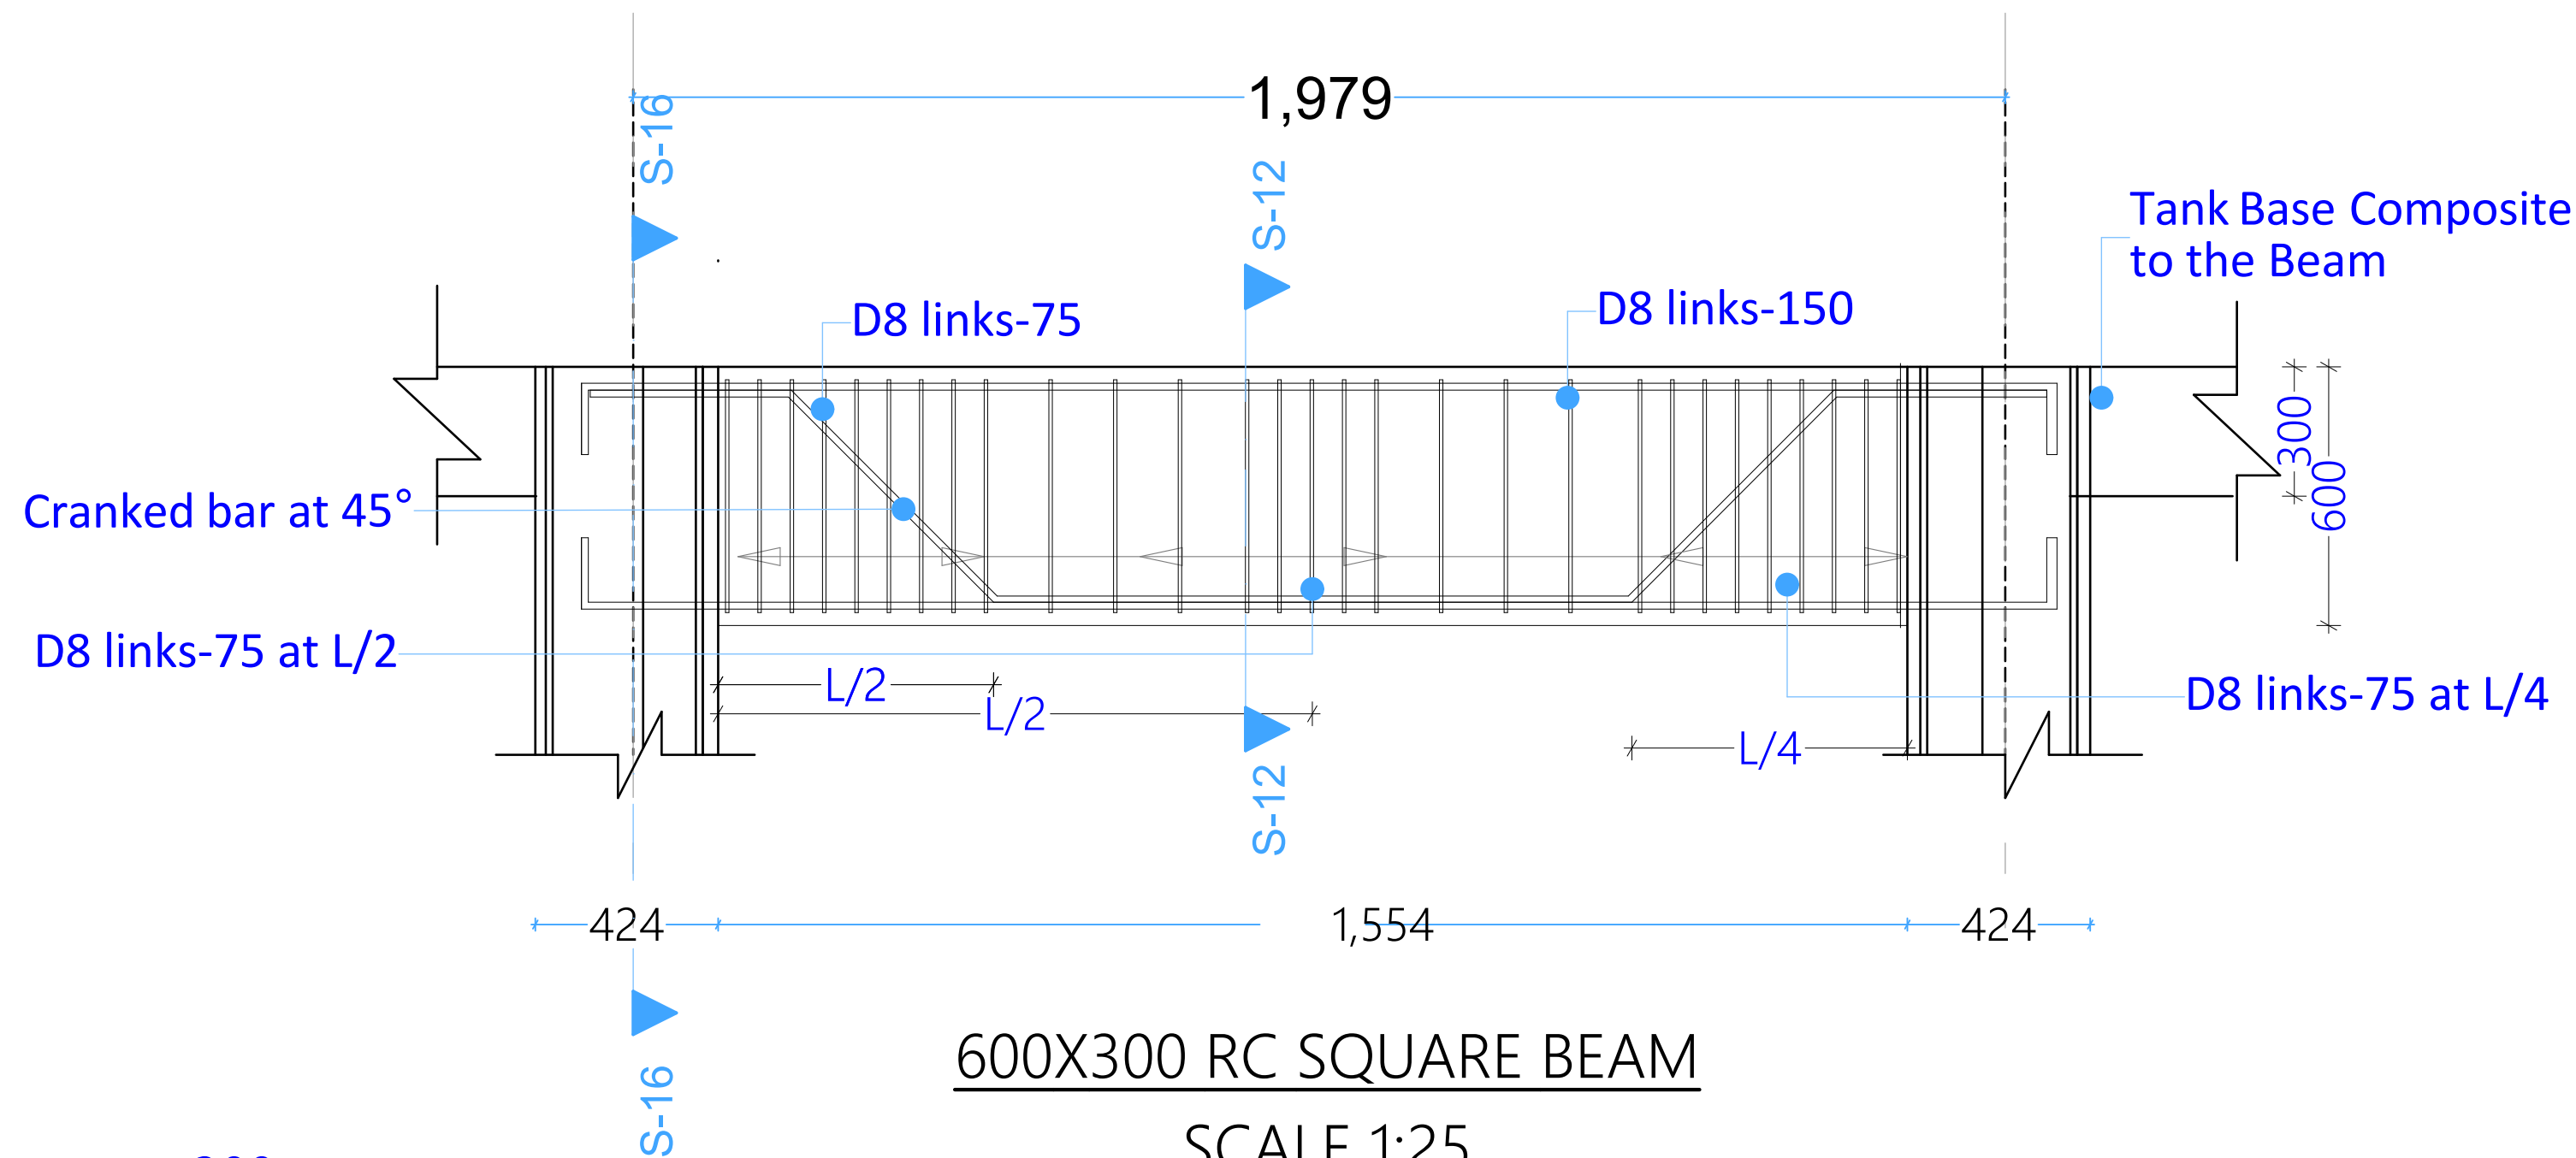

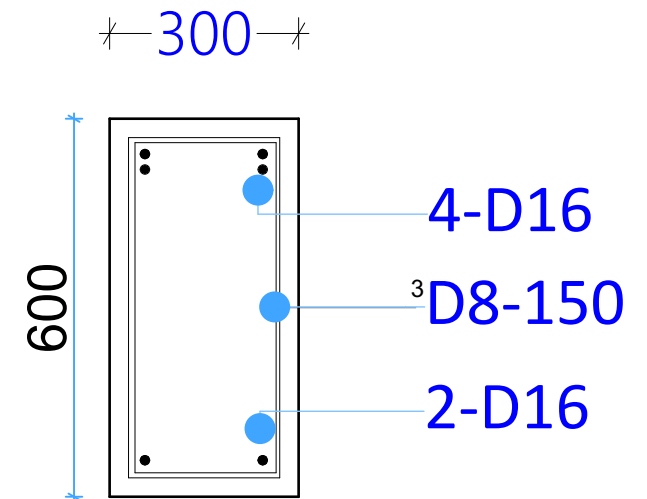

600X300 RC SQUARE BEAM
SCALE 1:25




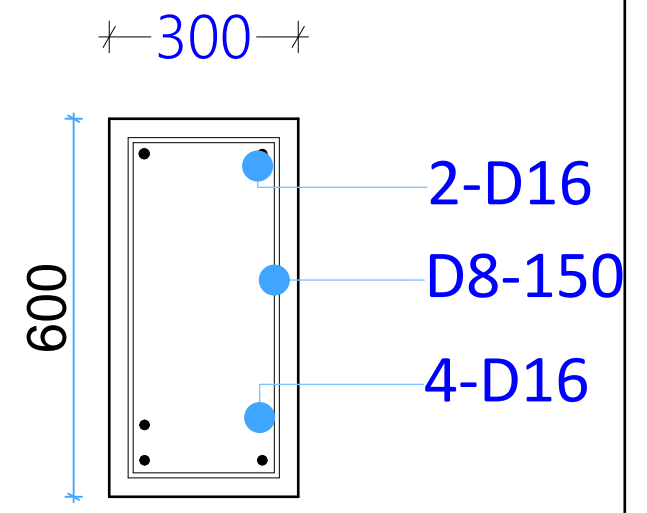

SECTION S16-S16



SECTION S12-S12

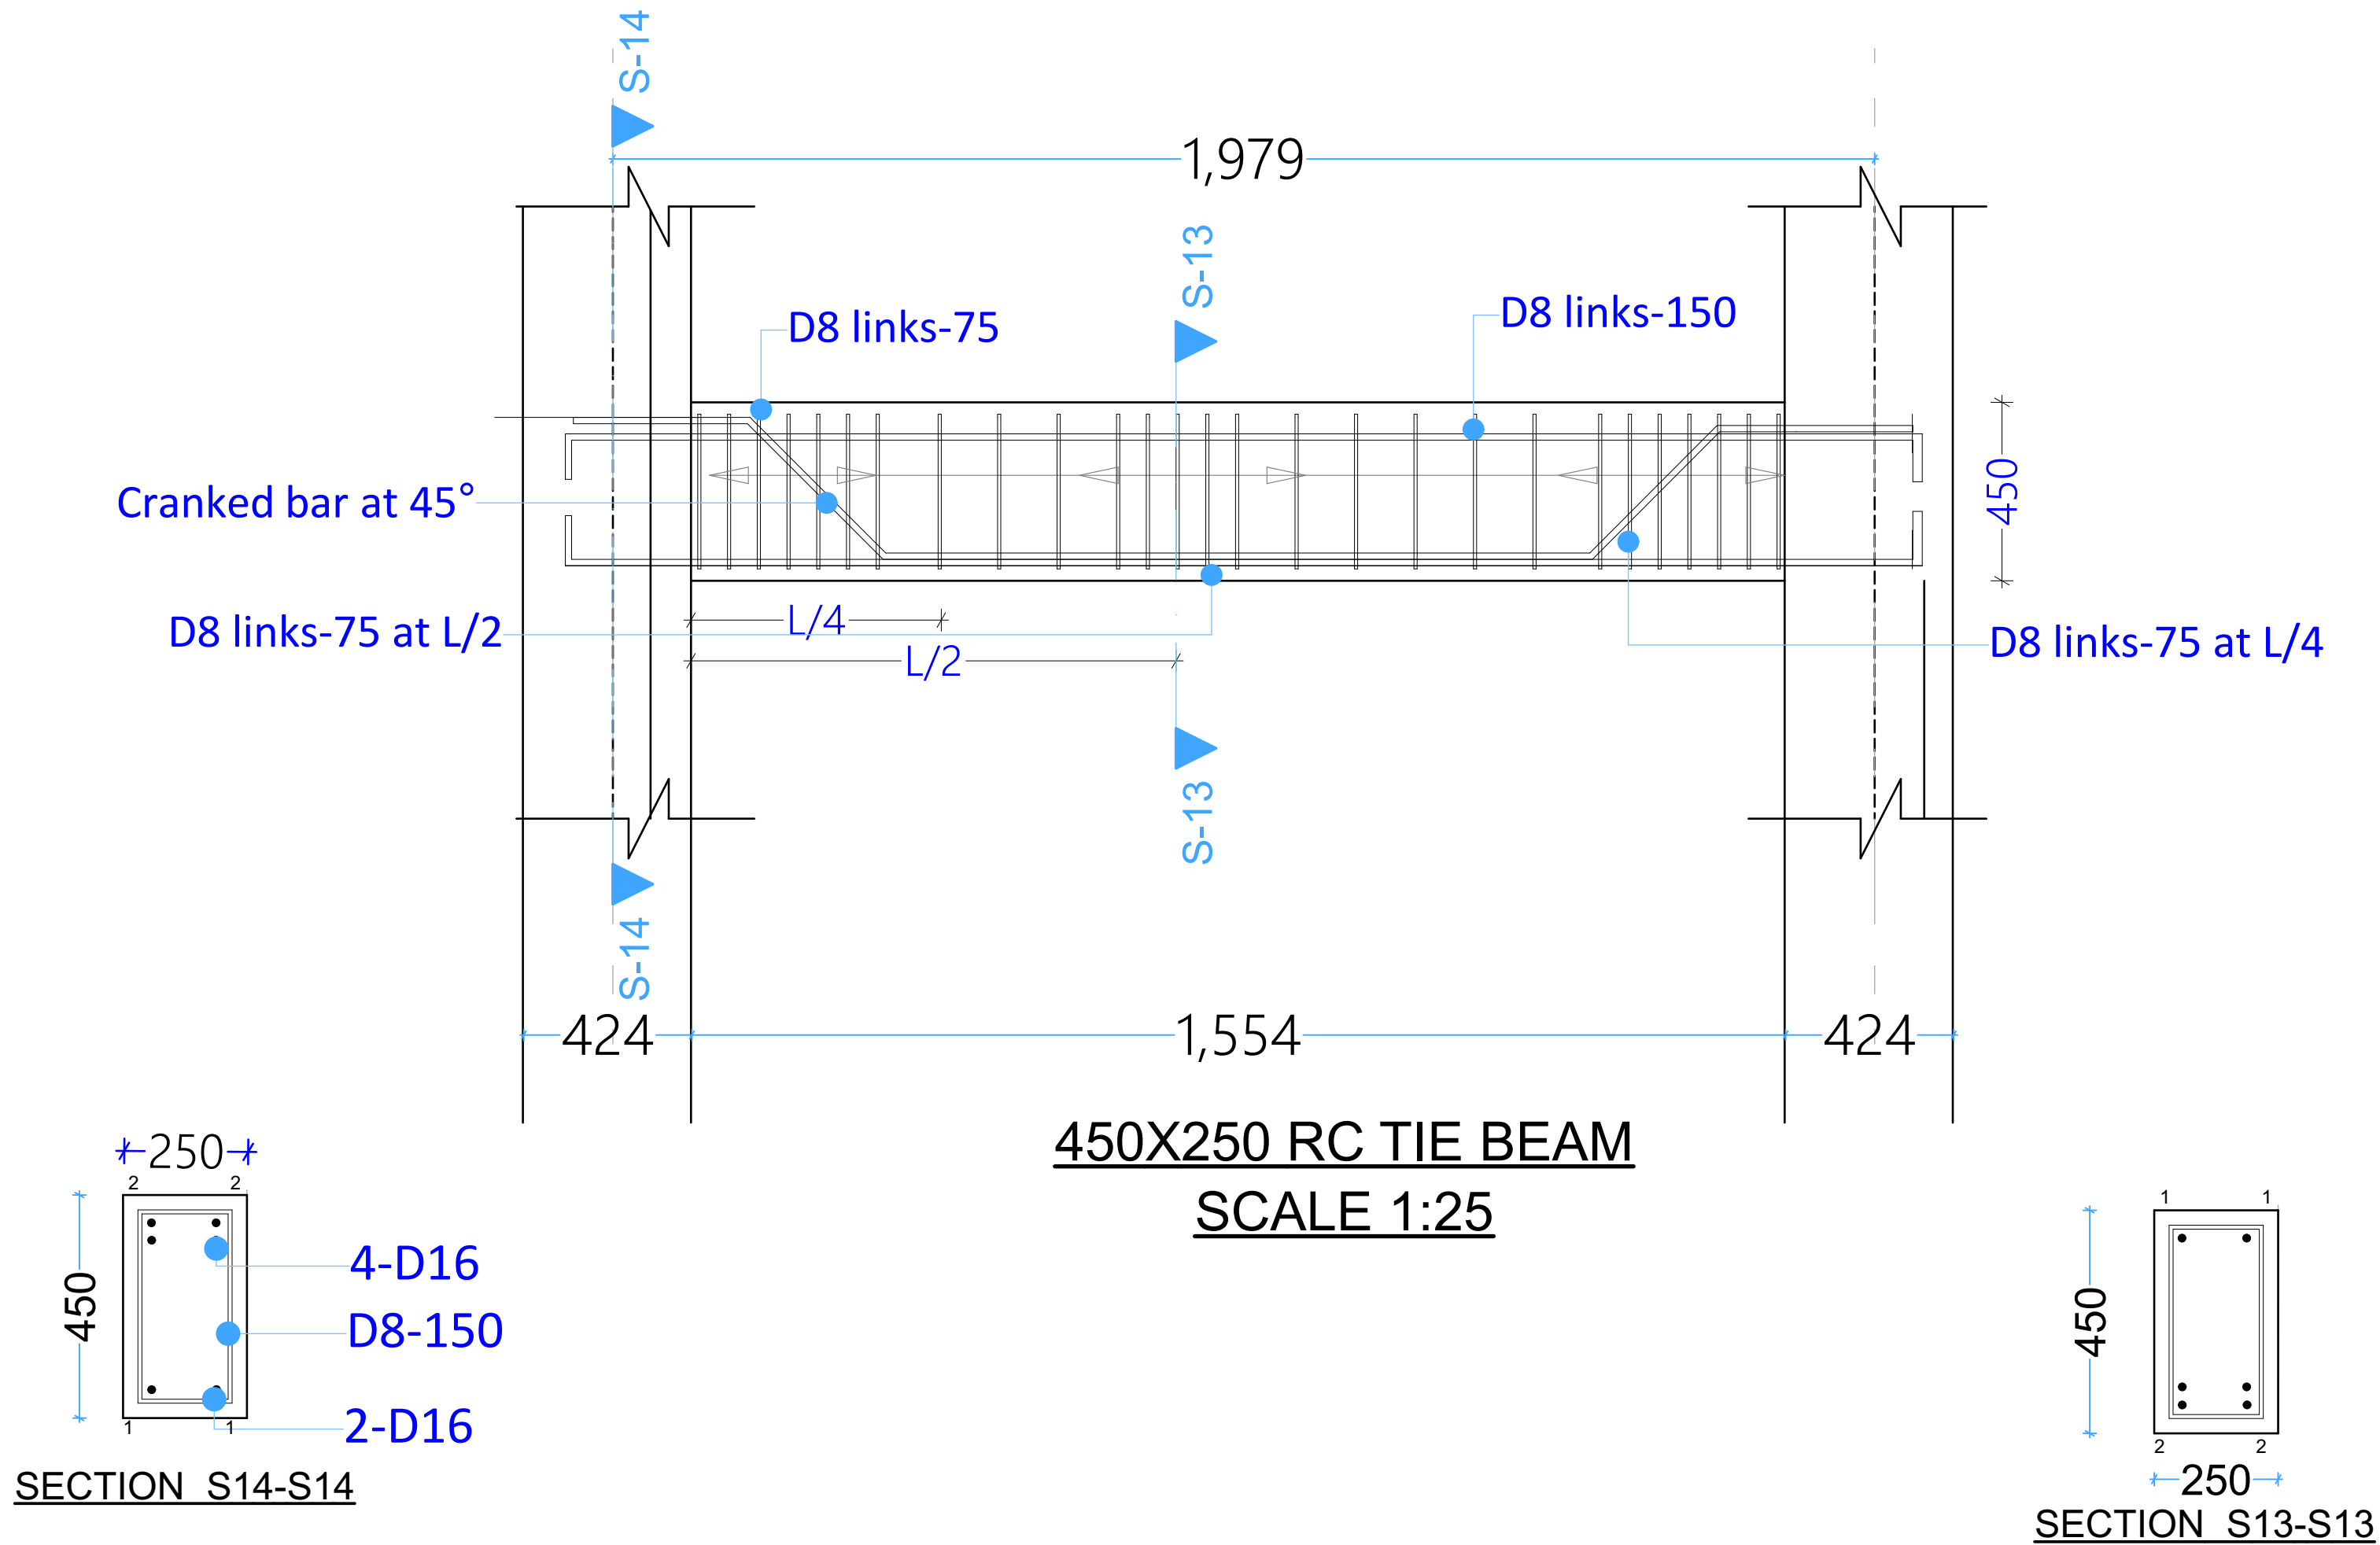PROJECT TITLE:	DONOR:	DRAWING TITLE:	Project No.	Sheet No. 9/10	<div><div>CONCERN worldwide</div><div>ENDING EXTREME POVERTY WHATEVER IT TAKES</div><div>Somalia</div></div>
JUBALAND TTI in Kismayo Jubaland State, Gedo Region, Somalia	 	10CM Elevated Tank: Square Beam Section	Scale: 1:100	Date: Oct 2021	
		REF: JUBALAND TTI_S_10CM ELEVATED TANK	Design: H.E.	Checked:	



PROJECT TITLE:	DONOR:	DRAWING TITLE:	Project No.	Sheet No. 10/10	<div>CONCERN worldwide</div> <div>ENDING EXTREME POVERTY WHATEVER IT TAKES</div> <div>Somalia</div>
JUBALAND TTI in Kismayo Jubaland State, Gedo Region, Somalia	 	10CM Elevated Tank: Tie Beam Section REF: JUBALAND TTI_S_10CM ELEVATED TANK	Scale: 1:100	Date: Oct 2021	
			Design: H.E.	Checked:	