

JPLG-LDF 2021 PROJECTS IN PUNTLAND STATE, SOMALIA

PROPOSED CONSTRUCTION AND REHABILITATION OF ALUULA

ADMINISTRATION BLOCK

PROJECT BID DRAWINGS

MARCH 2022

FUNDED & IMPLEMENTED BY:



UNITED NATIONS JOINT PROGRAM ON LOCAL GOVERNANCE (JPLG)



PUNTLAND STATE GOVERNMENT, SOMALIA


ALUULA DISTRICT LOCAL GOVERNMENT

PREPARED BY:



MINISTRY OF PUBLIC WORKS, HOUSING & TRANSPORT

(MoPWH&T), PUNTLAND STATE, SOMALIA

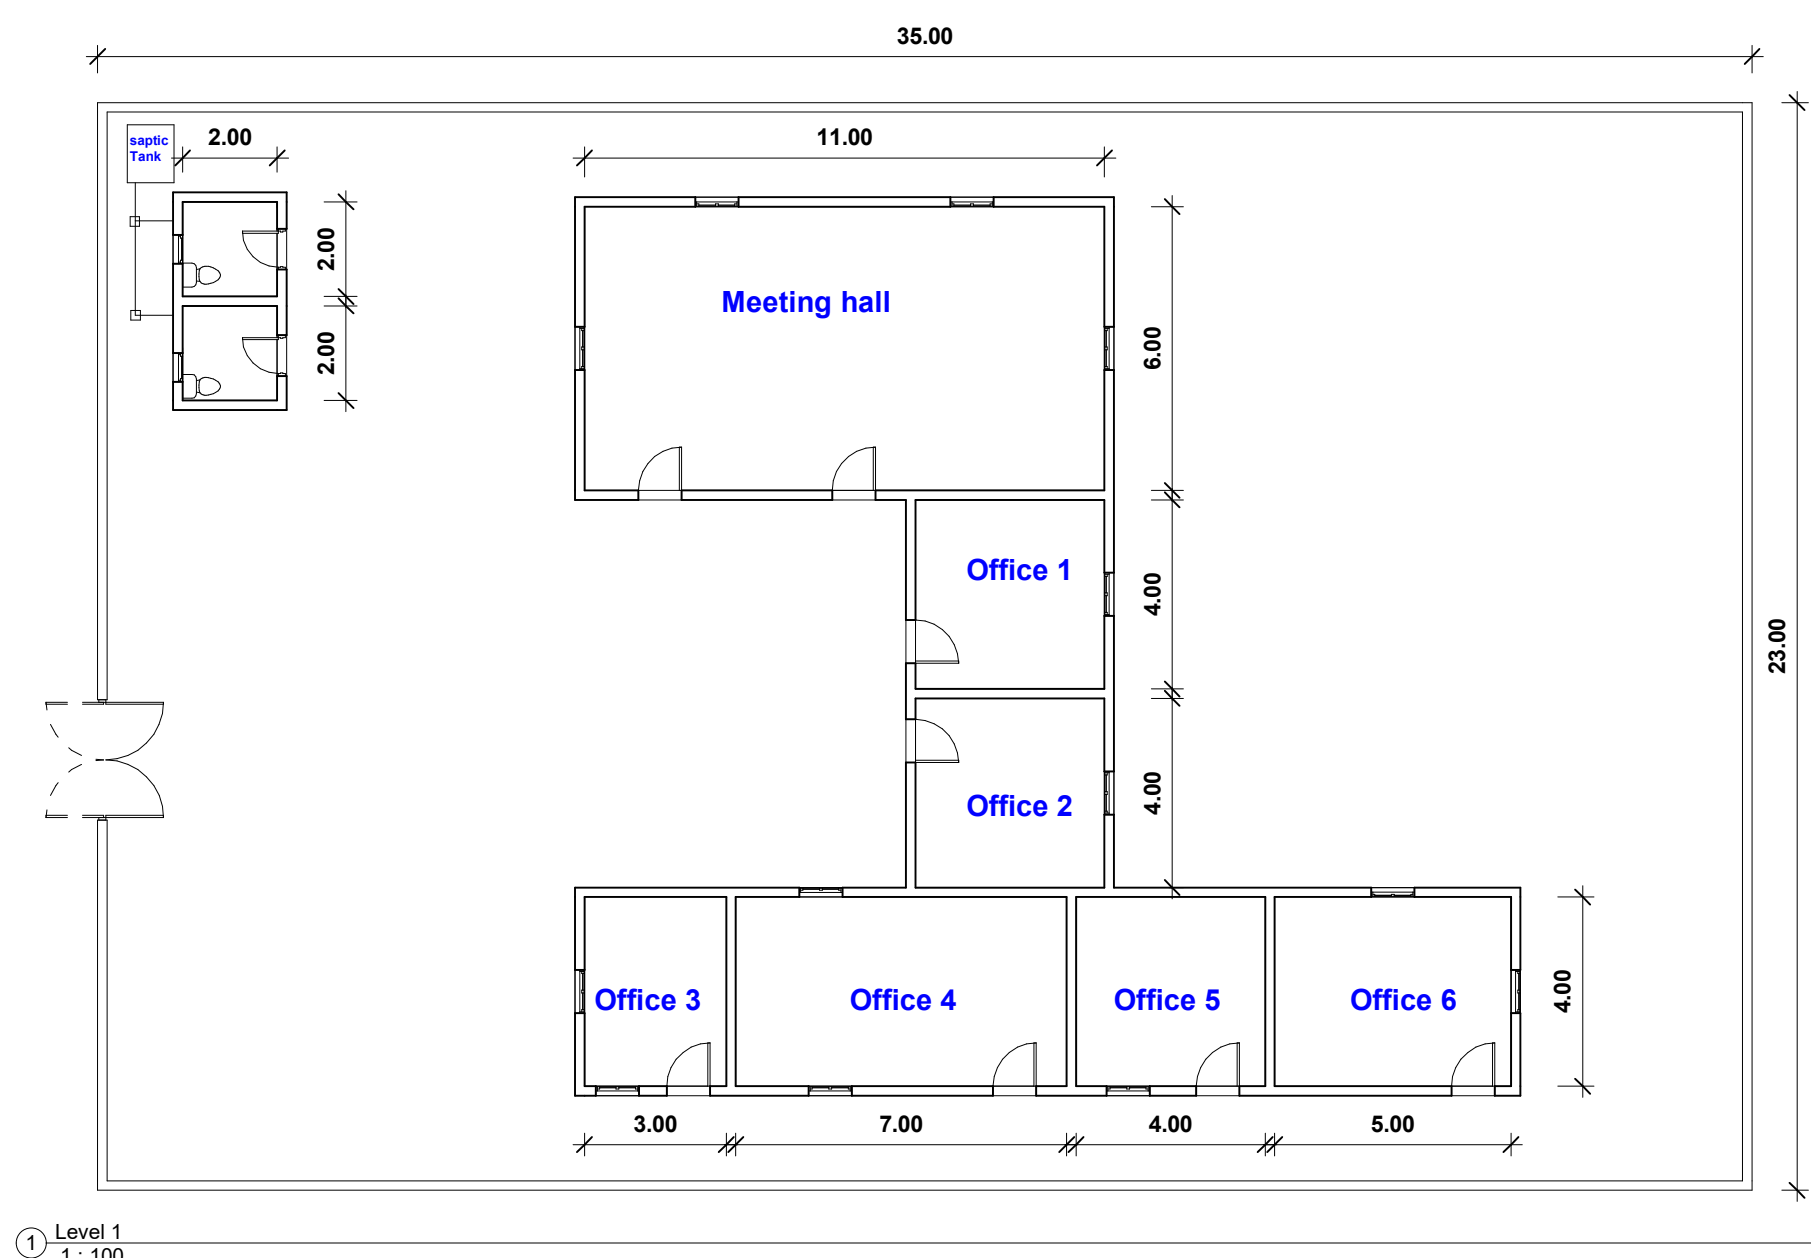

① Level 1
1 : 100




No.	Description	Date

Aluula Adminstration JPLG
2021 Project

Project number	
Date	12/3/2022
Drawn by	MOPWT
Checked by	

1

Scale	1 : 100
-------	---------

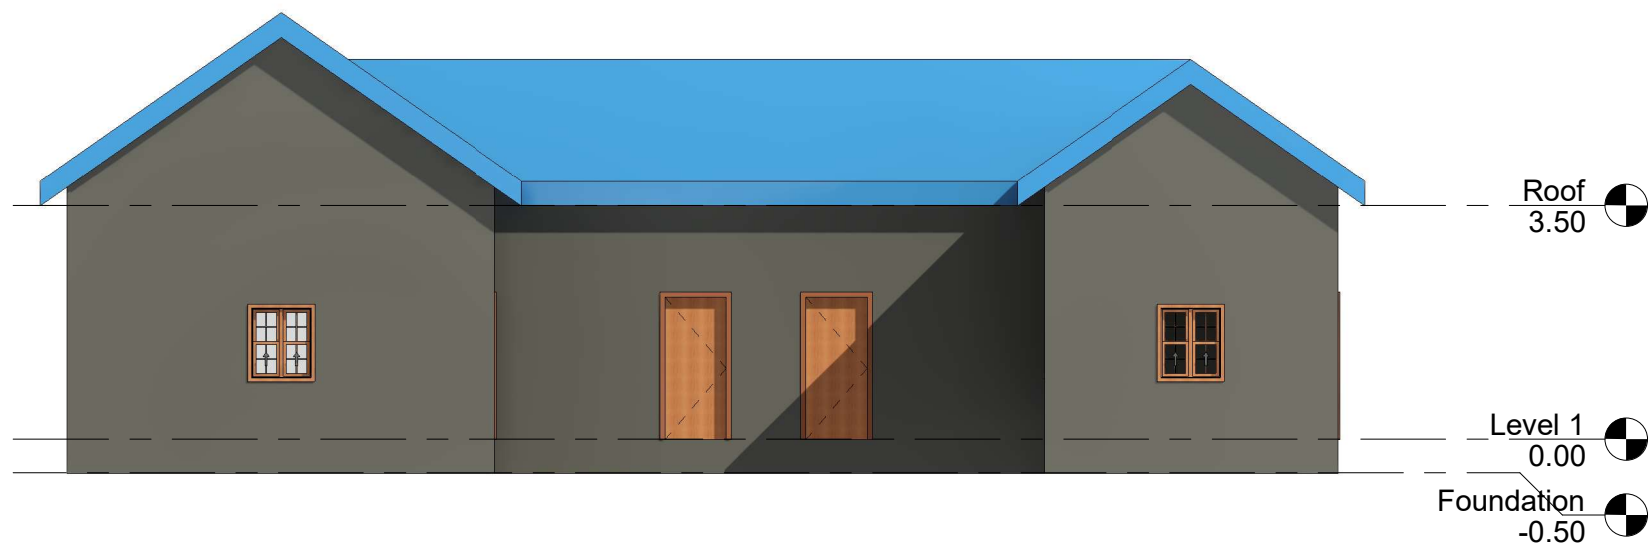

① Elevation 1 - a
1 : 100



Aluula Adminstration
JPLG 2021 Project



No.	Description	Date

Ellavation 1

Project number
Date 12/3/2022
Drawn by Author
Checked by

2

Scale 1 : 100

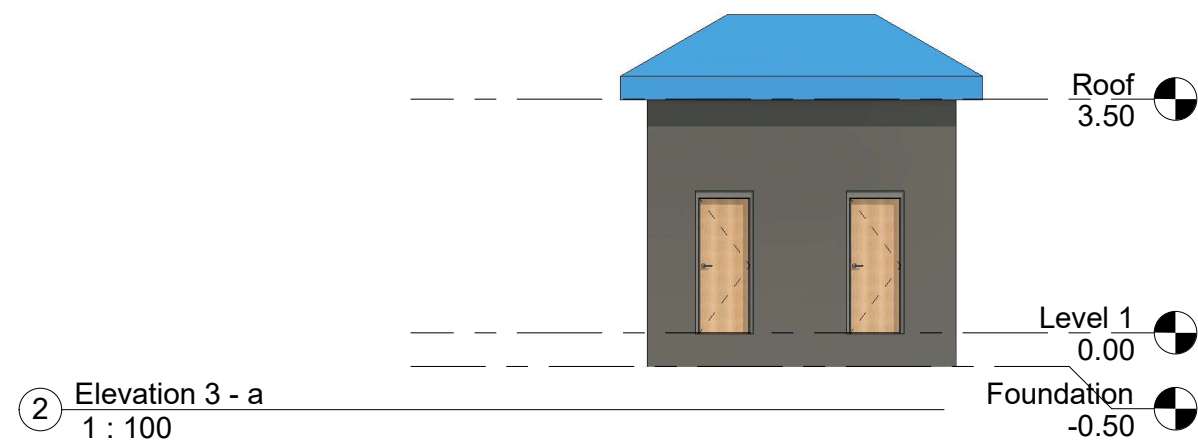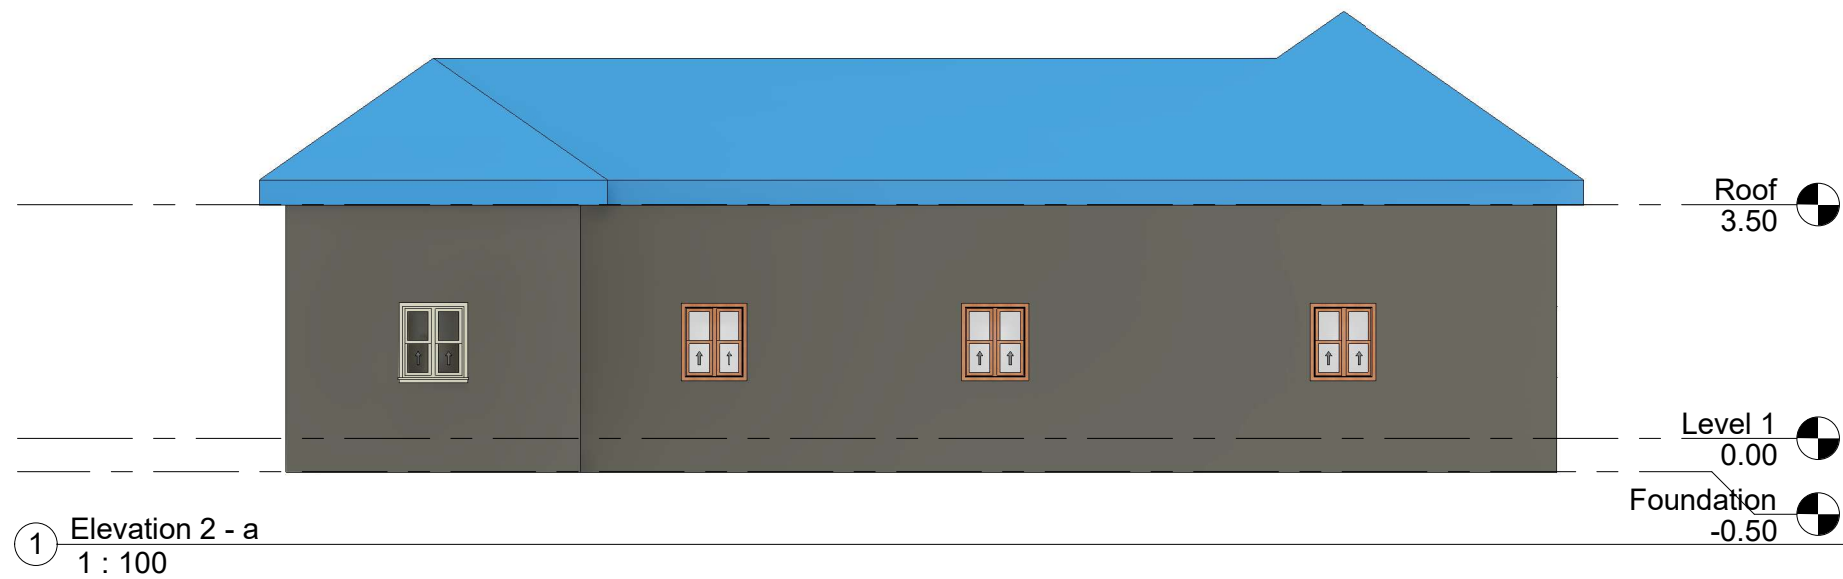

Aluula Adminstration
JPLG 2021 Project

No.	Description	Date

Ellavation 2

Project number

Date 12/3/2022

Drawn by Author




Checked by

3

Scale 1 : 100



① 3D View 3

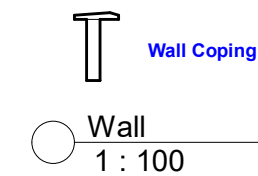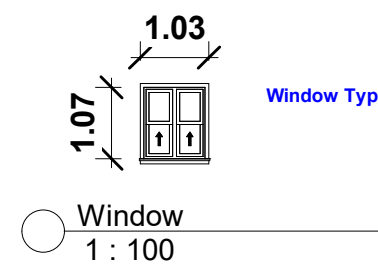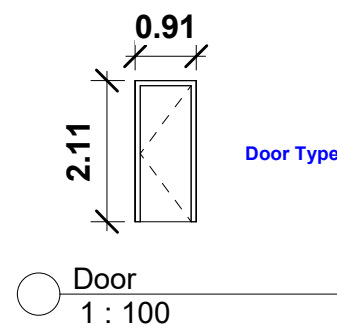

Aluula Adminstration
JPLG 2021 Project


No.	Description	Date

legarnd

Project number
Date 12/3/2022
Drawn by Author
Checked by

4

Scale 1 : 100

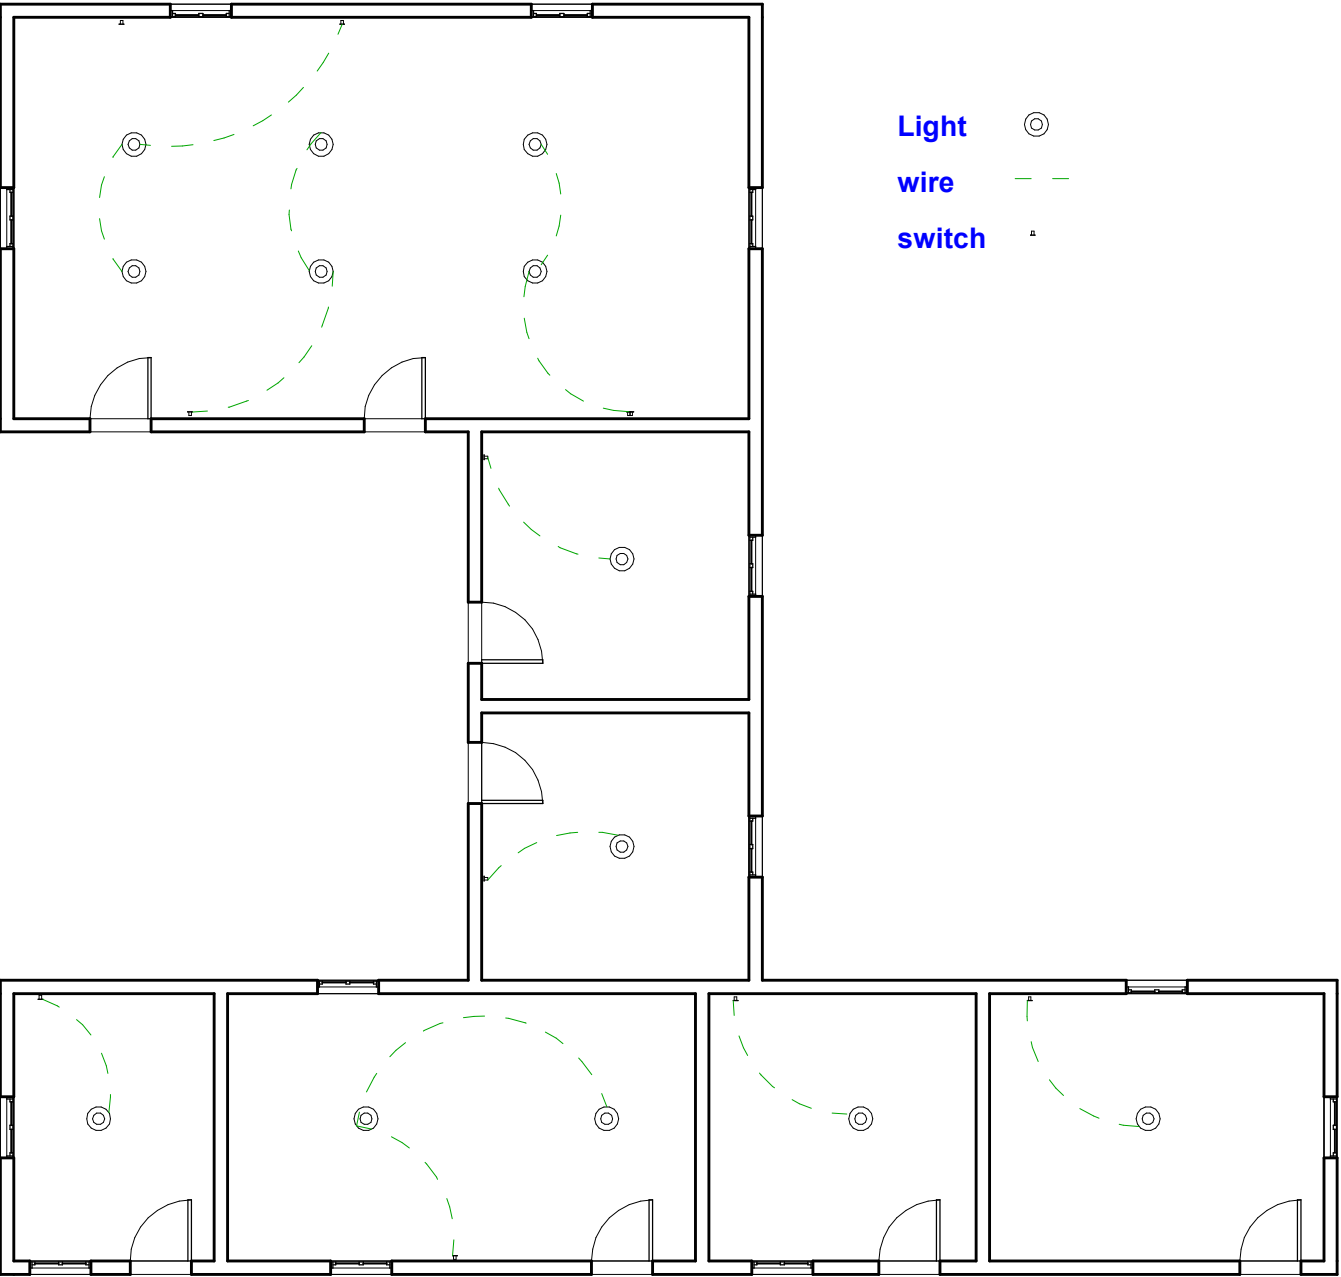

① Level 1 Copy 1
1 : 100





Aluula Adminstration
JPLG 2021 Project

No.	Description	Date

Electrical Plan

Project number	5
Date 12/3/2022	
Drawn by Author	
Checked by	Scale 1 : 100

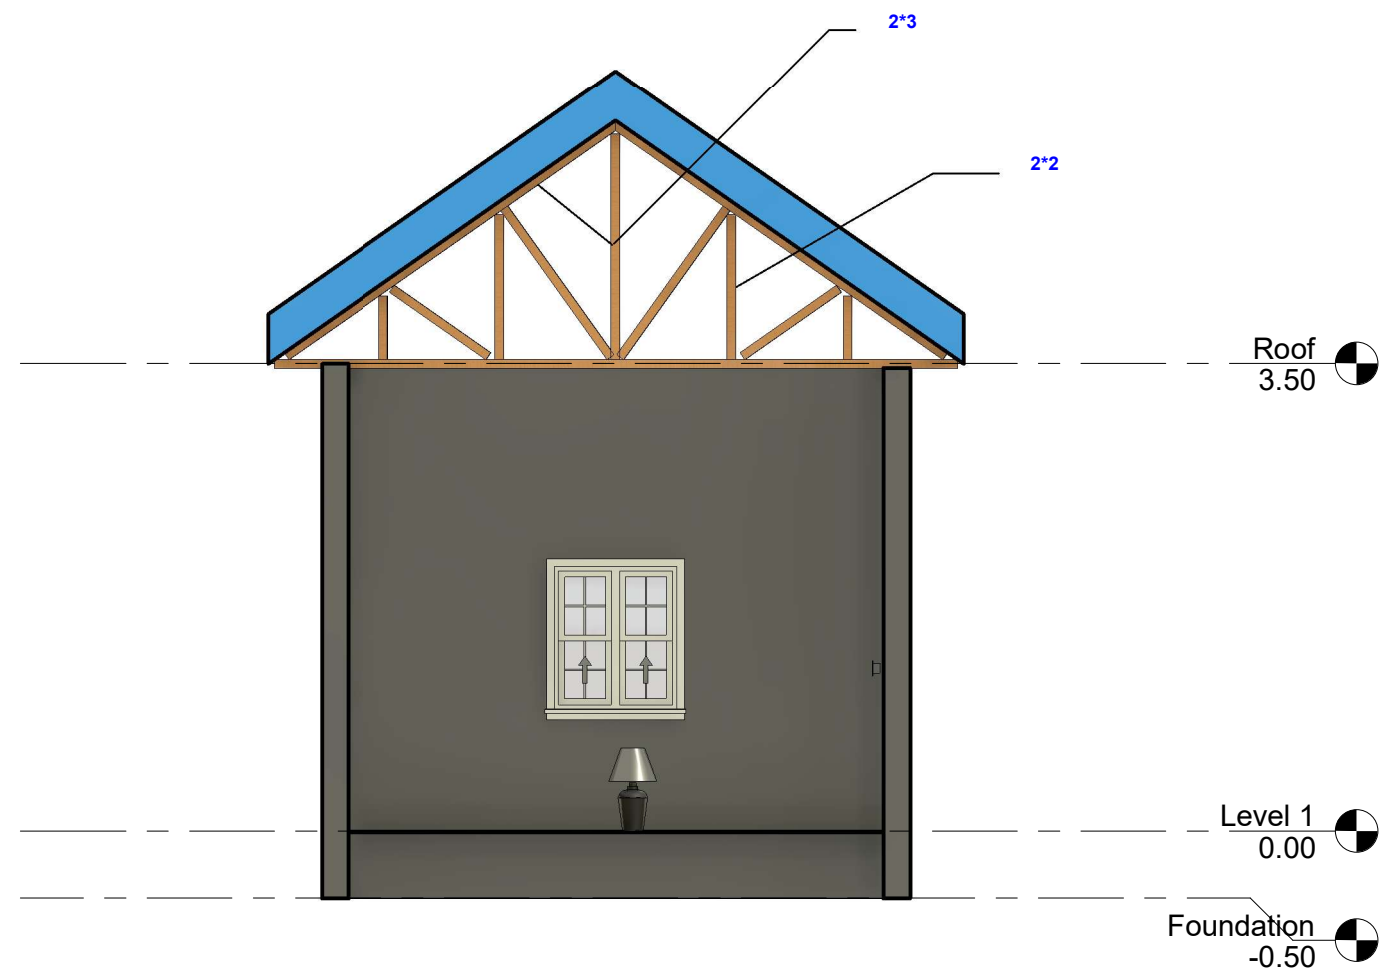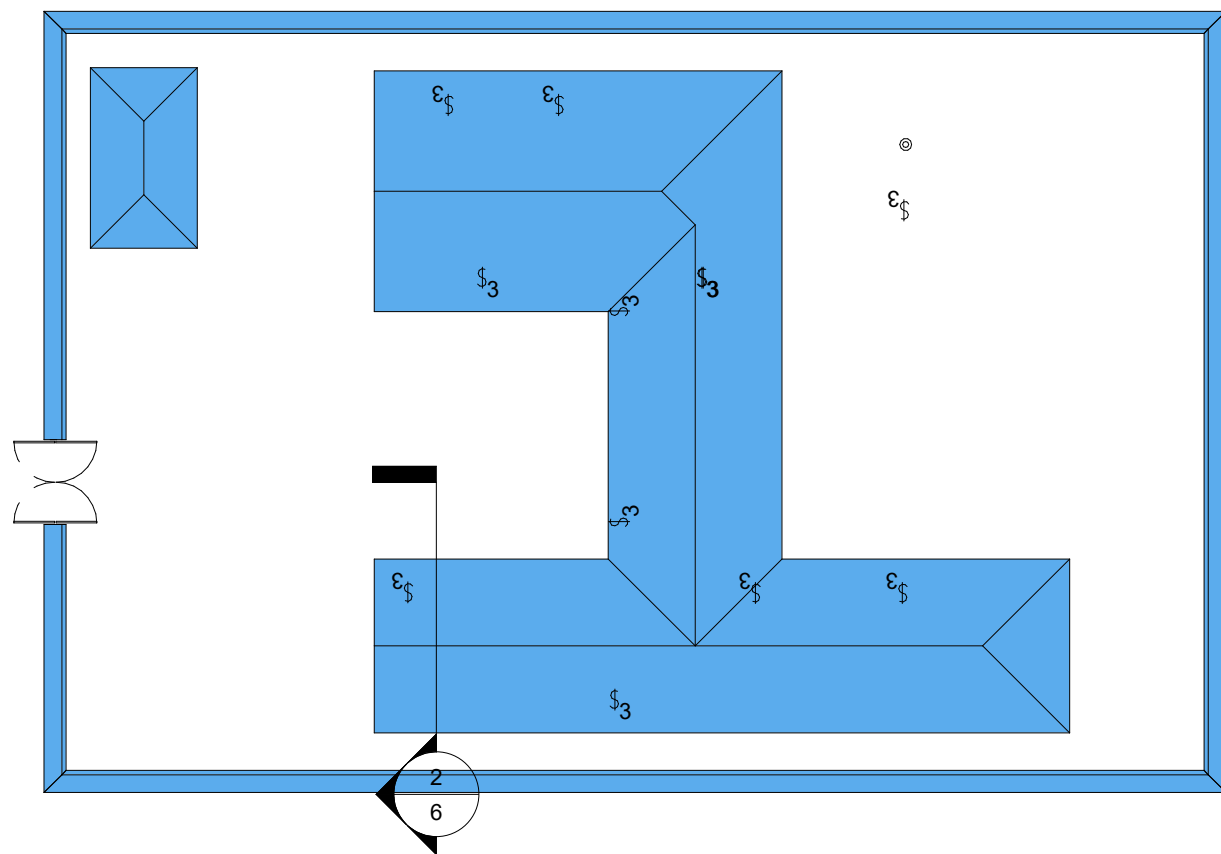

② Section 1
1 : 50



Aluula Adminstration
JPLG 2021 Project

No.	Description	Date

Roof and Truss

Project number	6	
Date		12/3/2022
Drawn by		MOWPT
Checked by		
		Scale As indicated